


GROUND FLOOR PLAN WITH SITE
SCALE: 1:150

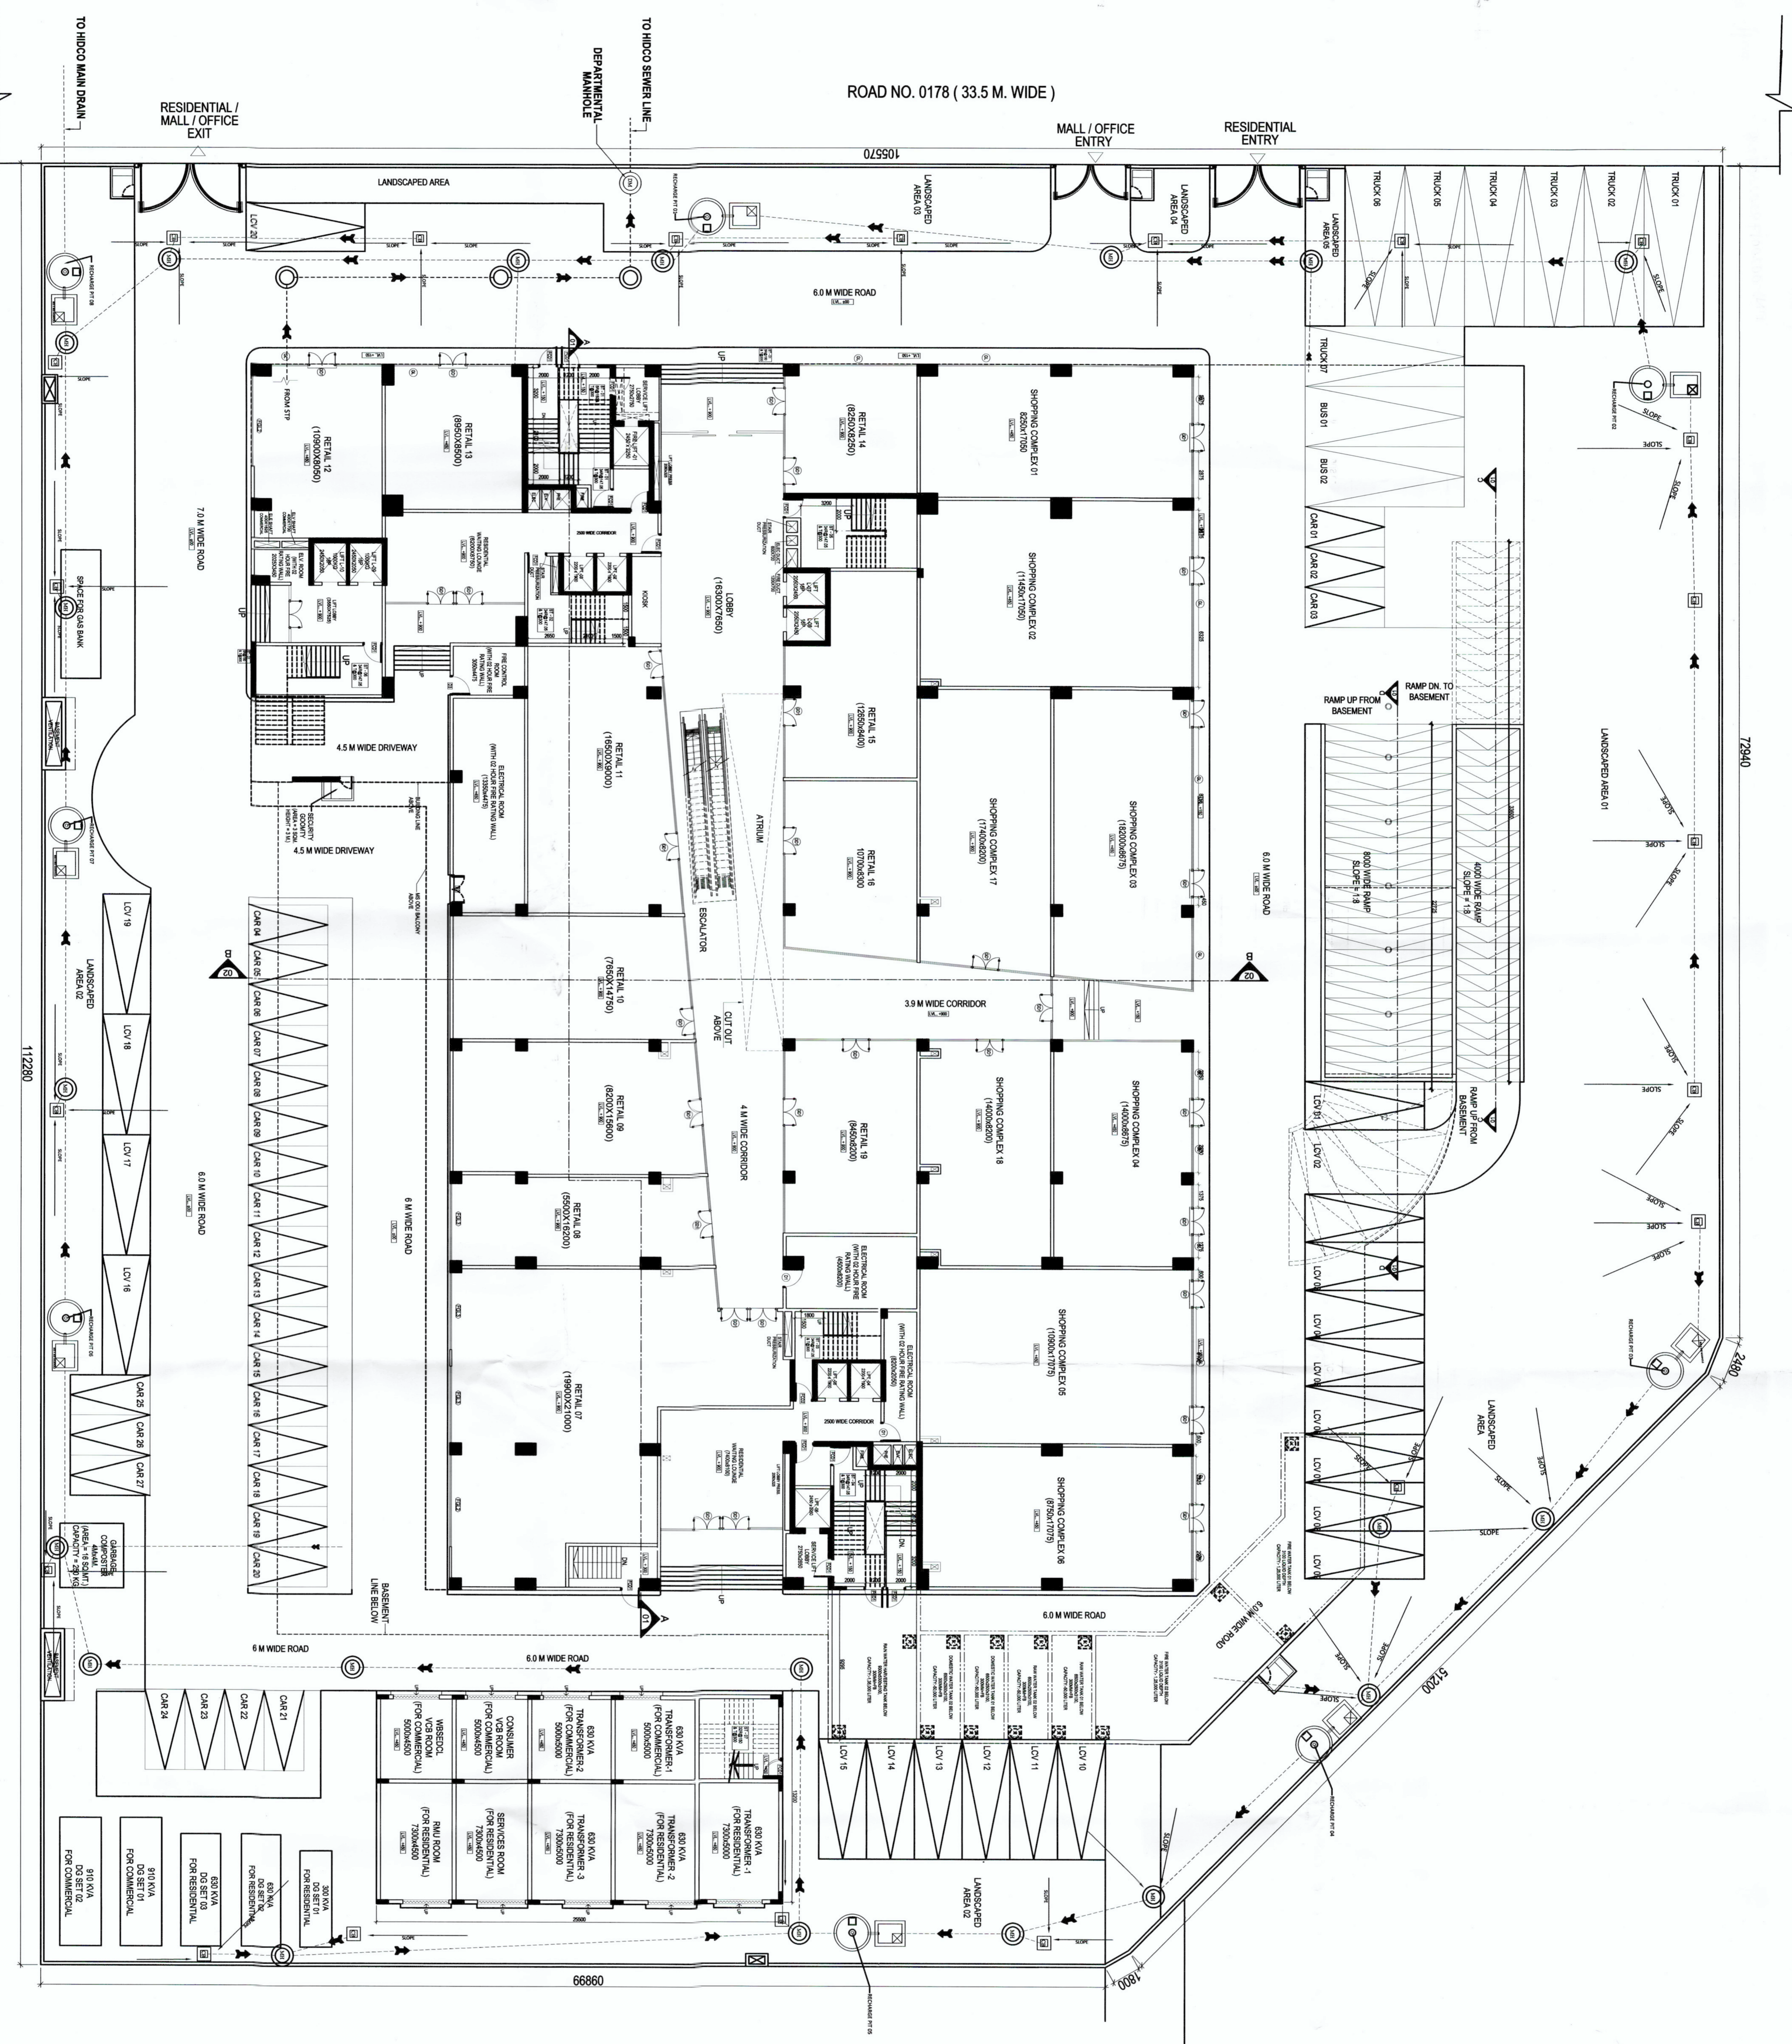

SANCTION DRAWINGS

COPYRIGHT : THIS DRAWING IS THE PROPERTY AND COPYRIGHT OF SALENT. IT SHALL NOT BE COPIED OR REPRODUCED IN ANY MANNER WHATSOEVER AND SHALL BE USED ONLY FOR THE PROJECT ISSUED FOR. THIS DRAWING TO BE EXECUTED ON SITE SUBJECT TO THE APPROVAL OF COMPETENT AUTHORITY.

GENERAL NOTES:

1. ALL DIMENSIONS ARE UNLESS OTHERWISE SPECIFIED.
2. THIS DRAWING SHALL BE READ IN CONNECTION WITH DETAILS, LARGE SCALE.
3. BEFORE THE EXECUTION OF WORK.
4. DETAIL DRAWINGS SHALL SUPERSEDE SMALLER SCALE DRAWINGS.
5. ALL LIFT DOORS WILL BE FIRE RESISTANT.
6. ALL LIFT DOORS WILL BE FIRE RESISTANT.
7. ALL LIFT DOORS WILL BE FIRE RESISTANT.
8. ALL LIFT DOORS WILL BE FIRE RESISTANT.
9. ALL LIFT DOORS WILL BE FIRE RESISTANT.
10. ALL LIFT DOORS WILL BE FIRE RESISTANT.

PLUMBING LEGEND

- STORM MANHOLE
- SEWER MANHOLE
- CATCH BASIN
- SEWER LINE
- STORM LINE

APPLICANT SIGNATURE:
Kishan Kish & Pooja Pvt. Ltd.
Kishan Kish & Pooja
Kishan Kish & Pooja Pvt. Ltd.
Kishan Kish & Pooja Pvt. Ltd.

ARCHITECT'S SIGNATURE:
Jishu K. P. K.
Jishu K. P. K.
Jishu K. P. K.
Jishu K. P. K.

CERTIFICATE OF STRUCTURAL ENGINEER:
I hereby certify that the design and construction of the structure shown in this drawing has been checked and approved by me for the purpose of construction. I am a duly qualified and registered structural engineer in India.

SEVICES DRAWING
SERVICES & DRAINAGE LAYOUT

SCALE: 1:150
DATE: 31/03/2023
DRAWN BY: MB/APC
CHECKED BY: AM/MB
DWG. NO.: RICH/MB/A-S-018