

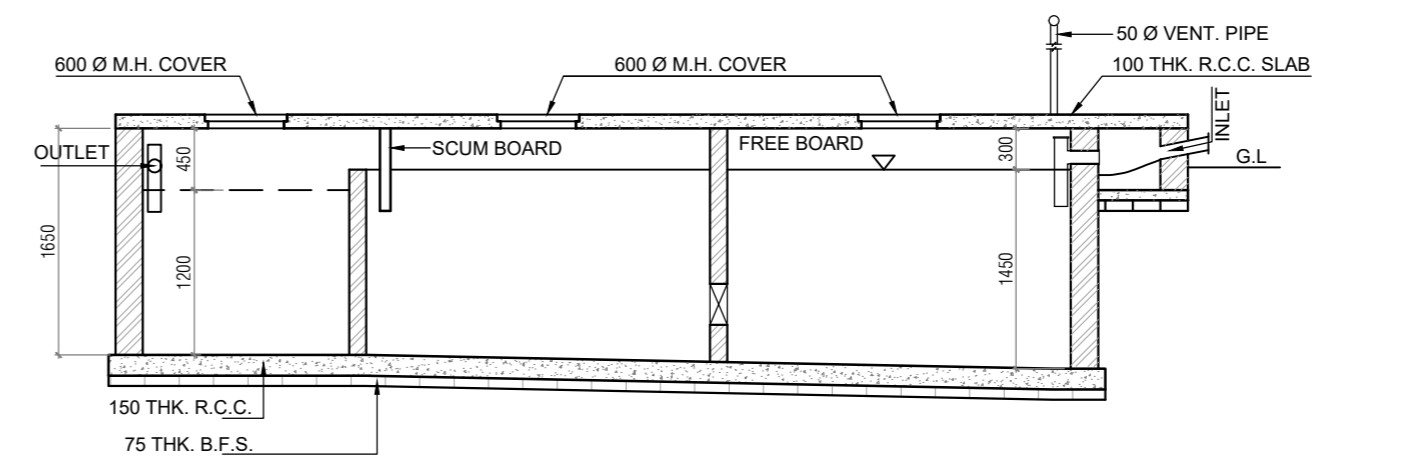
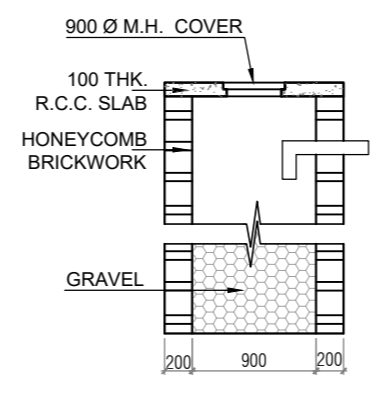


GROUND FLOOR PLAN
SCALE 1:100

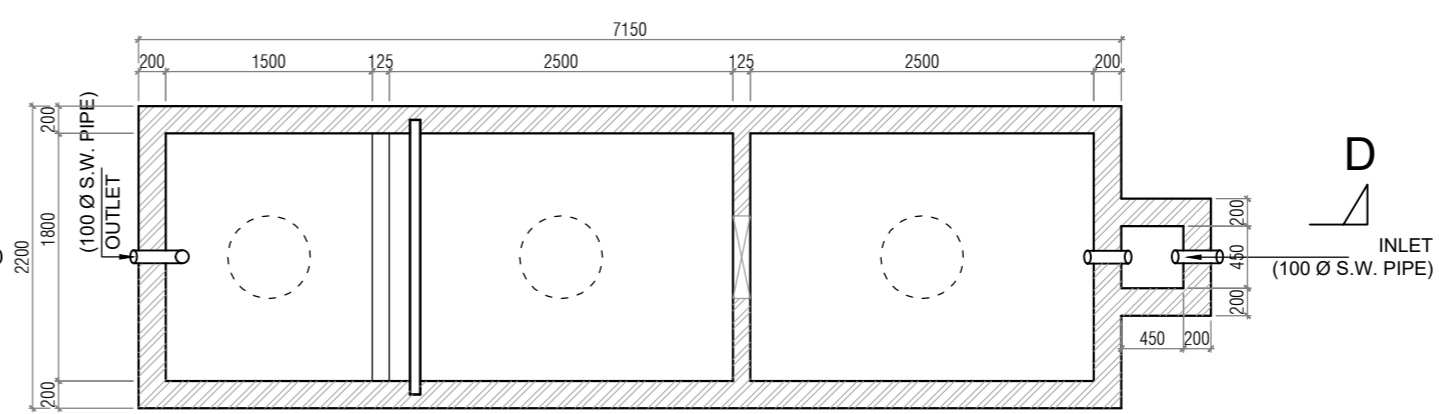


SECTION THROUGH D-D

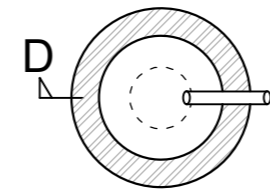


PLAN DETAILS OF SEPTIC TANK & SOAK PIT (FOR 100 USERS)
SCALE 1:50

RAIN WATER HARVESTING	
COVERED AREA (A)	= 353.69 SQM.
MAXIMUM RAINFALL IN 15 MIN. OF LAST 30 YEARS (R)	= 0.030 M.
RUN OFF CO-EFFICIENT (C)	= 0.85
SO, RAINFALL VOLUME (353.69 X 0.030 X 0.85 CUM.)	= 9.019 CUM. = 9.019 LTR.

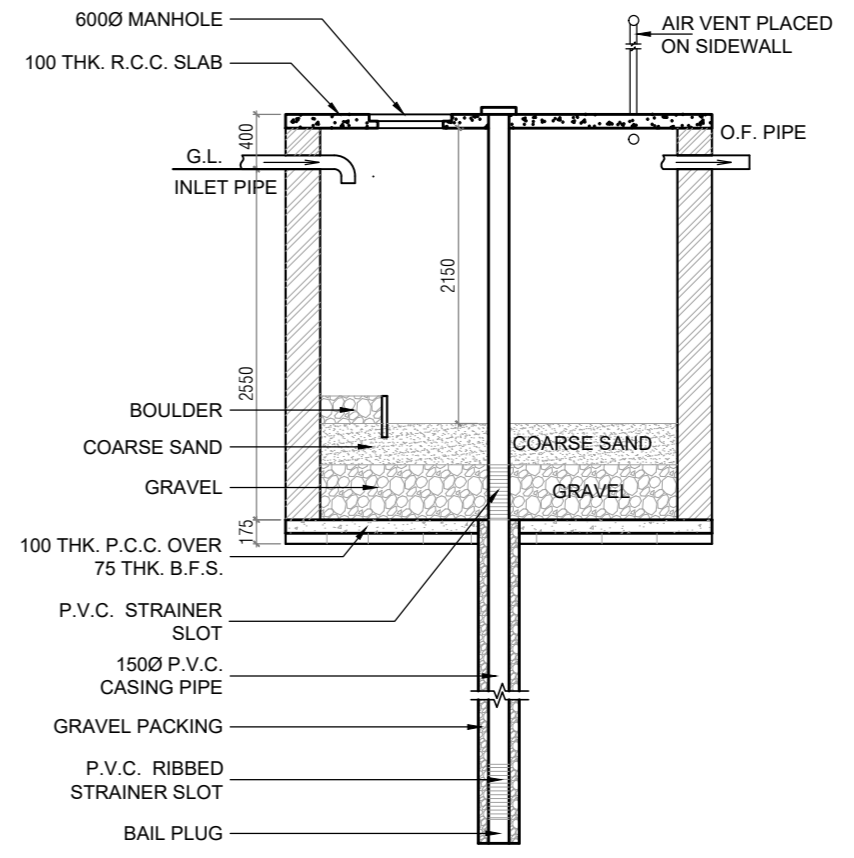

SECTION THROUGH E-E

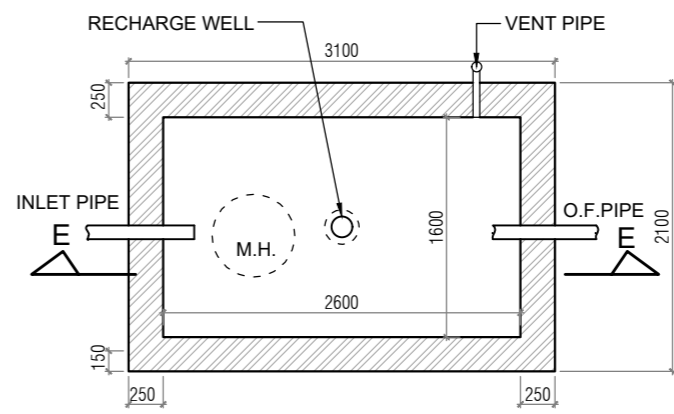

PLAN DETAIL OF RAIN WATER RECHARGE TANK
SCALE 1:50

PROPOSED G+IV STORIED RESIDENTIAL FLAT BUILDING OF 1) MR. APURBANANDA KONAR S/O- LATE SASANKA MOHAN KONAR 2) MR. JADUPATI KONER S/O- LATE SASANKA MOHAN KONAR 3) MRS. KAKALI KONAR W/O- LATE ADWAITA NANDA KONAR 4) MRS. HAIMANTI DUTTA W/O- SUNIRBAN DUTTA (D/O- LATE ADWAITA NANDA KONAR) 5) MR. SOURAV KONAR S/O- LATE ADWAITA NANDA KONAR REPRESENTED "GREEN APPY" BY ITS REPRESENTATIVE AND AUTHORIZED PARTNERS (1) SMT. MOUMITA HALDER & (2) SRI SOUMITRA HALDER AT MOUZA-NARI, J.L. NO. 70, C.S. PLOT NO. 453 & 454, R.S. PLOT NO. 453/4048, 454/4754, L.R. PLOT NO. 966 & 967, C.S. KHATIAN NO. 702, R.S. KHATIAN NO. 1203 & 2056, L.R. KHATIAN NO. 2057, 2058, 43253, 43254 & 43255, WARD NO. 7, MAHALLA - KALNA ROAD, HOLDING NO. 124, UNDER BURDWAN MUNICIPALITY, P.S. BARDHAMAN, DIST. PURBA BARDHAMAN.

- GENERAL NOTES :**
- ALL DIMENSIONS ARE IN MM.
 - 1ST CLASS CEMENT BRICK WORK IN SUPERSTRUCTURE.
 - 125MM THK. 1ST CLASS BRICK WORK 1:4 WITH HB WIRE NETTING.
 - LEAN CONC. 1:1.5:3 WITH 19MM DOWN GRADED STONECHIPS.
 - R.C.C. WORK FOR ROOF SLAB, LINTEL, BEAM, COLUMN (M-20).
 - CEMENT SAND PLASTER 20MM THIK ON OUTSIDE, 15MM THK. AT INSIDE AND 10MM THK. IN CEILING & R.C.C. CHAJJA.
 - 20MM THK. I.P.S. FLOORING WITH NET CEMENT AT TOP INCLUDING SKIRTING.
 - A BRICK FLAT SOLING IN GR. FL. FLOORING & FOUNDATION.
 - TOR STEEL T.BARS FOR COLUMN, BEAMS, LINTELS & SLABS INCLUDING DISTRIBUTORS & BINDERS.
 - HIRE & LABOUR FOR SHUTTERING OF R.C.C. WORKS INCLUDING STOUT PROP. TO BE PLACED AS PER DIRECTION.
 - SANITARY & PLUMBING, FITTING & FIXING COMPLETE AS PER DIRECTION.
 - ALL OUTSIDE WALL 200MM THK. & INSIDE WALL 125MM THK. AS SATED WITH H.B. WIRE NETTING IN EVERY 3RD LAYER.

OFFICIAL USE (U.L.B.) (B.M.)

DRAWING TITLE : RANGE/DRAINAGE SUPPLY LAYOUT DRAWING



022	SCALE : AS MENTIONED	NORTH :
	REVISION : R0	