

SECTION - BB
SCALE 1:100

PROPOSED 4+IV STORIED BUILDING
AT MOUZA - ARAPANCH,
J.L. NO. - 28, R.S. DAG NO.-74, L.R.DAG NO. - 79,
R.S.KHATHAN NO.-55, L.R. KHATHAN NO. - 1129 & 702,
P.S. - SONARPUR, DIST. - SOUTH 24 PGS.
UNDER - SONARPUR II GRAM PANCHAYET.

TITLE : ELEVATION, SECTIONS & DETAILS

DECLARATION
THE STRUCTURAL DESIGN AND DRAWING OF BOTH FOUNDATION AND SUPERSTRUCTURE OF THE BUILDING HAS BEEN MADE BY ME CONSIDERING ALL POSSIBLE LOADS INCLUDING THE SEISMIC LOAD AFTER THE NATIONAL BUILDING CODE OF INDIA AND CERTIFIED THAT IT IS SAFE AND STABLE IN ALL RESPECTS.

REVIEWED UP TO: *[Signature]*
DATE: *[Date]*
DESIGNER NOTICE: *[Text]*

[Signature]
SIGNATURE OF E.S.E.

[Signature]
DR. SANTOSH KUMAR CHAKRABORTY
I.C.E. (M.E. (Civil Branch))
I.A.E. (M.E. (Civil Branch))
I.S.T.A. (S.E. (M.E. (Civil Branch)))
Consulting Geotechnical Engineering
SIGNATURE OF GEO-TECHNICAL ENGINEER

SIGNATURE OF ARCHITECT

[Signature]
AR. DURGA MASAR DAS
Registered Architect
Reg. No. - CE/2007/1053

[Signature]
SIGNATURE OF OWNERS


CONSULTANTS
N.B. CONSTRUCTOR
ARCHITECTS & ENGINEERS
472, SREEMANGAL NAGAR ROAD
GARDI EXTENSION, PO. RA, PIN-751022 (INDIA)

SCALE: 1:100
DATE: 20/05/2024
REVISIONS: 01
SHEET NO. 3/13
OFFICE USE: *[Text]*


Valid and recommended for execution for building Plan No. *[No.]*
All drawings are subject to the final decision of the local authority and the owner. The contractor shall be responsible for the execution of the work in accordance with the approved drawings. The contractor shall be responsible for the execution of the work in accordance with the approved drawings. The contractor shall be responsible for the execution of the work in accordance with the approved drawings.

SANCTIONED


Sanctioned by the District Engineer, South 24 Pgs.
Sanctioned by the District Engineer, South 24 Pgs.
Sanctioned by the District Engineer, South 24 Pgs.

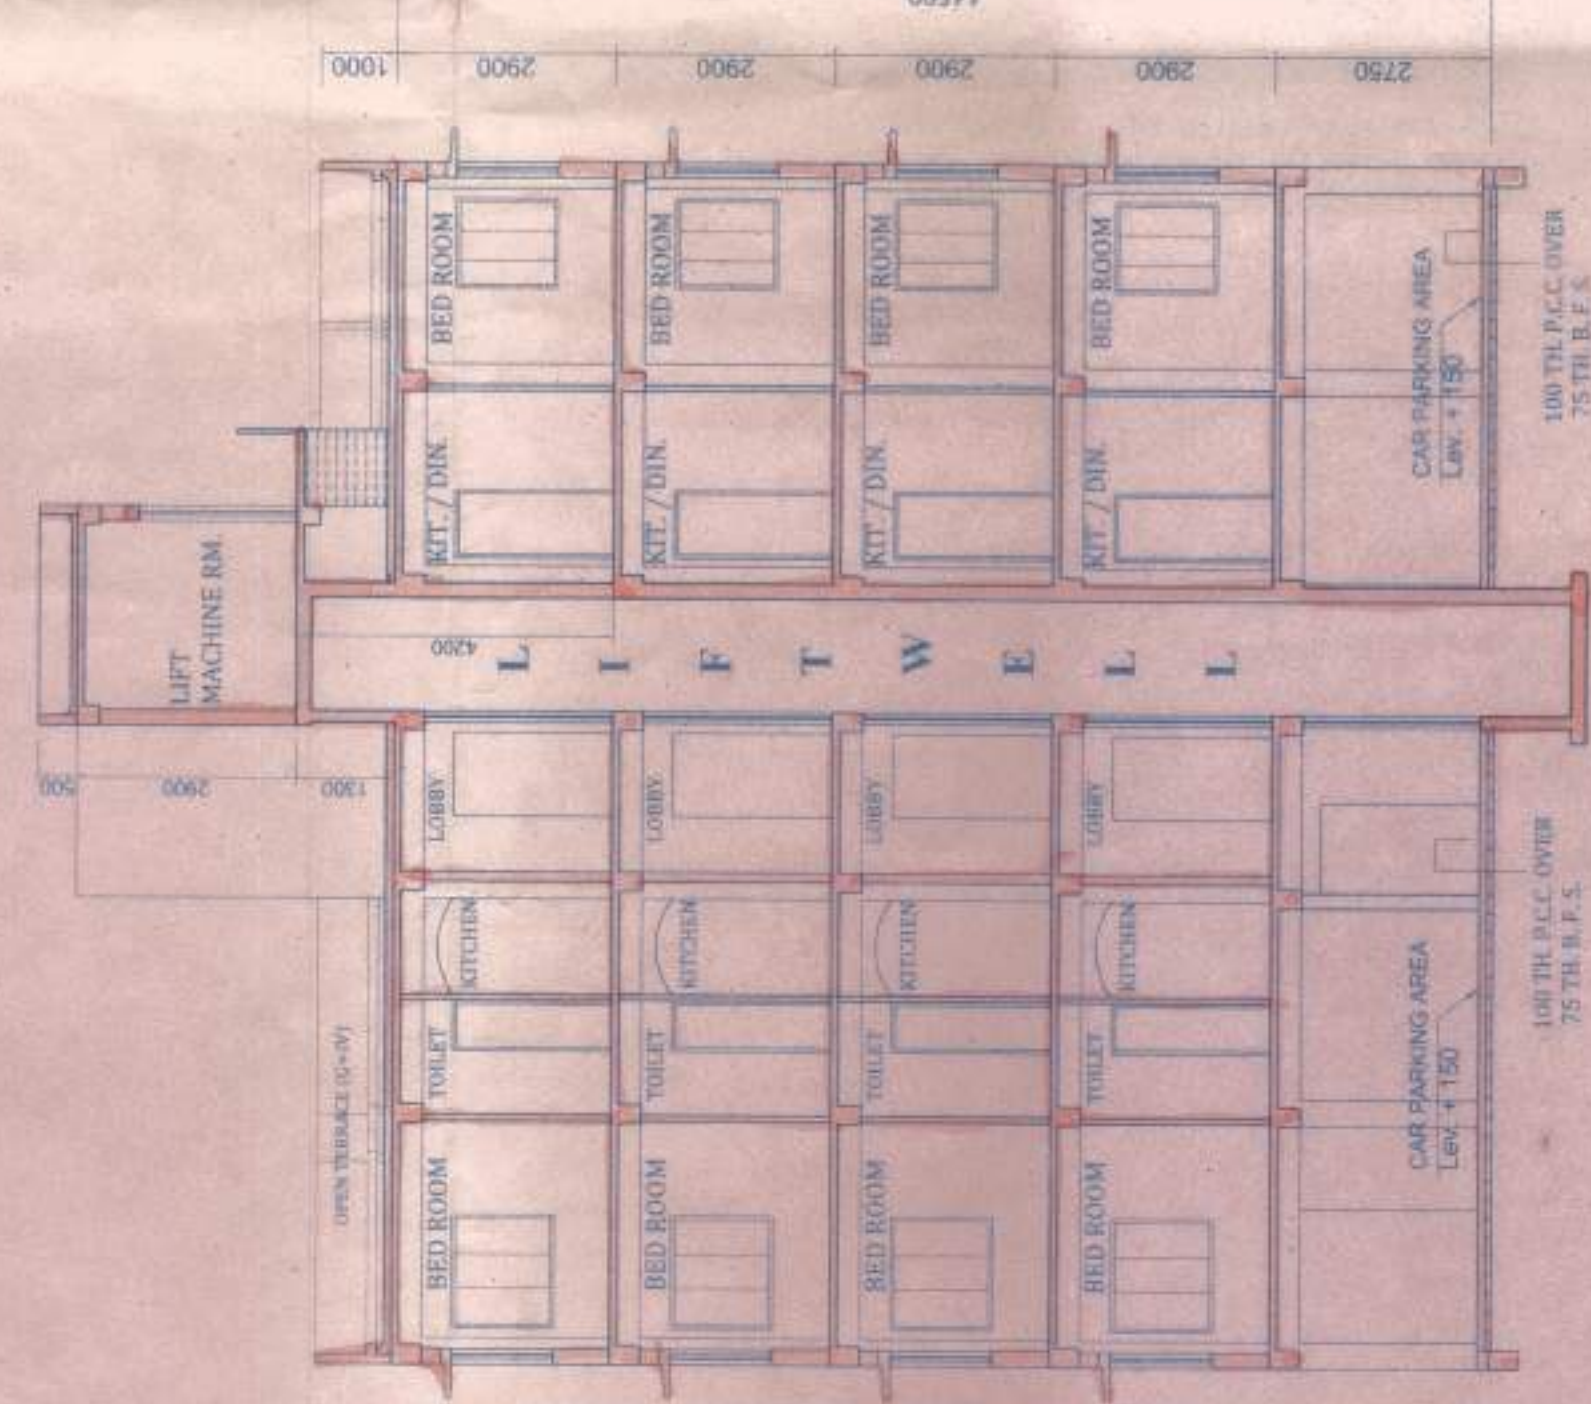


SECTION - CC
SCALE 1:100

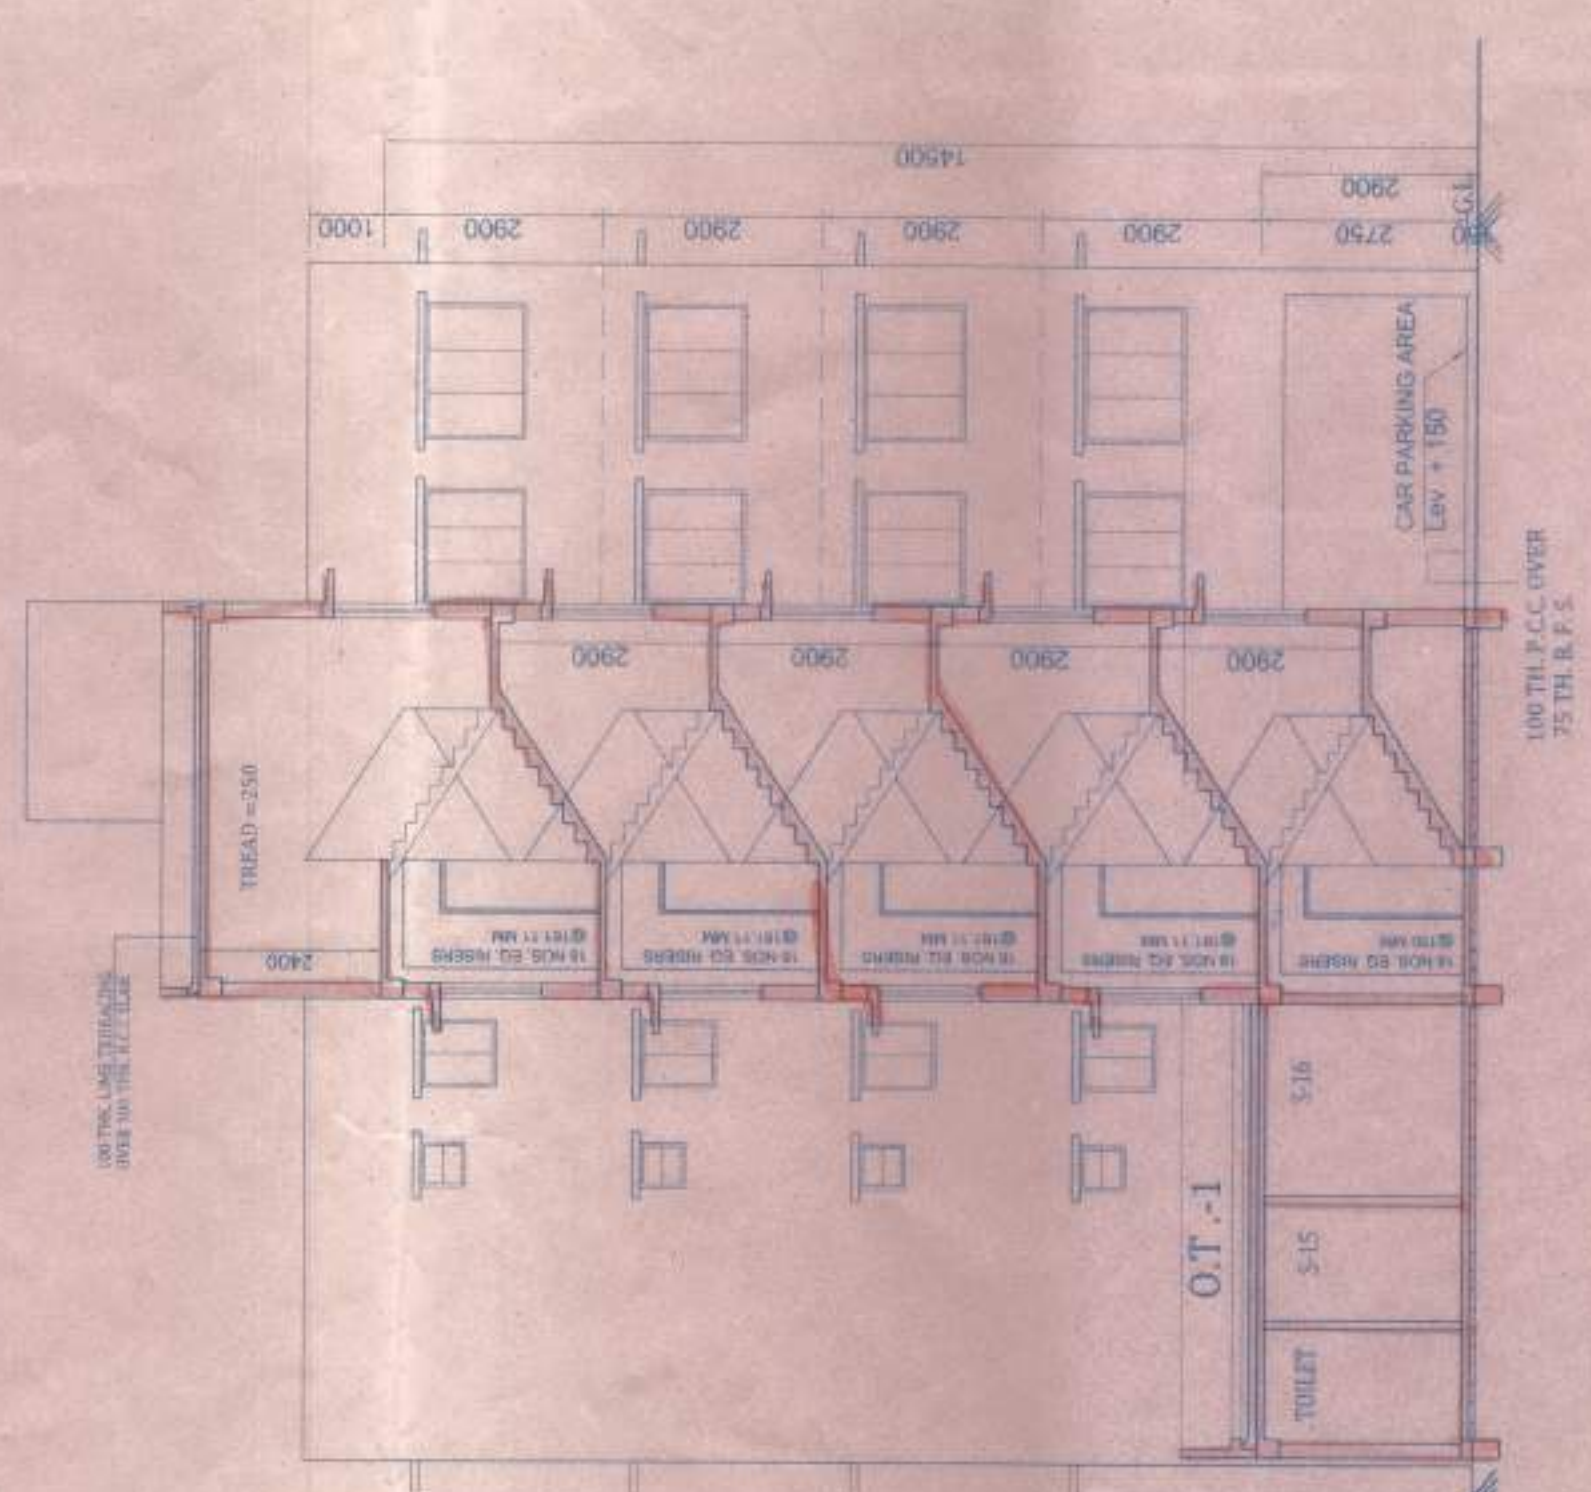


SECTION - AA
SCALE 1:100

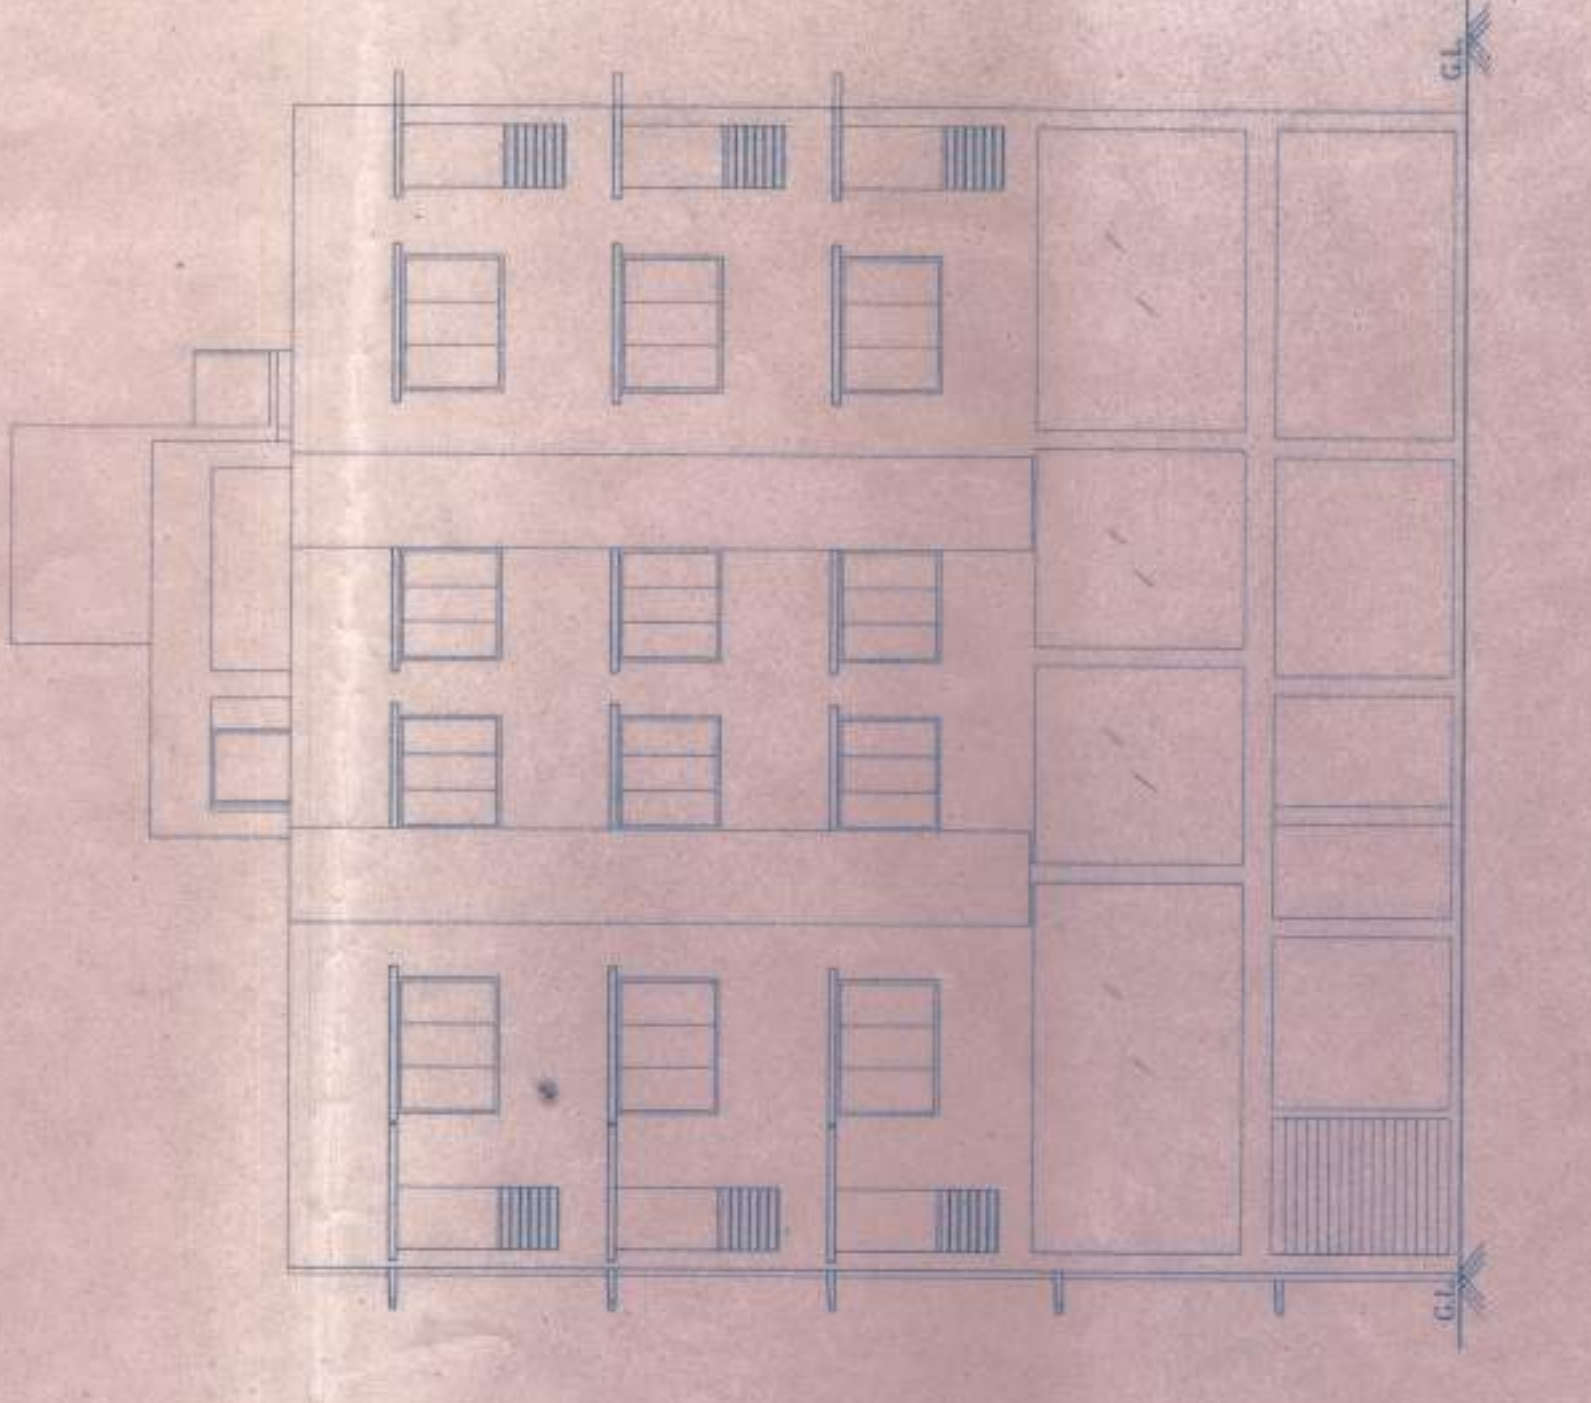


FRONT ELEVATION
SCALE 1:100

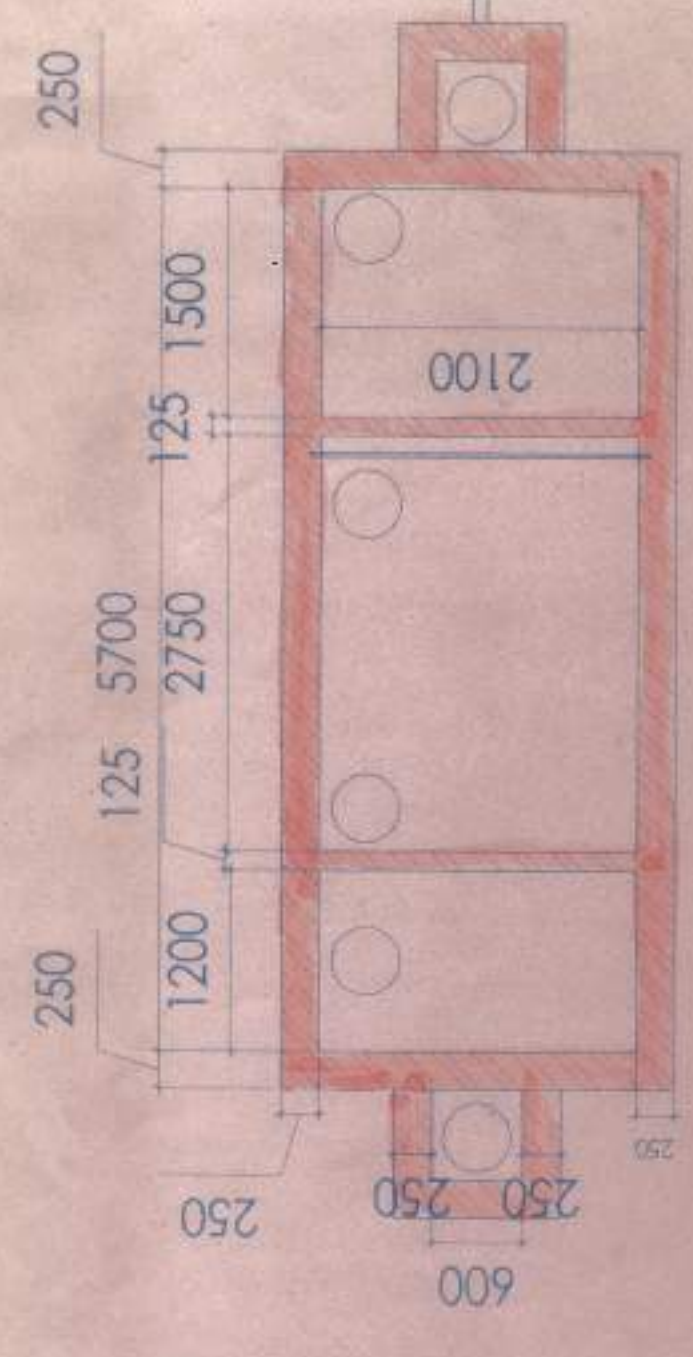


PLAN OF SEPTIC TANK.
100 USERS CAPACITY
SCALE - 1:100

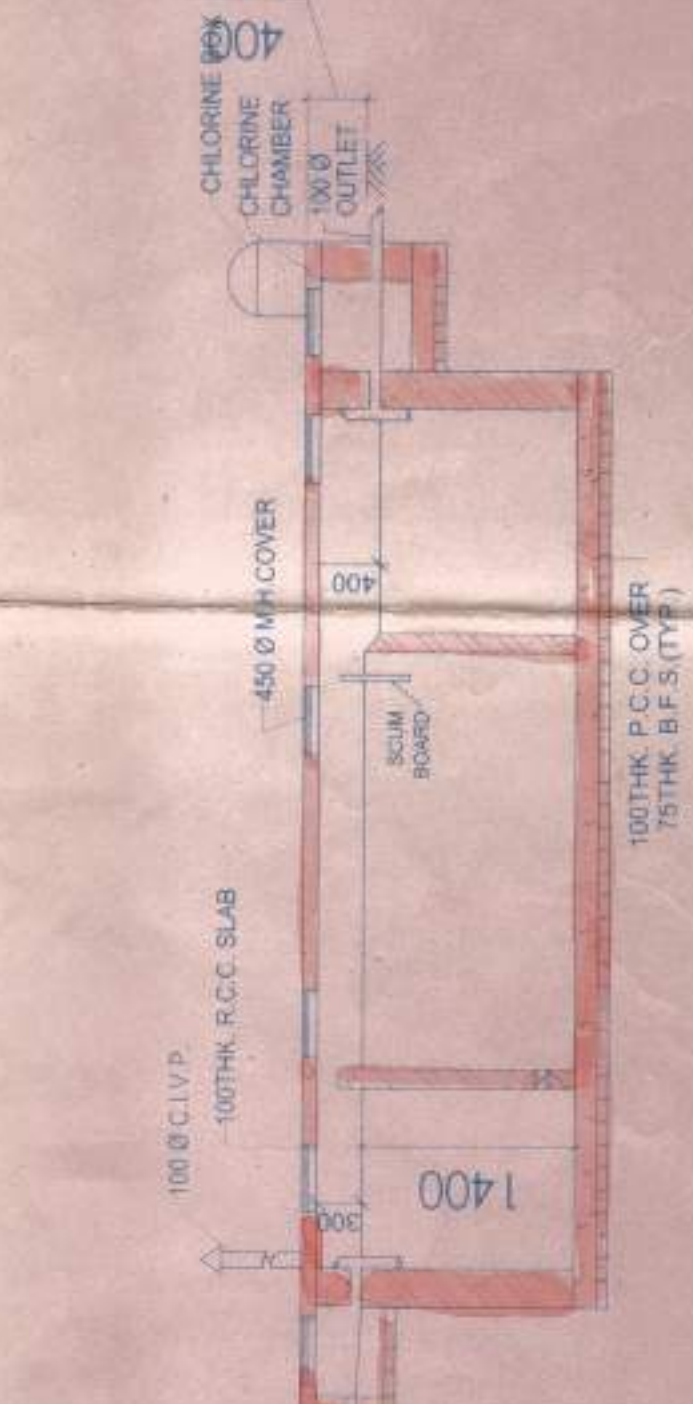


SECTION AT F-F.
SCALE - 1:100

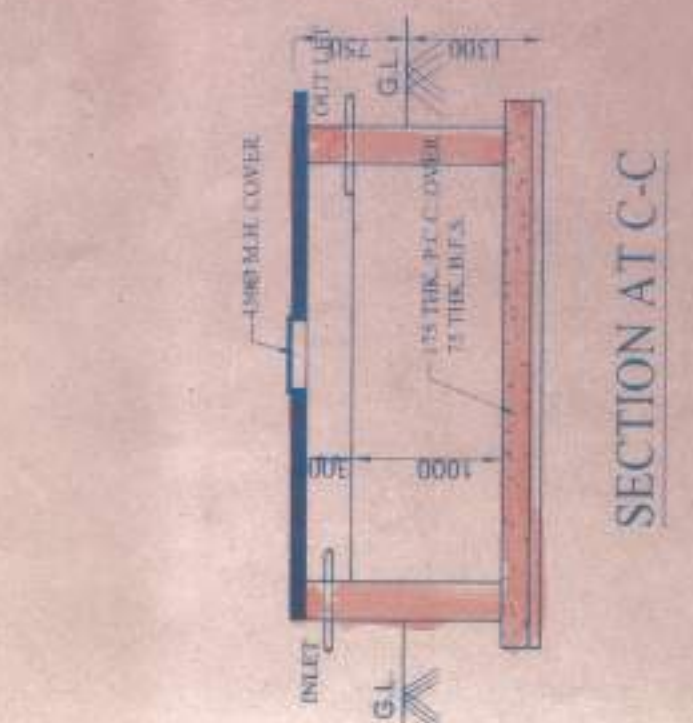

SECTION AT C-C

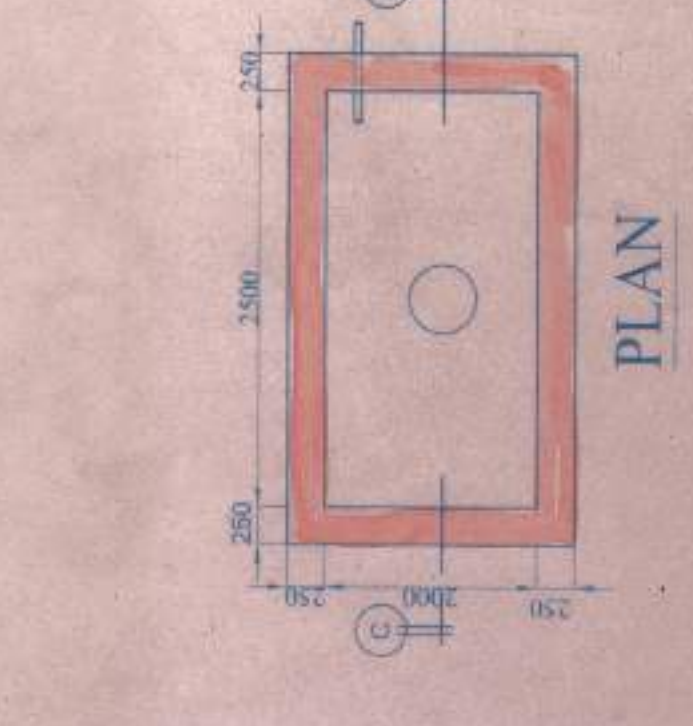

DETAIL OF S.U.G. WATER
RESERVOIR
CAP. - 5000 LITRES.
SCALE - 1:50

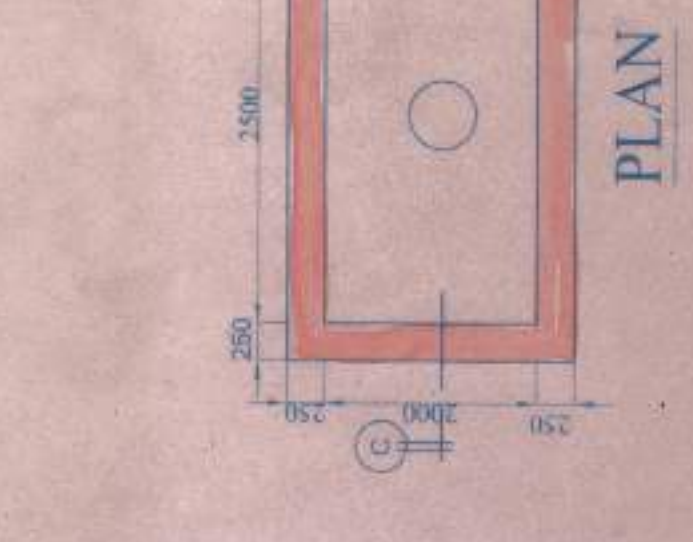

PLAN