

GENERAL NOTES:

- All dimensions are as per approved/contract documents, including.
- All dimensions are as per approved/contract documents, including.
- All dimensions are as per approved/contract documents, including.

PROPERTY INFORMATION


NO.	AREA	DEPTH	WIDTH	REMARKS
1	1500 STP BYPASS	1500	1500	
2	1500 STP BYPASS	1500	1500	
3	1500 STP BYPASS	1500	1500	
4	1500 STP BYPASS	1500	1500	
5	1500 STP BYPASS	1500	1500	
6	1500 STP BYPASS	1500	1500	
7	1500 STP BYPASS	1500	1500	
8	1500 STP BYPASS	1500	1500	
9	1500 STP BYPASS	1500	1500	
10	1500 STP BYPASS	1500	1500	
11	1500 STP BYPASS	1500	1500	
12	1500 STP BYPASS	1500	1500	
13	1500 STP BYPASS	1500	1500	
14	1500 STP BYPASS	1500	1500	
15	1500 STP BYPASS	1500	1500	

CONTRACTOR'S SIGNATURE

DATE: 08.12.19

PROJECT: PROPOSED 8+10 FLOOR BUSINESS BUILDING AT PLOT NO 1, BLOCK - LA IN SECTOR - II, BEHANAGARI (SALT LAKE CITY), P.S. - BEHANAGARI, DISTRICT - NORTH 24 PARGANAH, KOLKATA - 700098

CONSULTANT: ARCHITECT

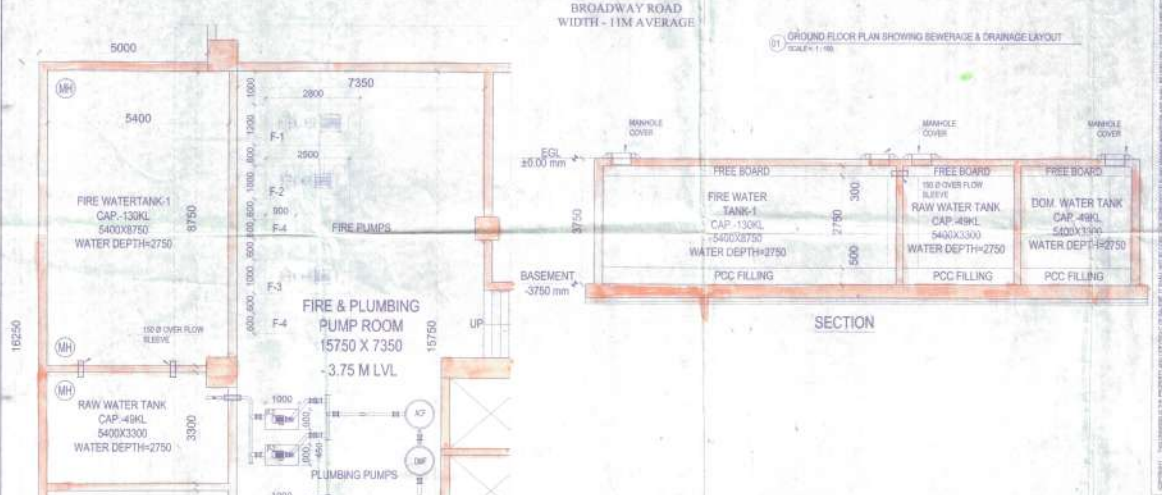

ARCHITECT'S SIGNATURE

DATE: 08.12.19

PROJECT: PROPOSED 8+10 FLOOR BUSINESS BUILDING AT PLOT NO 1, BLOCK - LA IN SECTOR - II, BEHANAGARI (SALT LAKE CITY), P.S. - BEHANAGARI, DISTRICT - NORTH 24 PARGANAH, KOLKATA - 700098

CONSULTANT: ARCHITECT

- LEGEND:**
- STORM WATER LINE
 - SEWERAGE LINE
 - MUNICIPAL WATER SUPPLY LINE
 - 1500 STP BYPASS
 - CATCH BASIN SIZE=450x450mm
 - MANHOLE SIZE=900x800mm
 - MANHOLE SIZE=800mm DIA

CONTRACTOR'S SIGNATURE

DATE: 08.12.19

PROJECT: PROPOSED 8+10 FLOOR BUSINESS BUILDING AT PLOT NO 1, BLOCK - LA IN SECTOR - II, BEHANAGARI (SALT LAKE CITY), P.S. - BEHANAGARI, DISTRICT - NORTH 24 PARGANAH, KOLKATA - 700098

CONSULTANT: ARCHITECT

NO. DATE ITEM

REVISIONS

ARCHITECTURAL DRAWING

GROUND FLOOR PLAN SHOWING SEWERAGE & DRAINAGE LAYOUT WITH U.G.W.R. DETAIL.

SCALE: 1:100

DATE: 08.12.19

DRAWN BY: SHIL

CHECKED BY: SS

DWG. NO: PCD/ARCH/601A