

NO.	TYPE	DESCRIPTION
1	ALUMINUM FRAME GLASS BLINDING	
2	ALUMINUM FRAME GLASS BLINDING	
3	ALUMINUM FRAME GLASS BLINDING	
4	ALUMINUM FRAME GLASS BLINDING	
5	ALUMINUM FRAME GLASS BLINDING	
6	ALUMINUM FRAME GLASS BLINDING	
7	ALUMINUM FRAME GLASS BLINDING	
8	ALUMINUM FRAME GLASS BLINDING	
9	ALUMINUM FRAME GLASS BLINDING	
10	ALUMINUM FRAME GLASS BLINDING	
11	ALUMINUM FRAME GLASS BLINDING	
12	ALUMINUM FRAME GLASS BLINDING	
13	ALUMINUM FRAME GLASS BLINDING	
14	ALUMINUM FRAME GLASS BLINDING	
15	ALUMINUM FRAME GLASS BLINDING	
16	ALUMINUM FRAME GLASS BLINDING	
17	ALUMINUM FRAME GLASS BLINDING	
18	ALUMINUM FRAME GLASS BLINDING	
19	ALUMINUM FRAME GLASS BLINDING	
20	ALUMINUM FRAME GLASS BLINDING	

SCALE: 1:2500
---------------

**CERTIFICATE OF STRUCTURAL ENGINEER**

THIS IS TO CERTIFY THAT THE STRUCTURAL DESIGN AND DRAWING OF THE FOUNDATION AND SUPER STRUCTURE OF THE BUILDING POSSIBLE LOADS INCLUDING THE SEISMIC LOAD AS PER THE NATIONAL BUILDING CODE OF INDIA AND CERTIFIED THAT IT IS SAFE AND STABLE IN ALL RESPECTS.

**Signature: Vignesh K. ROY**  
 VIGNESH K. ROY  
 M.E. (Structural)  
 SAC (Encl. No. 122/2008)  
 DDC, Engineering and Survey  
 Chennai-600 028, India

**CERTIFICATE OF ARCHITECT**

DO HEREBY CERTIFY WITH FULL RESPONSIBILITY THAT THE BUILDING PLAN HAS BEEN DRAWN UP AS PER K.M.C. BUILDING RULE-2009 AS AMENDED FROM TIME TO TIME.

**Signature: M. S. Srinivasan**  
 M. S. SRINIVASAN  
 A.C.E. (Encl. No. 122/2008)  
 A.C.E. (Encl. No. 122/2008)  
 N.C. Encl. No. 122/2008  
 25, Lakshmi Nagar, Chennai-600 028, India

S/N	TYPE	SIZE (mm)	DESCRIPTION
1	ALUMINIUM FRAME GLASS WINDOW	1000 X 1500	ALUMINIUM FRAME GLASS WINDOW
2	ALUMINIUM FRAME GLASS WINDOW	1000 X 1500	ALUMINIUM FRAME GLASS WINDOW
3	ALUMINIUM FRAME GLASS WINDOW	1000 X 1500	ALUMINIUM FRAME GLASS WINDOW
4	ALUMINIUM FRAME GLASS WINDOW	1000 X 1500	ALUMINIUM FRAME GLASS WINDOW
5	ALUMINIUM FRAME GLASS WINDOW	1000 X 1500	ALUMINIUM FRAME GLASS WINDOW
6	ALUMINIUM FRAME GLASS WINDOW	1000 X 1500	ALUMINIUM FRAME GLASS WINDOW
7	ALUMINIUM FRAME GLASS WINDOW	1000 X 1500	ALUMINIUM FRAME GLASS WINDOW
8	ALUMINIUM FRAME GLASS WINDOW	1000 X 1500	ALUMINIUM FRAME GLASS WINDOW
9	ALUMINIUM FRAME GLASS WINDOW	1000 X 1500	ALUMINIUM FRAME GLASS WINDOW
10	ALUMINIUM FRAME GLASS WINDOW	1000 X 1500	ALUMINIUM FRAME GLASS WINDOW
11	ALUMINIUM FRAME GLASS WINDOW	1000 X 1500	ALUMINIUM FRAME GLASS WINDOW
12	ALUMINIUM FRAME GLASS WINDOW	1000 X 1500	ALUMINIUM FRAME GLASS WINDOW
13	ALUMINIUM FRAME GLASS WINDOW	1000 X 1500	ALUMINIUM FRAME GLASS WINDOW
14	ALUMINIUM FRAME GLASS WINDOW	1000 X 1500	ALUMINIUM FRAME GLASS WINDOW
15	ALUMINIUM FRAME GLASS WINDOW	1000 X 1500	ALUMINIUM FRAME GLASS WINDOW
16	ALUMINIUM FRAME GLASS WINDOW	1000 X 1500	ALUMINIUM FRAME GLASS WINDOW
17	ALUMINIUM FRAME GLASS WINDOW	1000 X 1500	ALUMINIUM FRAME GLASS WINDOW
18	ALUMINIUM FRAME GLASS WINDOW	1000 X 1500	ALUMINIUM FRAME GLASS WINDOW
19	ALUMINIUM FRAME GLASS WINDOW	1000 X 1500	ALUMINIUM FRAME GLASS WINDOW
20	ALUMINIUM FRAME GLASS WINDOW	1000 X 1500	ALUMINIUM FRAME GLASS WINDOW

S/N	TYPE	SIZE (mm)	DESCRIPTION
1	ALUMINIUM FRAME GLASS DOOR	1000 X 2000	ALUMINIUM FRAME GLASS DOOR
2	ALUMINIUM FRAME GLASS DOOR	1000 X 2000	ALUMINIUM FRAME GLASS DOOR
3	ALUMINIUM FRAME GLASS DOOR	1000 X 2000	ALUMINIUM FRAME GLASS DOOR
4	ALUMINIUM FRAME GLASS DOOR	1000 X 2000	ALUMINIUM FRAME GLASS DOOR
5	ALUMINIUM FRAME GLASS DOOR	1000 X 2000	ALUMINIUM FRAME GLASS DOOR
6	ALUMINIUM FRAME GLASS DOOR	1000 X 2000	ALUMINIUM FRAME GLASS DOOR
7	ALUMINIUM FRAME GLASS DOOR	1000 X 2000	ALUMINIUM FRAME GLASS DOOR
8	ALUMINIUM FRAME GLASS DOOR	1000 X 2000	ALUMINIUM FRAME GLASS DOOR
9	ALUMINIUM FRAME GLASS DOOR	1000 X 2000	ALUMINIUM FRAME GLASS DOOR
10	ALUMINIUM FRAME GLASS DOOR	1000 X 2000	ALUMINIUM FRAME GLASS DOOR
11	ALUMINIUM FRAME GLASS DOOR	1000 X 2000	ALUMINIUM FRAME GLASS DOOR
12	ALUMINIUM FRAME GLASS DOOR	1000 X 2000	ALUMINIUM FRAME GLASS DOOR
13	ALUMINIUM FRAME GLASS DOOR	1000 X 2000	ALUMINIUM FRAME GLASS DOOR
14	ALUMINIUM FRAME GLASS DOOR	1000 X 2000	ALUMINIUM FRAME GLASS DOOR
15	ALUMINIUM FRAME GLASS DOOR	1000 X 2000	ALUMINIUM FRAME GLASS DOOR
16	ALUMINIUM FRAME GLASS DOOR	1000 X 2000	ALUMINIUM FRAME GLASS DOOR
17	ALUMINIUM FRAME GLASS DOOR	1000 X 2000	ALUMINIUM FRAME GLASS DOOR
18	ALUMINIUM FRAME GLASS DOOR	1000 X 2000	ALUMINIUM FRAME GLASS DOOR
19	ALUMINIUM FRAME GLASS DOOR	1000 X 2000	ALUMINIUM FRAME GLASS DOOR
20	ALUMINIUM FRAME GLASS DOOR	1000 X 2000	ALUMINIUM FRAME GLASS DOOR

FLOOR	LEVEL (METER)
4TH	+15.18
5TH	+18.59
6TH	+21.99
7TH	+25.39
8TH	+28.79
9TH	+32.19
10TH	+35.59
11TH	+38.99
12TH	+42.39
13TH	+45.79
14TH	+49.19
15TH	+52.59
16TH	+55.99
17TH	+59.39
18TH	+62.79
19TH	+66.19
20TH	+69.59
21ST	+72.99
22ND	+76.39
23RD	+79.79
24TH	+83.19
25TH	+86.59
26TH	+89.99
27TH	+93.39

**CLIENT**  
 FORUM PROJECTS PVT. LTD.  
 KOLKATA, 700 001.


**PROPOSED ADDITION OF TWO FLOORS US 3B OF KMC ACT 1980 READ WITH UR 69A OF KMC ACT 1980 AND UP TO EXISTING SANCTIONED (B/G-XXXX) STORES RESIDENTIAL BUILDING INCLUDING ALTERATIONS (UR 28 2(a) & 2(b) OF KOLKATA RULES 2009 AT PREMISES NO. 100/IA EASTERN METROPOLITAN BYE PASSES, WARD NO. 66, BOROUGH - VII, KOLKATA - 700 048**

(i) Building Permit issued by KMC 048 B.P. No. 2017/0052 dated 06.08.2011.  
 (ii) Subsequently approved modifications UR P/2018/015 dated 28.01.2018 M.C. No. 198/MC/M/N/015/2018 dated 28.01.2018.  
 (iii) Subsequently revalidated UR 389 for two years on dated 26/09/2016.


**LOCAL STRUCTURAL ENGINEERING CONSULTANT:**  
 M.N. CONSULTANTS PVT. LTD.  
 M.N.C. HOUSE  
 14, RIVER VALLEY ROAD, BHOWANIPUR, CHENNAI-600 028  
 PRINCIPAL STRUCTURAL CONSULTANT:  
 K. Srinivasan  
 M.E. (Structural)

**DESIGN ARCHITECT:**  
 arc studio  
 45, RIVER VALLEY ROAD, BHOWANIPUR, CHENNAI-600 028


**EXECUTIVE ARCHITECT:**  
 PRADEEP K. SINGH  
 45, RIVER VALLEY ROAD, BHOWANIPUR, CHENNAI-600 028

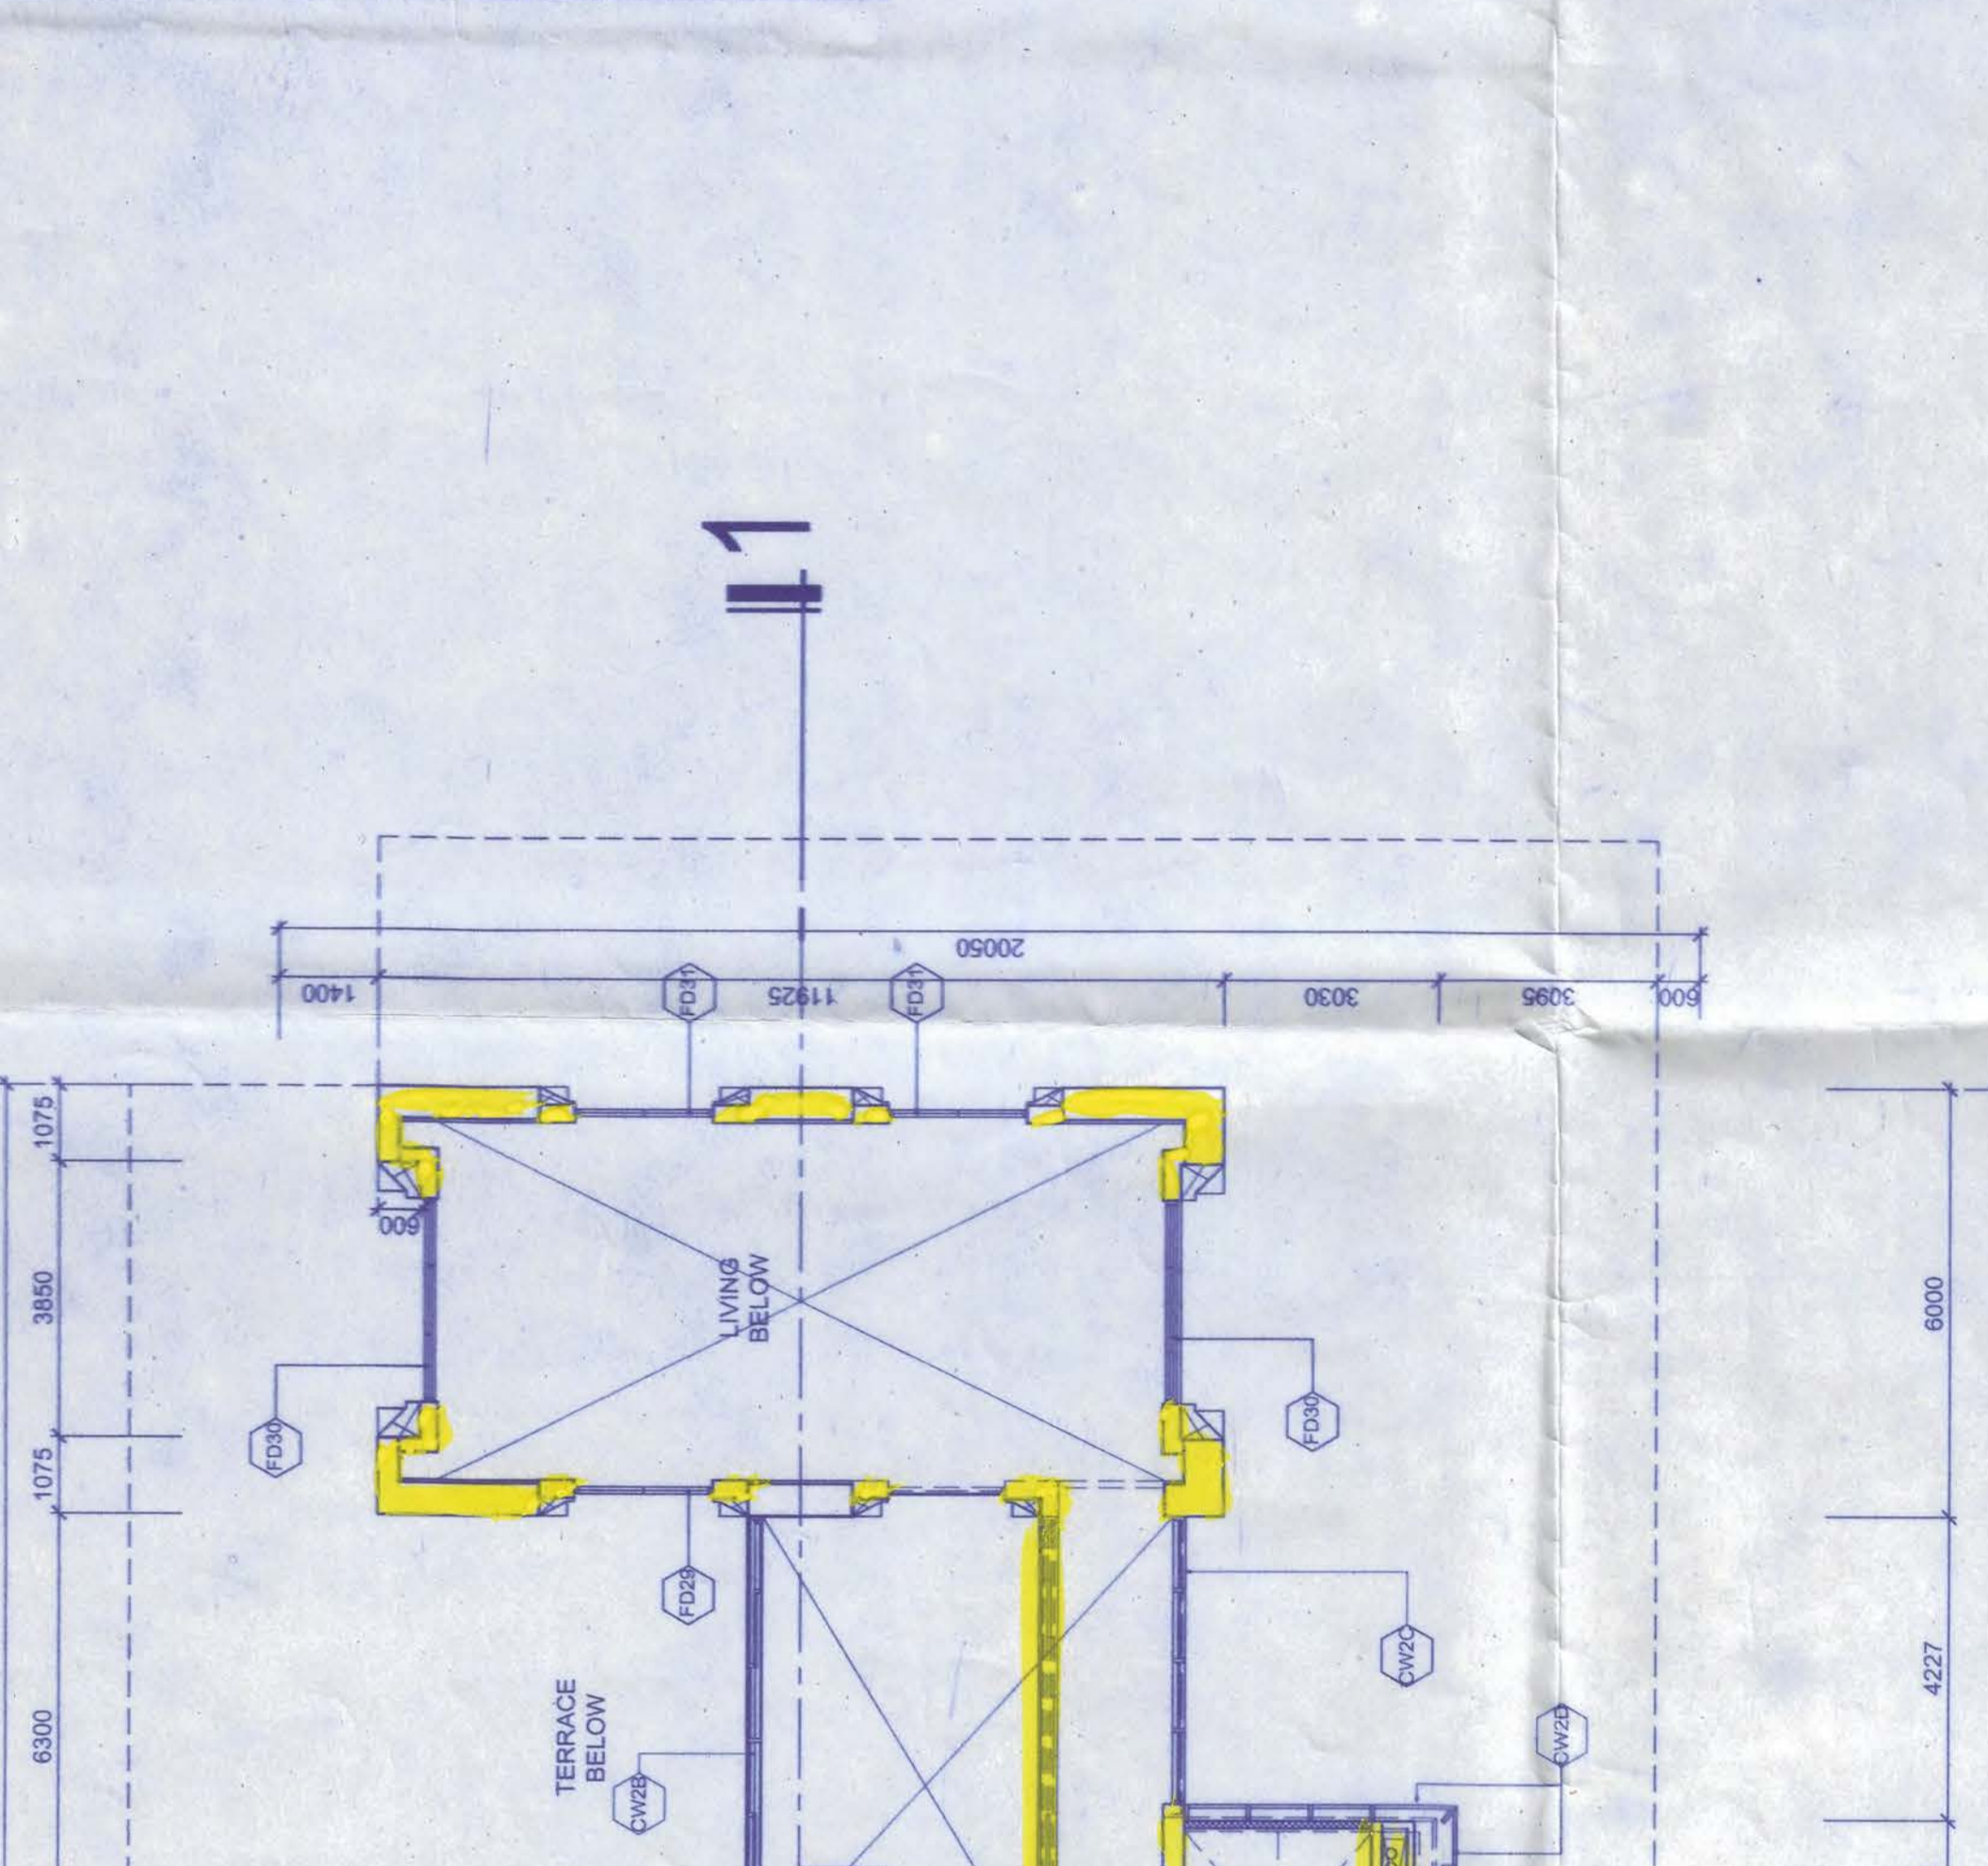


**UPPER DUPLEX VILLA**  
**WING A - TYPICAL FLOOR AT LEVEL- 05, 09, 11, 13, 23,**  
 scale 1:100

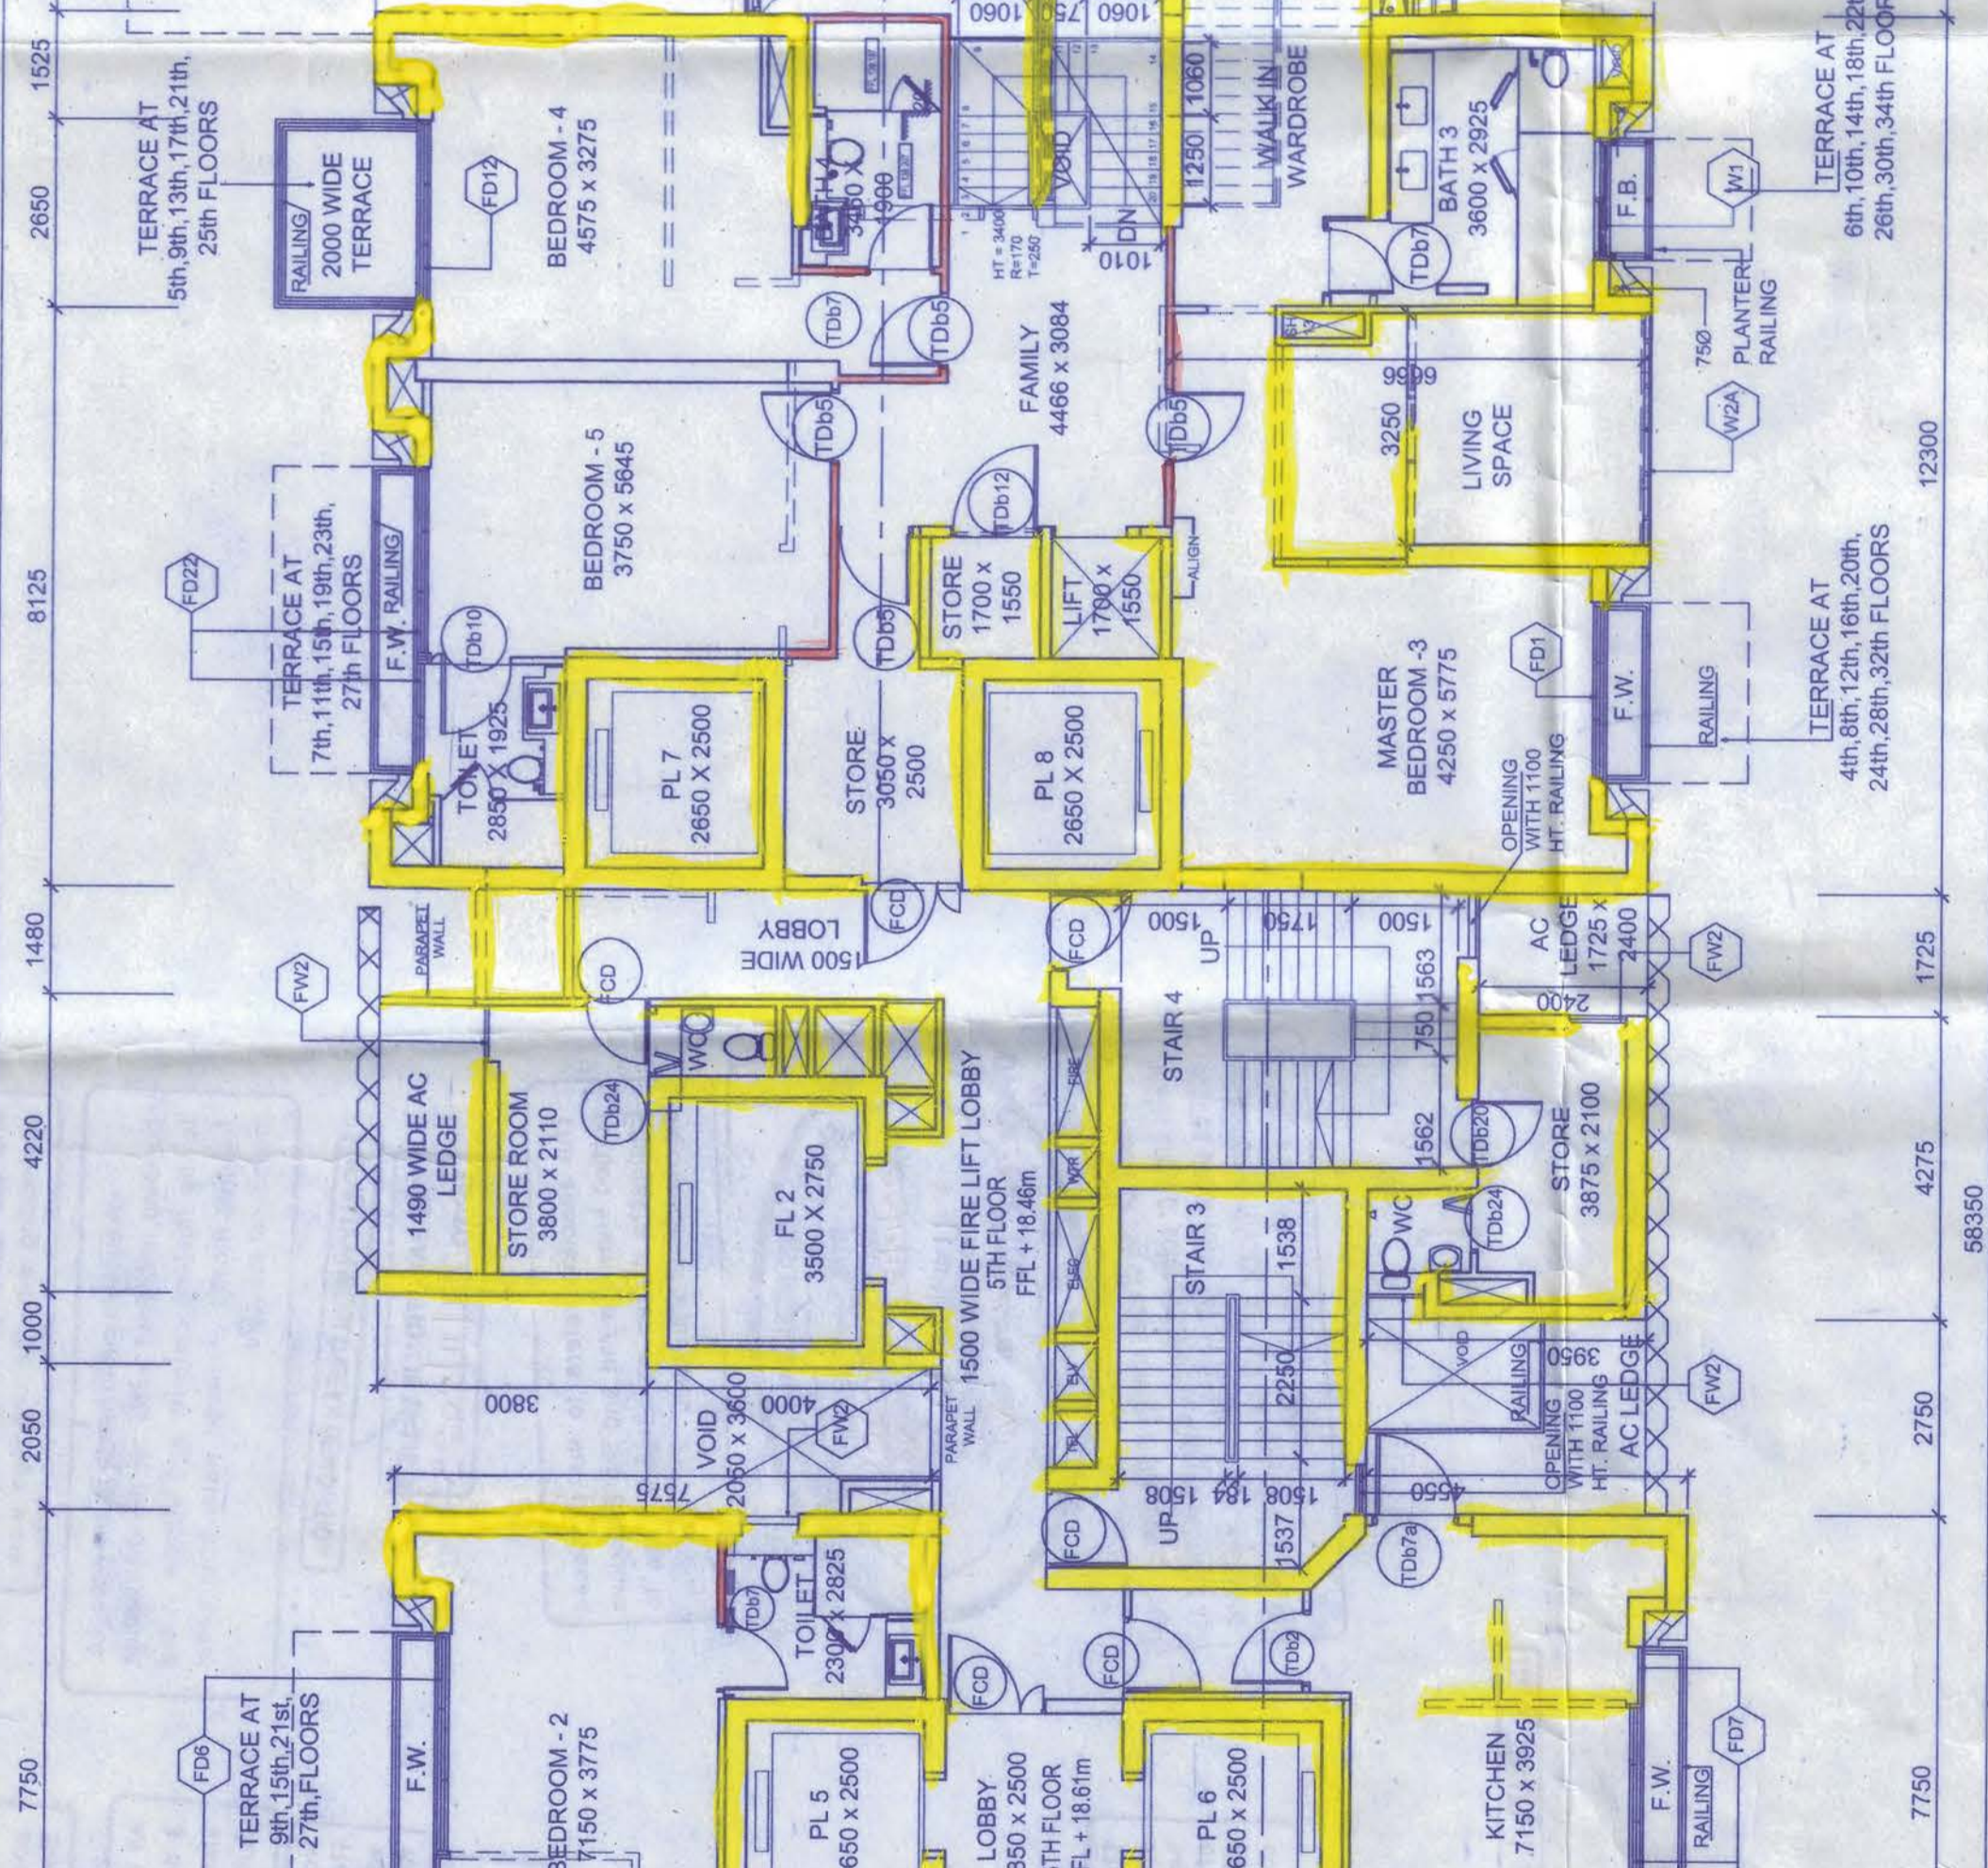


**SIMPLEX VILLA**  
**WING A - TYPICAL FLOOR AT LEVEL- 04, 12, 22,**  
 scale 1:100

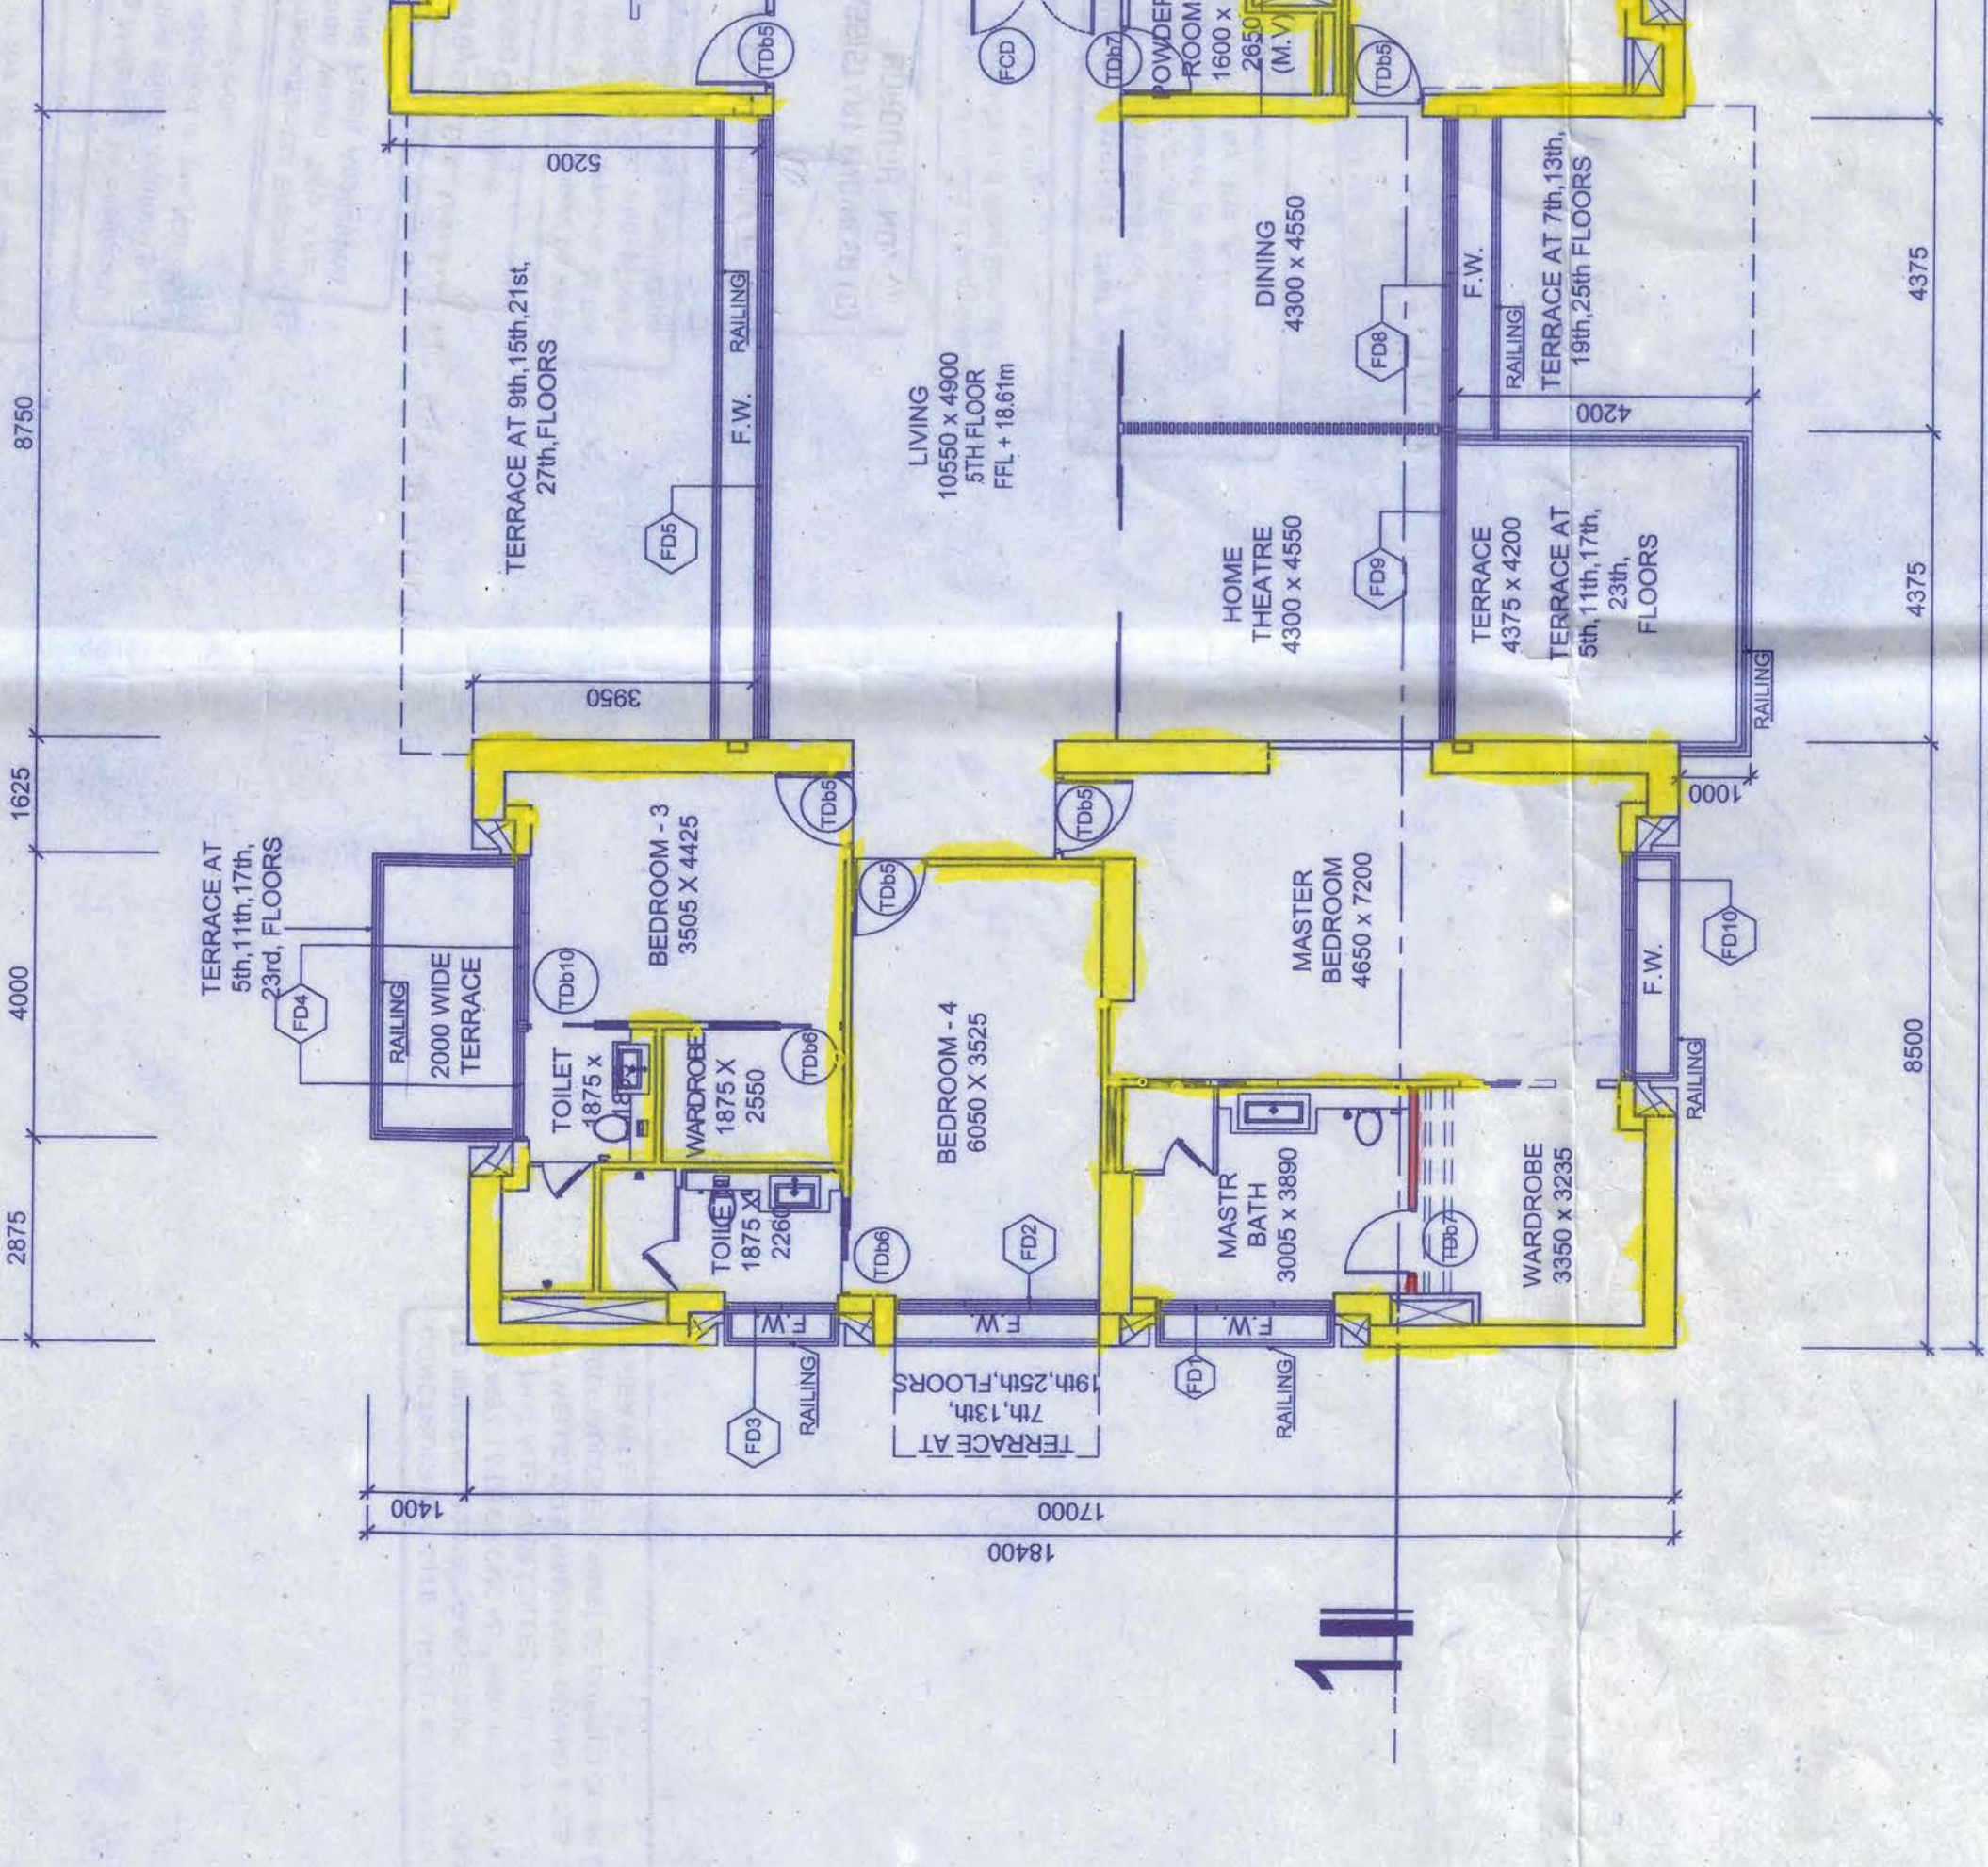

**LOWER DUPLEX VILLA**  
**WING A - TYPICAL FLOOR AT LEVEL- 05, 09, 11, 13, 23,**  
 scale 1:100

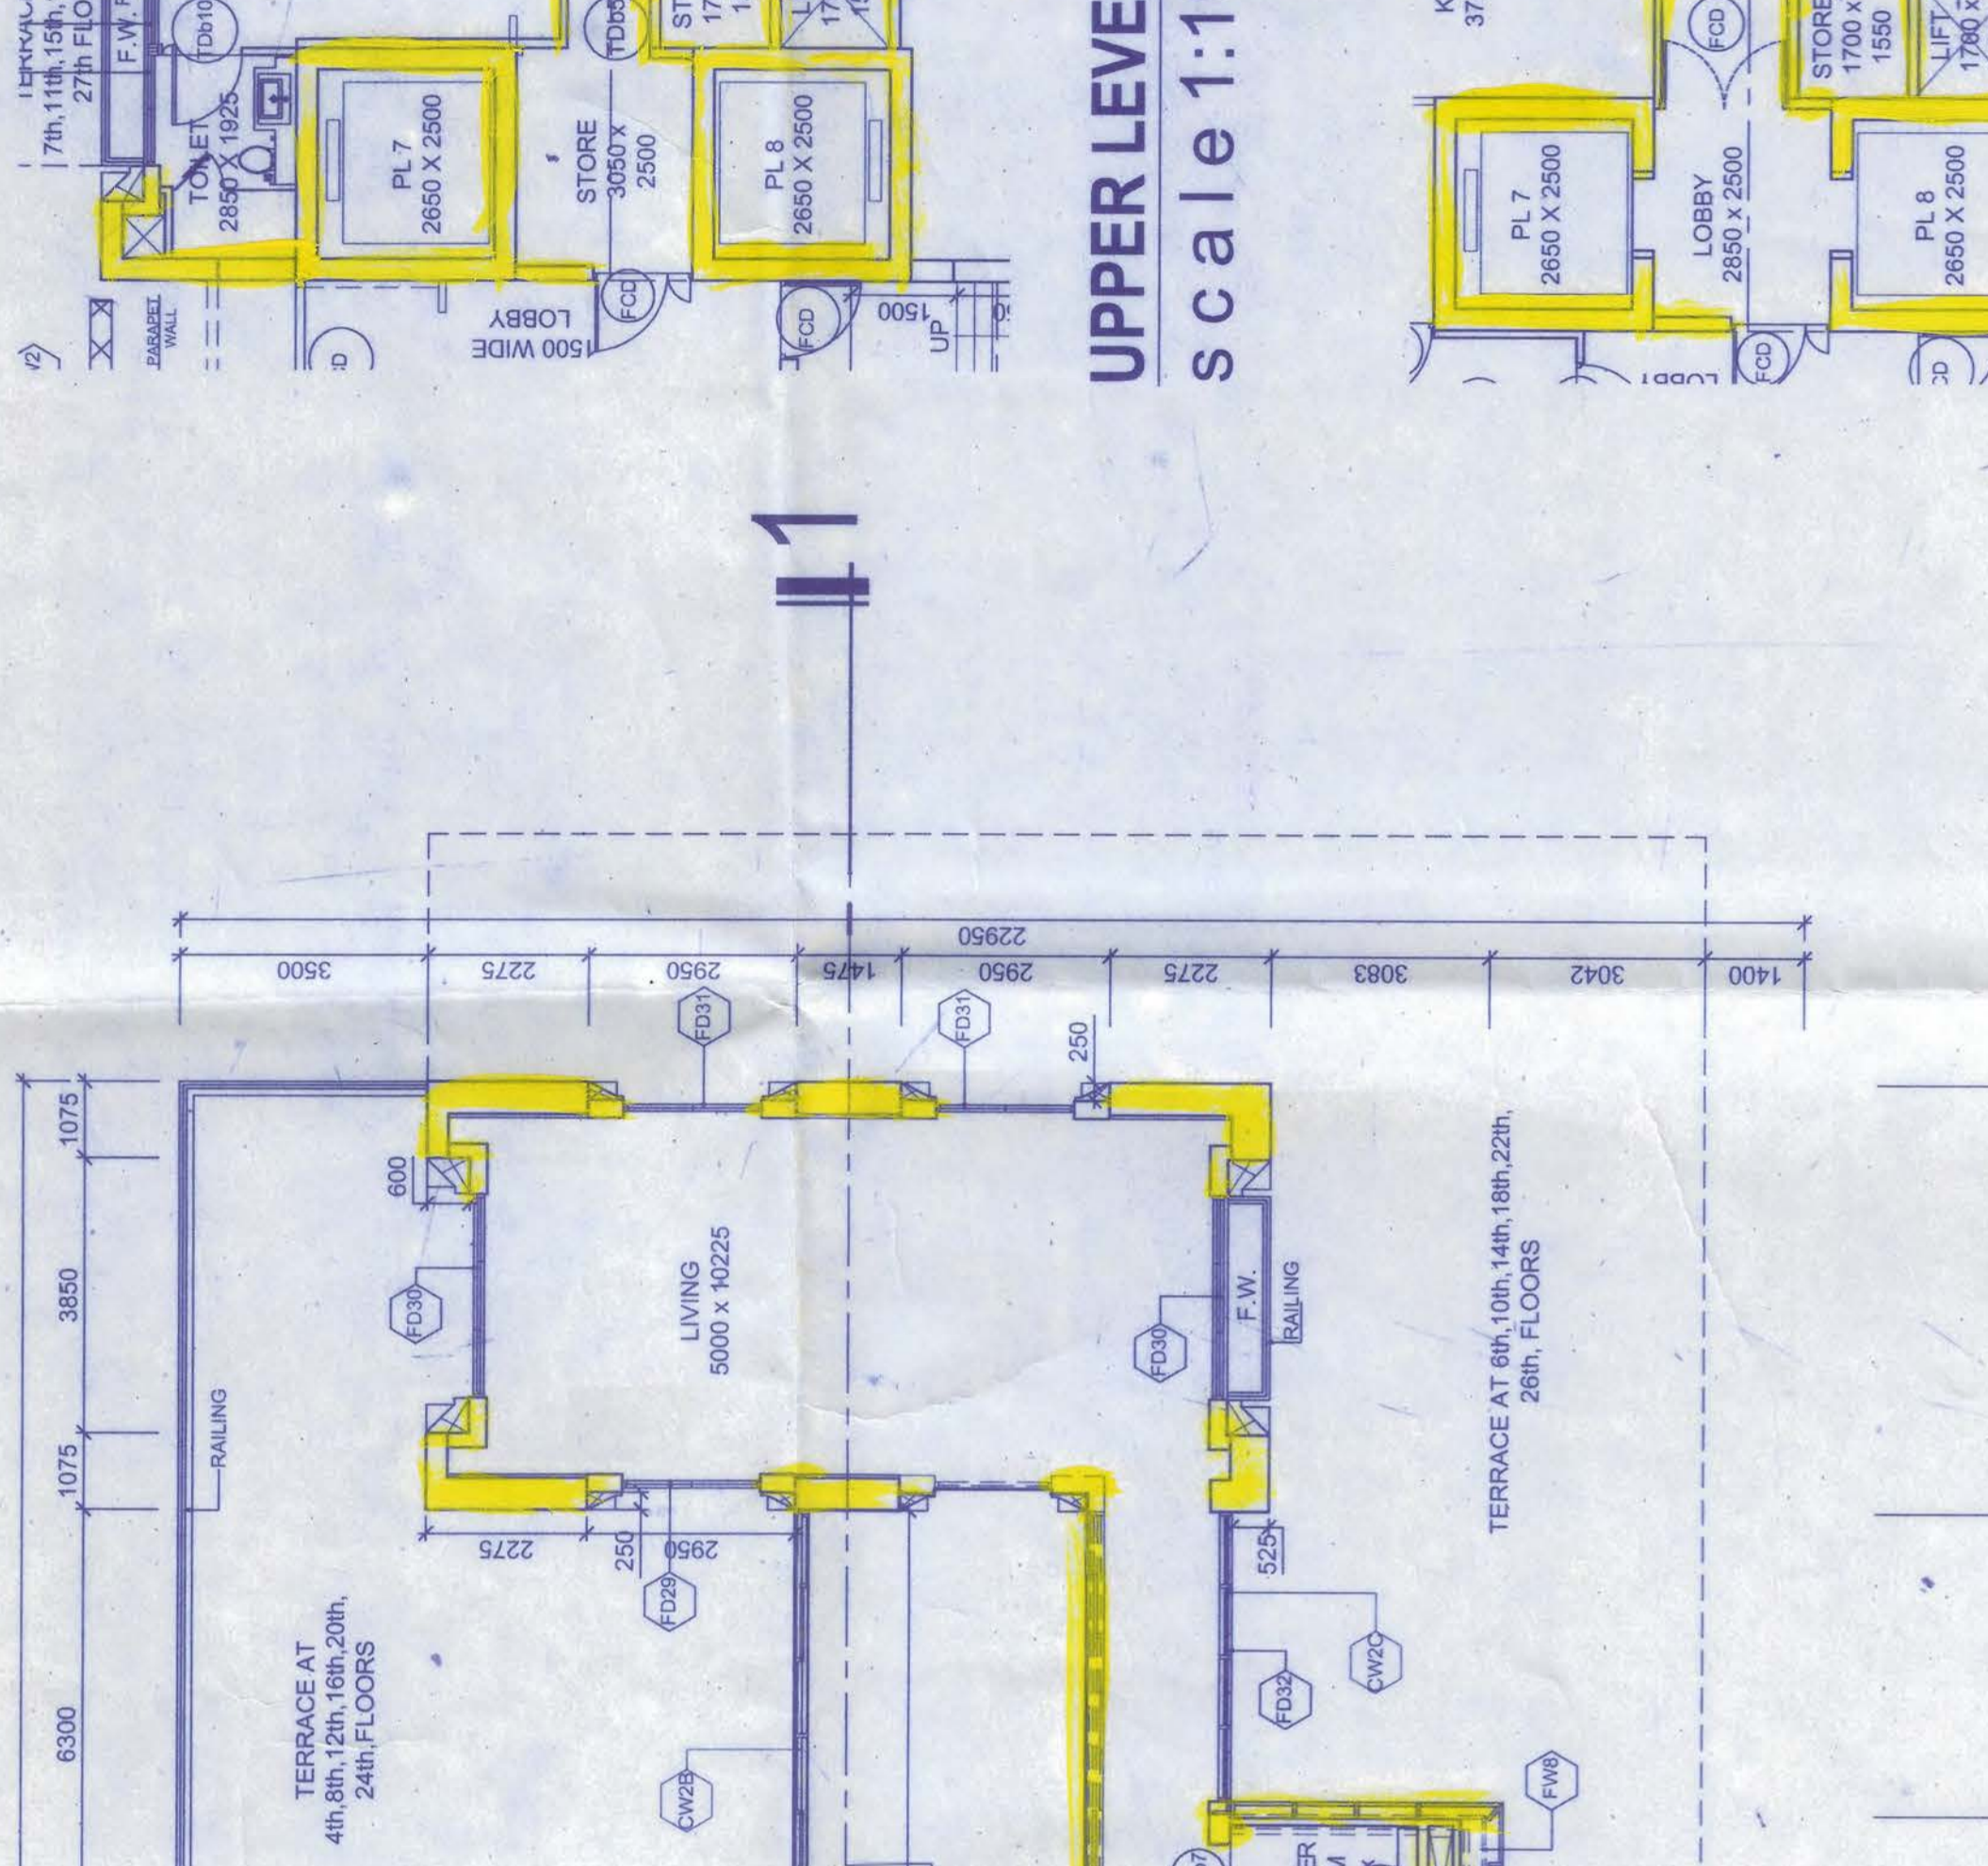

**UPPER LEVEL**  
 scale 1:100

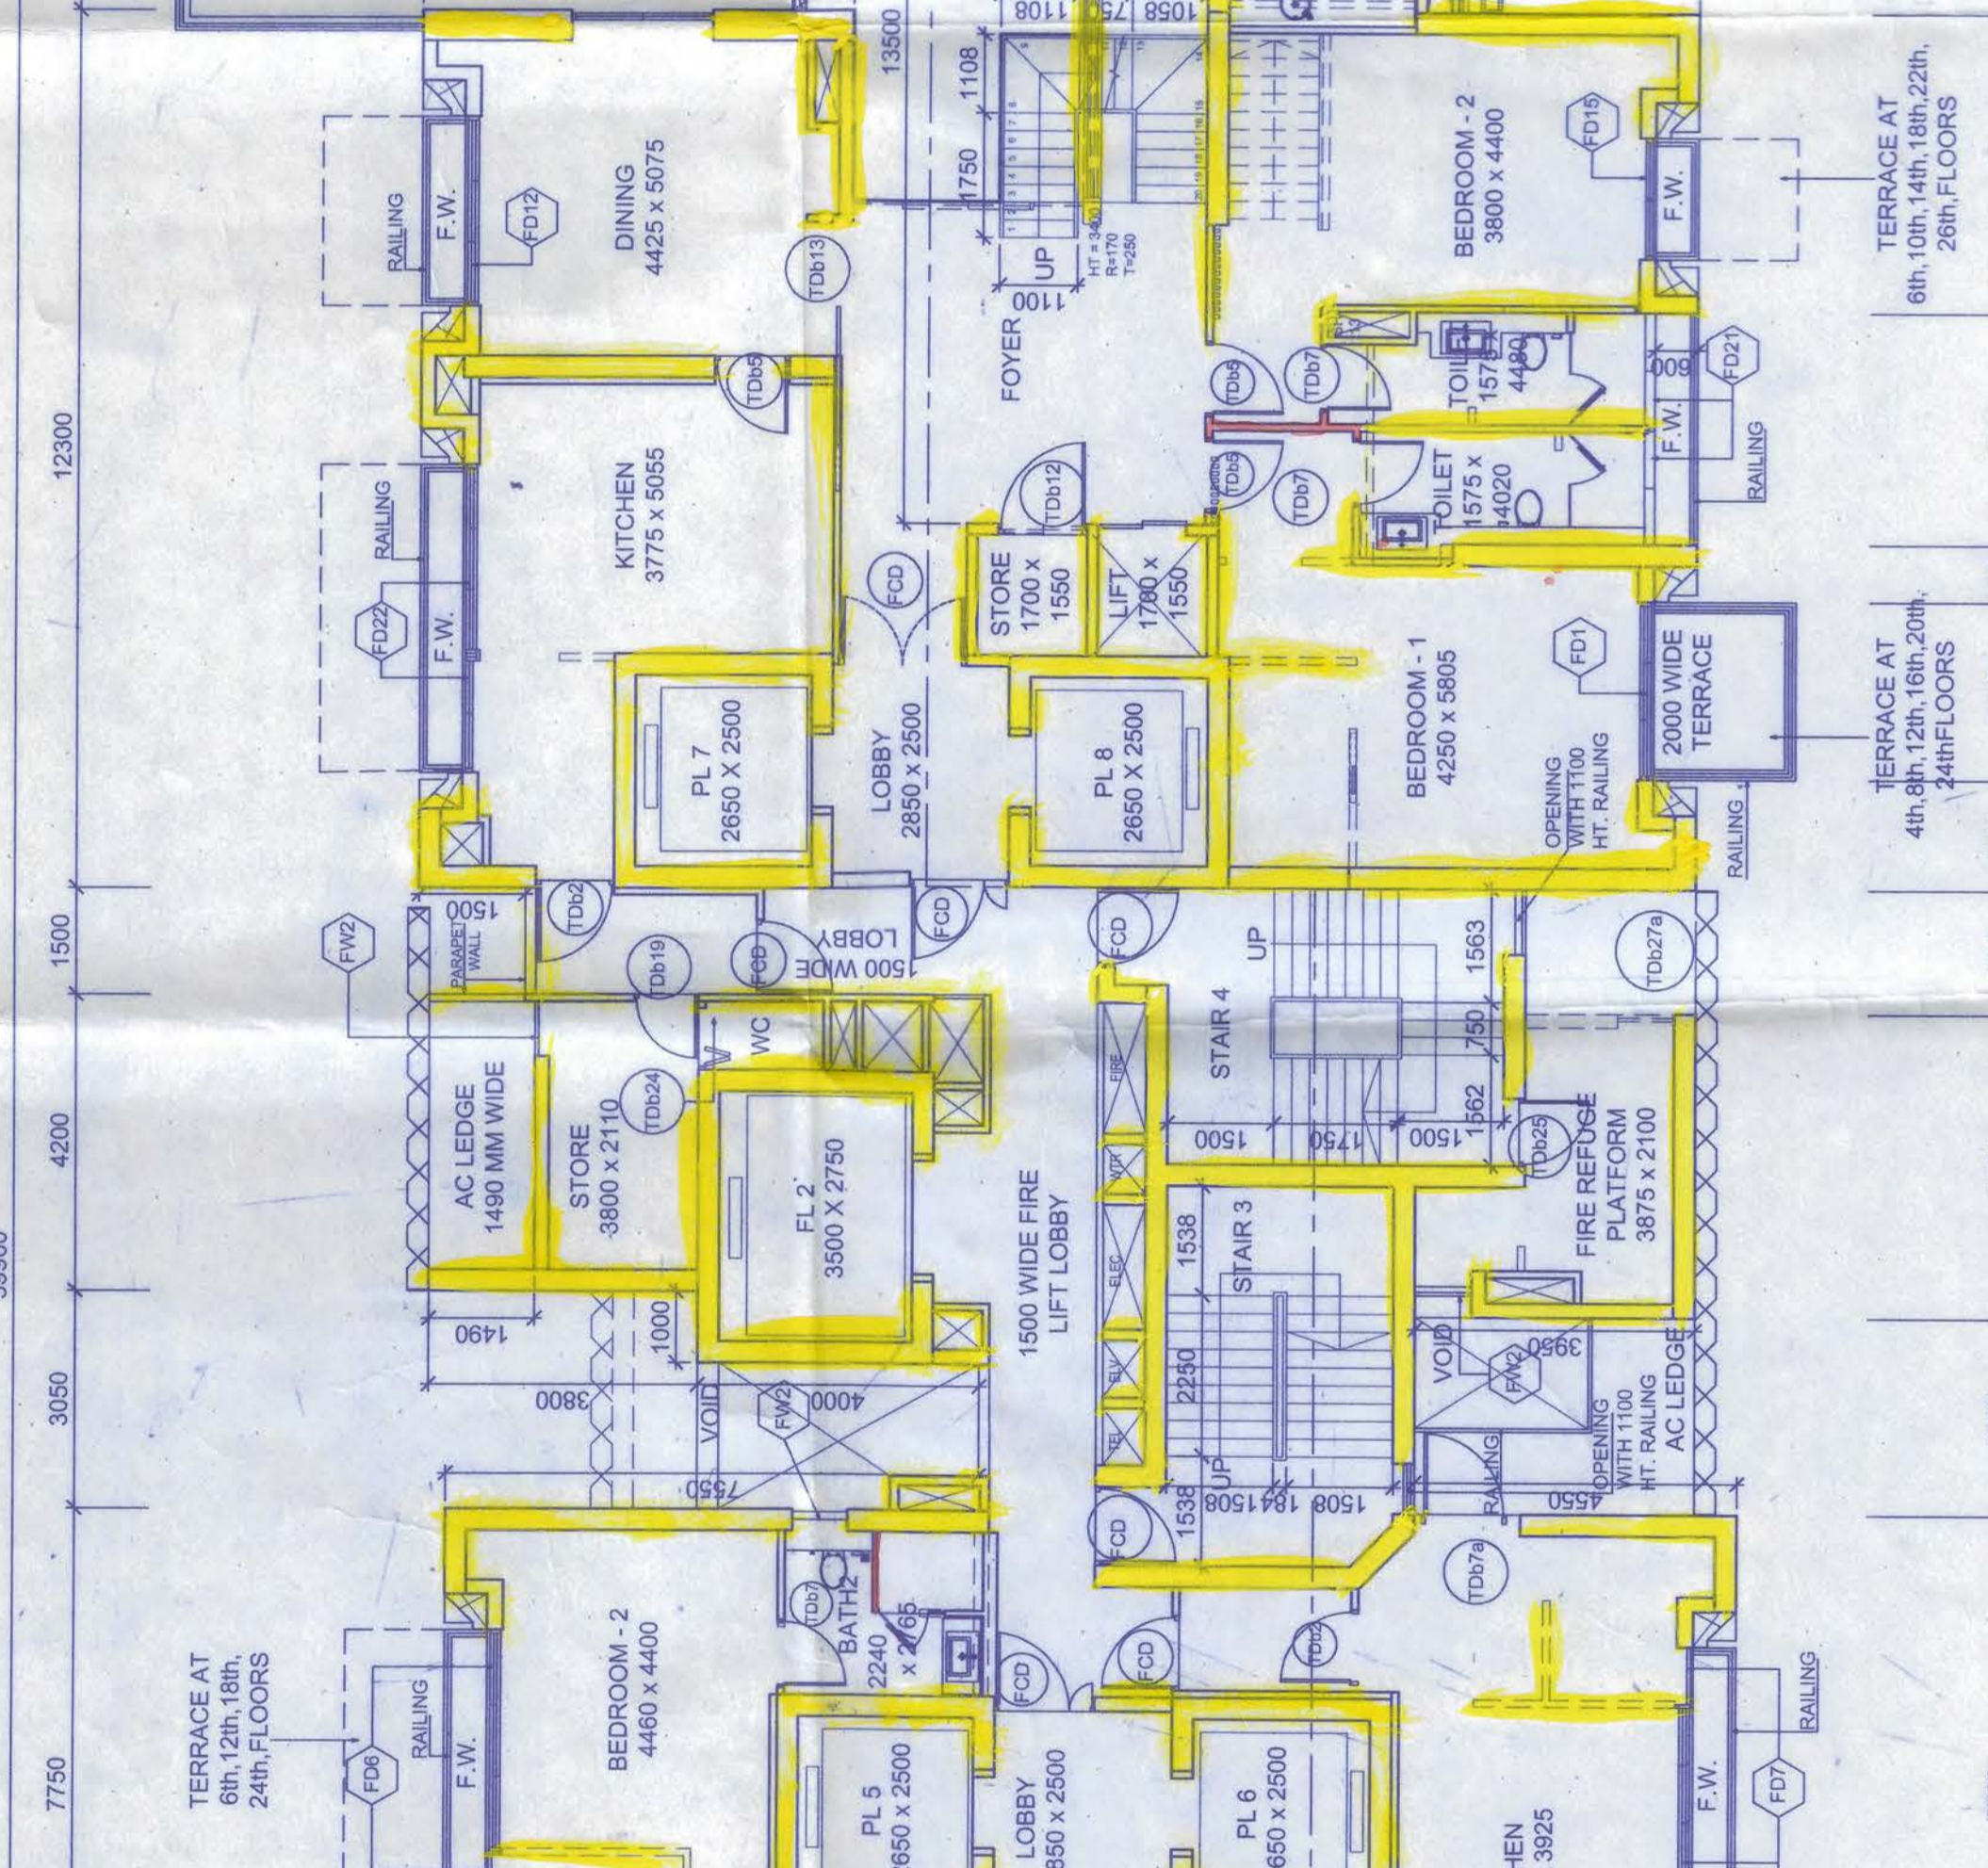

**LOWER LEVEL**  
 INTERNAL DUPLEX LIFT AND STORE POSITION (WING-A)  
 scale 1:100

**NOTES**

1. ALL LEVELS ARE IN METER ABOVE SEA LEVEL UNLESS OTHERWISE SPECIFIED.  
 2. THE DIMENSIONS GIVEN IN THIS PLAN ARE THE FINISH DIMENSIONS.  
 3. ALL DIMENSIONS ARE TO BE TAKEN AS SHOWN UNLESS OTHERWISE SPECIFIED.

**RESUBMISSION TO K.M.C.**

STAGE: MUNICIPAL  
 DIRECTION: Drawing No: **6 of 26**  
 Sheet Date: 27.03.19  
 Issue Date: 27.03.19  
 Project Code: F-26  
 S/N: 26  
 Block/Block: WING-A  
 Floor: WING-A  
 Drawing Title: TYPICAL FLOOR PLAN AT LEVEL- 4, 5, 9, 11, 13, 22 & 23



**FORUM PROJECTS PVT. LTD.**  
 100/IA EASTERN METROPOLITAN BYE PASSES, WARD NO. 66, BOROUGH - VII, KOLKATA - 700 048  
 033 2511 4550

**arc studio**  
 45, RIVER VALLEY ROAD, BHOWANIPUR, CHENNAI-600 028  
 044 2636 0038

**PHILIP JAYAKRISHNAN ARCHITECTS**  
 12, RIVER VALLEY ROAD, BHOWANIPUR, CHENNAI-600 028  
 044 2636 0038

**DR. S. Srinivasan**  
 M.E. (Structural)

**M.N. CONSULTANTS PVT. LTD.**  
 14, RIVER VALLEY ROAD, BHOWANIPUR, CHENNAI-600 028  
 044 2636 0038