


TYPICAL FLOOR PLAN
SCALE: 1/8" = 1'-0"

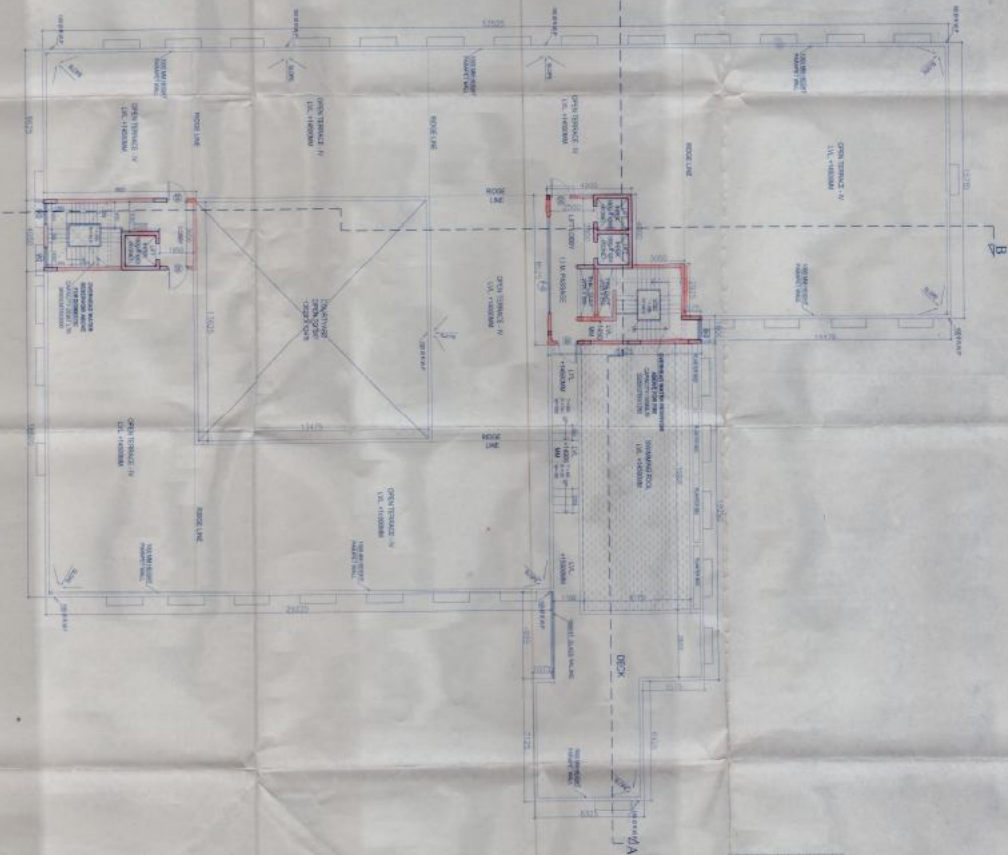

ROOF PLAN
SCALE: 1/100

- NOTES:
1. ALL DIMENSIONS UNLESS OTHERWISE SPECIFIED.
 2. SEE ARCHITECTURAL DRAWINGS FOR FINISHES AND MATERIALS.
 3. SEE MECHANICAL DRAWINGS FOR EQUIPMENT SCHEDULES AND CONNECTIONS.
 4. SEE ELECTRICAL DRAWINGS FOR PANEL SCHEDULES AND CONNECTIONS.
 5. SEE PLUMBING DRAWINGS FOR EQUIPMENT SCHEDULES AND CONNECTIONS.
 6. SEE STRUCTURAL DRAWINGS FOR MEMBER SCHEDULES AND CONNECTIONS.
 7. SEE FOUNDATION DRAWINGS FOR FOUNDATION SCHEDULES AND CONNECTIONS.
 8. SEE EXTERIOR FINISHES FOR EXTERIOR FINISHES AND CONNECTIONS.
 9. SEE INTERIOR FINISHES FOR INTERIOR FINISHES AND CONNECTIONS.
 10. SEE SCHEDULES FOR MEMBER SCHEDULES AND CONNECTIONS.

NO.	DATE	DESCRIPTION
1	10/15/10	ISSUED FOR PERMIT
2	11/10/10	REVISIONS
3	12/15/10	REVISIONS
4	01/15/11	REVISIONS
5	02/15/11	REVISIONS
6	03/15/11	REVISIONS
7	04/15/11	REVISIONS
8	05/15/11	REVISIONS
9	06/15/11	REVISIONS
10	07/15/11	REVISIONS
11	08/15/11	REVISIONS
12	09/15/11	REVISIONS
13	10/15/11	REVISIONS
14	11/15/11	REVISIONS
15	12/15/11	REVISIONS
16	01/15/12	REVISIONS
17	02/15/12	REVISIONS
18	03/15/12	REVISIONS
19	04/15/12	REVISIONS
20	05/15/12	REVISIONS
21	06/15/12	REVISIONS
22	07/15/12	REVISIONS
23	08/15/12	REVISIONS
24	09/15/12	REVISIONS
25	10/15/12	REVISIONS
26	11/15/12	REVISIONS
27	12/15/12	REVISIONS
28	01/15/13	REVISIONS
29	02/15/13	REVISIONS
30	03/15/13	REVISIONS
31	04/15/13	REVISIONS
32	05/15/13	REVISIONS
33	06/15/13	REVISIONS
34	07/15/13	REVISIONS
35	08/15/13	REVISIONS
36	09/15/13	REVISIONS
37	10/15/13	REVISIONS
38	11/15/13	REVISIONS
39	12/15/13	REVISIONS
40	01/15/14	REVISIONS
41	02/15/14	REVISIONS
42	03/15/14	REVISIONS
43	04/15/14	REVISIONS
44	05/15/14	REVISIONS
45	06/15/14	REVISIONS
46	07/15/14	REVISIONS
47	08/15/14	REVISIONS
48	09/15/14	REVISIONS
49	10/15/14	REVISIONS
50	11/15/14	REVISIONS
51	12/15/14	REVISIONS
52	01/15/15	REVISIONS
53	02/15/15	REVISIONS
54	03/15/15	REVISIONS
55	04/15/15	REVISIONS
56	05/15/15	REVISIONS
57	06/15/15	REVISIONS
58	07/15/15	REVISIONS
59	08/15/15	REVISIONS
60	09/15/15	REVISIONS
61	10/15/15	REVISIONS
62	11/15/15	REVISIONS
63	12/15/15	REVISIONS
64	01/15/16	REVISIONS
65	02/15/16	REVISIONS
66	03/15/16	REVISIONS
67	04/15/16	REVISIONS
68	05/15/16	REVISIONS
69	06/15/16	REVISIONS
70	07/15/16	REVISIONS
71	08/15/16	REVISIONS
72	09/15/16	REVISIONS
73	10/15/16	REVISIONS
74	11/15/16	REVISIONS
75	12/15/16	REVISIONS
76	01/15/17	REVISIONS
77	02/15/17	REVISIONS
78	03/15/17	REVISIONS
79	04/15/17	REVISIONS
80	05/15/17	REVISIONS
81	06/15/17	REVISIONS
82	07/15/17	REVISIONS
83	08/15/17	REVISIONS
84	09/15/17	REVISIONS
85	10/15/17	REVISIONS
86	11/15/17	REVISIONS
87	12/15/17	REVISIONS
88	01/15/18	REVISIONS
89	02/15/18	REVISIONS
90	03/15/18	REVISIONS
91	04/15/18	REVISIONS
92	05/15/18	REVISIONS
93	06/15/18	REVISIONS
94	07/15/18	REVISIONS
95	08/15/18	REVISIONS
96	09/15/18	REVISIONS
97	10/15/18	REVISIONS
98	11/15/18	REVISIONS
99	12/15/18	REVISIONS
100	01/15/19	REVISIONS

PROJECT: [Project Name]

CLIENT: [Client Name]

ARCHITECT: [Architect Name]

DATE: [Date]

SCALE: [Scale]

PROJECT NO.: [Project No.]

SHEET NO.: [Sheet No.]

TOTAL SHEETS: [Total Sheets]

DESIGNED BY: [Designer Name]

CHECKED BY: [Checker Name]

DATE: [Date]

SCALE: [Scale]

PROJECT NO.: [Project No.]

SHEET NO.: [Sheet No.]

TOTAL SHEETS: [Total Sheets]

APPROVED BY: [Approver Name]

DATE: [Date]

SCALE: [Scale]

PROJECT NO.: [Project No.]

SHEET NO.: [Sheet No.]

TOTAL SHEETS: [Total Sheets]

REVISIONS:

NO.	DATE	DESCRIPTION
1	10/15/10	ISSUED FOR PERMIT
2	11/10/10	REVISIONS
3	12/15/10	REVISIONS
4	01/15/11	REVISIONS
5	02/15/11	REVISIONS
6	03/15/11	REVISIONS
7	04/15/11	REVISIONS
8	05/15/11	REVISIONS
9	06/15/11	REVISIONS
10	07/15/11	REVISIONS
11	08/15/11	REVISIONS
12	09/15/11	REVISIONS
13	10/15/11	REVISIONS
14	11/15/11	REVISIONS
15	12/15/11	REVISIONS
16	01/15/12	REVISIONS
17	02/15/12	REVISIONS
18	03/15/12	REVISIONS
19	04/15/12	REVISIONS
20	05/15/12	REVISIONS
21	06/15/12	REVISIONS
22	07/15/12	REVISIONS
23	08/15/12	REVISIONS
24	09/15/12	REVISIONS
25	10/15/12	REVISIONS
26	11/15/12	REVISIONS
27	12/15/12	REVISIONS
28	01/15/13	REVISIONS
29	02/15/13	REVISIONS
30	03/15/13	REVISIONS
31	04/15/13	REVISIONS
32	05/15/13	REVISIONS
33	06/15/13	REVISIONS
34	07/15/13	REVISIONS
35	08/15/13	REVISIONS
36	09/15/13	REVISIONS
37	10/15/13	REVISIONS
38	11/15/13	REVISIONS
39	12/15/13	REVISIONS
40	01/15/14	REVISIONS
41	02/15/14	REVISIONS
42	03/15/14	REVISIONS
43	04/15/14	REVISIONS
44	05/15/14	REVISIONS
45	06/15/14	REVISIONS
46	07/15/14	REVISIONS
47	08/15/14	REVISIONS
48	09/15/14	REVISIONS
49	10/15/14	REVISIONS
50	11/15/14	REVISIONS
51	12/15/14	REVISIONS
52	01/15/15	REVISIONS
53	02/15/15	REVISIONS
54	03/15/15	REVISIONS
55	04/15/15	REVISIONS
56	05/15/15	REVISIONS
57	06/15/15	REVISIONS
58	07/15/15	REVISIONS
59	08/15/15	REVISIONS
60	09/15/15	REVISIONS
61	10/15/15	REVISIONS
62	11/15/15	REVISIONS
63	12/15/15	REVISIONS
64	01/15/16	REVISIONS
65	02/15/16	REVISIONS
66	03/15/16	REVISIONS
67	04/15/16	REVISIONS
68	05/15/16	REVISIONS
69	06/15/16	REVISIONS
70	07/15/16	REVISIONS
71	08/15/16	REVISIONS
72	09/15/16	REVISIONS
73	10/15/16	REVISIONS
74	11/15/16	REVISIONS
75	12/15/16	REVISIONS
76	01/15/17	REVISIONS
77	02/15/17	REVISIONS
78	03/15/17	REVISIONS
79	04/15/17	REVISIONS
80	05/15/17	REVISIONS
81	06/15/17	REVISIONS
82	07/15/17	REVISIONS
83	08/15/17	REVISIONS
84	09/15/17	REVISIONS
85	10/15/17	REVISIONS
86	11/15/17	REVISIONS
87	12/15/17	REVISIONS
88	01/15/18	REVISIONS
89	02/15/18	REVISIONS
90	03/15/18	REVISIONS
91	04/15/18	REVISIONS
92	05/15/18	REVISIONS
93	06/15/18	REVISIONS
94	07/15/18	REVISIONS
95	08/15/18	REVISIONS
96	09/15/18	REVISIONS
97	10/15/18	REVISIONS
98	11/15/18	REVISIONS
99	12/15/18	REVISIONS
100	01/15/19	REVISIONS

SCHEDULE OF ROOMS & FINISHES

NO.	ROOM	FINISHES
01	OFFICE	...
02	CORRIDOR	...
03	STAIR	...
04	RESTROOM	...
05	MEETING ROOM	...
06	CONFERENCE ROOM	...
07	RECEPTION	...
08	WAITING AREA	...
09	LOBBY	...
10	MECHANICAL ROOM	...
11	ELECTRICAL ROOM	...
12	PLUMBING ROOM	...
13	STORAGE	...
14	UTILITY	...
15	ROOF	...
16	FOUNDATION	...
17	EXTERIOR	...
18	INTERIOR	...
19	MECHANICAL	...
20	ELECTRICAL	...
21	PLUMBING	...
22	STRUCTURAL	...
23	FOUNDATION	...
24	EXTERIOR	...
25	INTERIOR	...
26	MECHANICAL	...
27	ELECTRICAL	...
28	PLUMBING	...
29	STRUCTURAL	...
30	FOUNDATION	...
31	EXTERIOR	...
32	INTERIOR	...
33	MECHANICAL	...
34	ELECTRICAL	...
35	PLUMBING	...
36	STRUCTURAL	...
37	FOUNDATION	...
38	EXTERIOR	...
39	INTERIOR	...
40	MECHANICAL	...
41	ELECTRICAL	...
42	PLUMBING	...
43	STRUCTURAL	...
44	FOUNDATION	...
45	EXTERIOR	...
46	INTERIOR	...
47	MECHANICAL	...
48	ELECTRICAL	...
49	PLUMBING	...
50	STRUCTURAL	...
51	FOUNDATION	...
52	EXTERIOR	...
53	INTERIOR	...
54	MECHANICAL	...
55	ELECTRICAL	...
56	PLUMBING	...
57	STRUCTURAL	...
58	FOUNDATION	...
59	EXTERIOR	...
60	INTERIOR	...
61	MECHANICAL	...
62	ELECTRICAL	...
63	PLUMBING	...
64	STRUCTURAL	...
65	FOUNDATION	...
66	EXTERIOR	...
67	INTERIOR	...
68	MECHANICAL	...
69	ELECTRICAL	...
70	PLUMBING	...
71	STRUCTURAL	...
72	FOUNDATION	...
73	EXTERIOR	...
74	INTERIOR	...
75	MECHANICAL	...
76	ELECTRICAL	...
77	PLUMBING	...
78	STRUCTURAL	...
79	FOUNDATION	...
80	EXTERIOR	...
81	INTERIOR	...
82	MECHANICAL	...
83	ELECTRICAL	...
84	PLUMBING	...
85	STRUCTURAL	...
86	FOUNDATION	...
87	EXTERIOR	...
88	INTERIOR	...
89	MECHANICAL	...
90	ELECTRICAL	...
91	PLUMBING	...
92	STRUCTURAL	...
93	FOUNDATION	...
94	EXTERIOR	...
95	INTERIOR	...
96	MECHANICAL	...
97	ELECTRICAL	...
98	PLUMBING	...
99	STRUCTURAL	...
100	FOUNDATION	...

