



19TH FLOOR PLAN  
SCALE 1:50

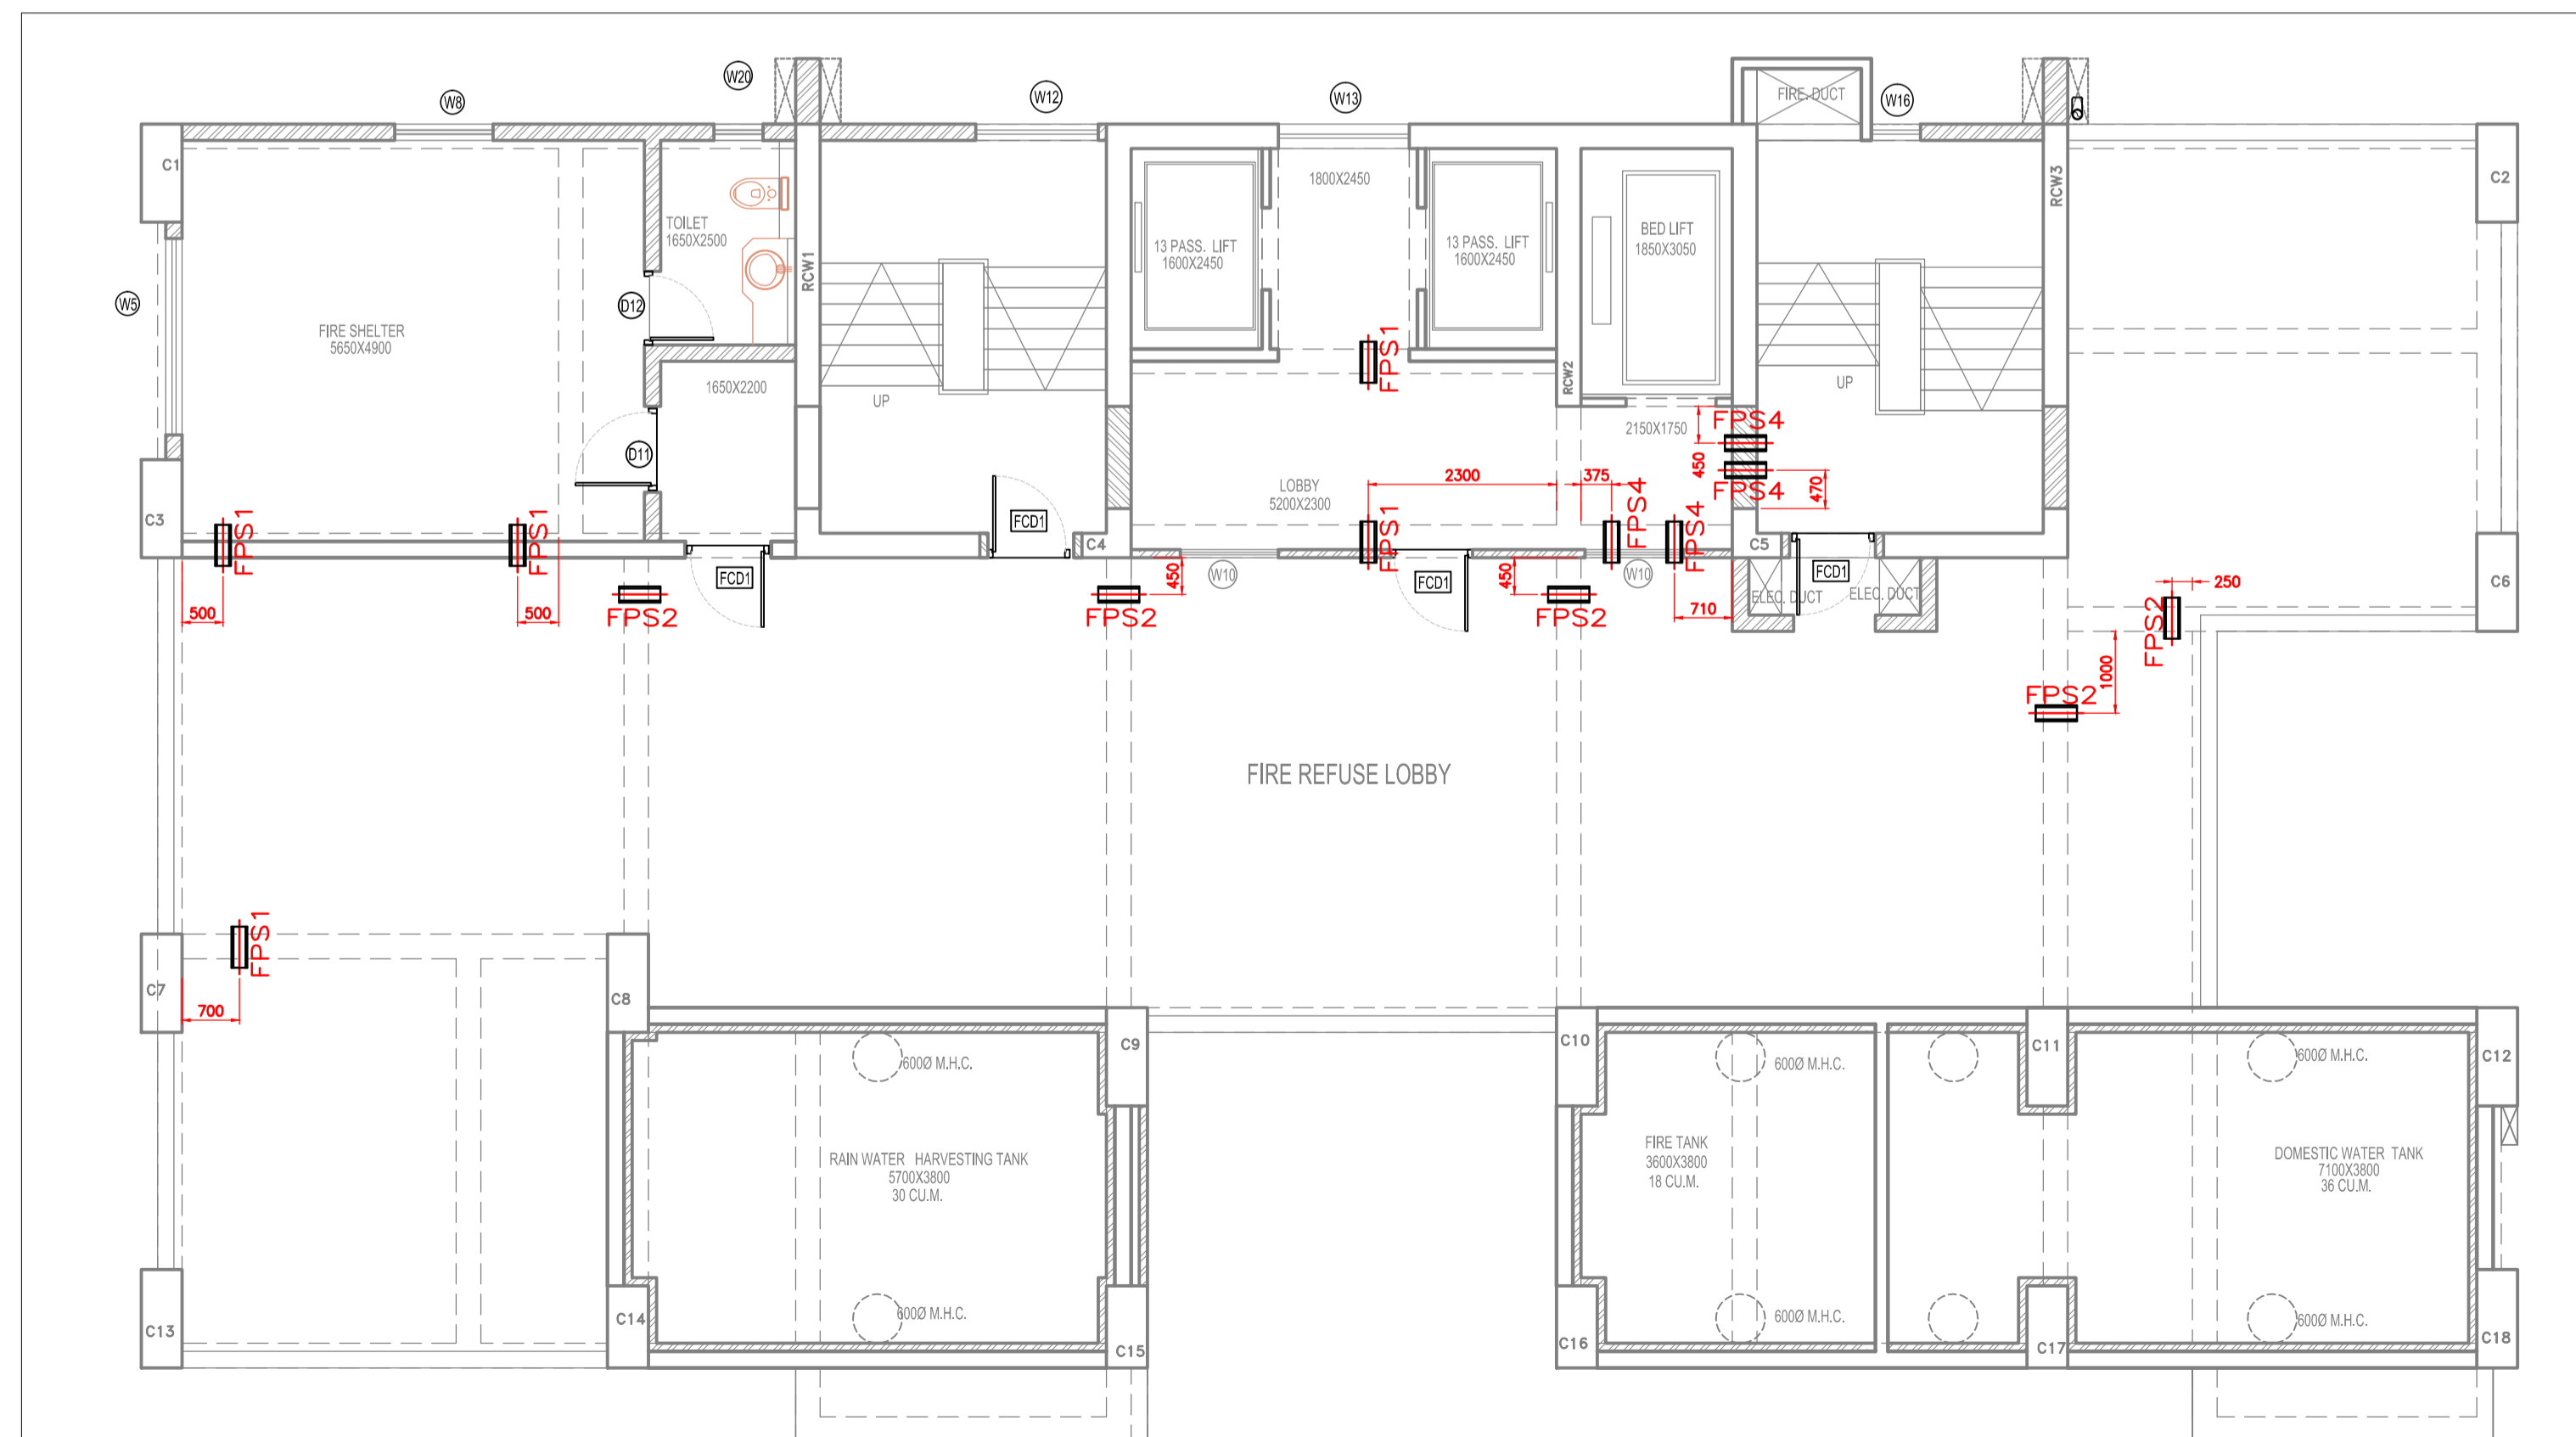

PIPE SLEEVES FOR FIRE PIPE SCALE 1:75

NOTES:

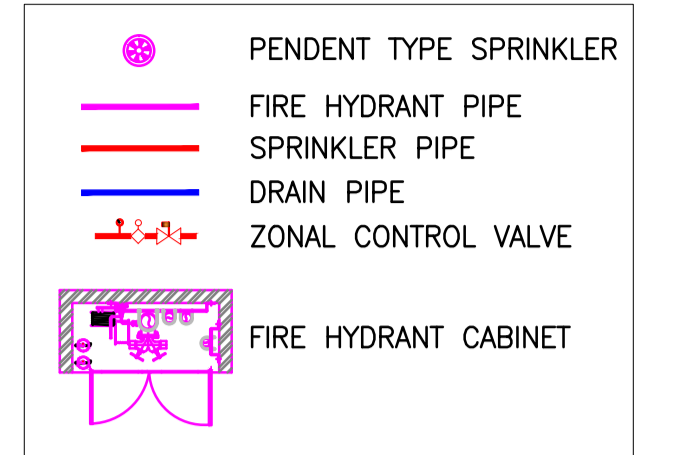

REV	DESCRIPTION	DATE	DWN.	CHKD.	APPD.	SIGN
04	REVISED AS PER LAYOUT	09.06.17	GPK	PPD	MVB	
03	REVISED AS PER LAYOUT	24.04.17	GPK	PPD	MVB	
02	REVISED AS PER LAYOUT	06.12.16	GPK	PPD	MVB	
01	REVISED AS PER LAYOUT	18.11.16	GPK	PPD	MVB	
00	ISSUED FOR CONSTRUCTION	14.10.16	GPK	PPD	MVB	

RECEIVER'S SIGN/STAMP

PROJECT:

PURPOSE OF RELEASE:

ISSUED FOR CONSTRUCTION

KEY PLAN

CLIENT:

**ARKK consulting**  
Design Engineering Project Management  
4, Sumer Kendra, Pandurang Budhkar Marg,  
Worli, MUMBAI - 400 018.  
PHONE: (022) 4025 0100 FAX: (022) 2496 0489  
E-mail: rnj@arkkconsulting.com

DRAWING TITLE:

17 D  
FIRE FIGHTING LAYOUT  
19TH FLOOR

NAME	DATE	SIGN
DRAWN BY UMESH	14/10/2016	
CHECKED BY PRADUMNYA	14/10/2016	
APPROVED BY MILIND	14/10/2016	
DRAWING No. 17D/FF-11	SCALE NTS	REV 02