




19TH FLOOR PLAN - WATER SUPPLY @ CLG. LVL
SCALE 1:75

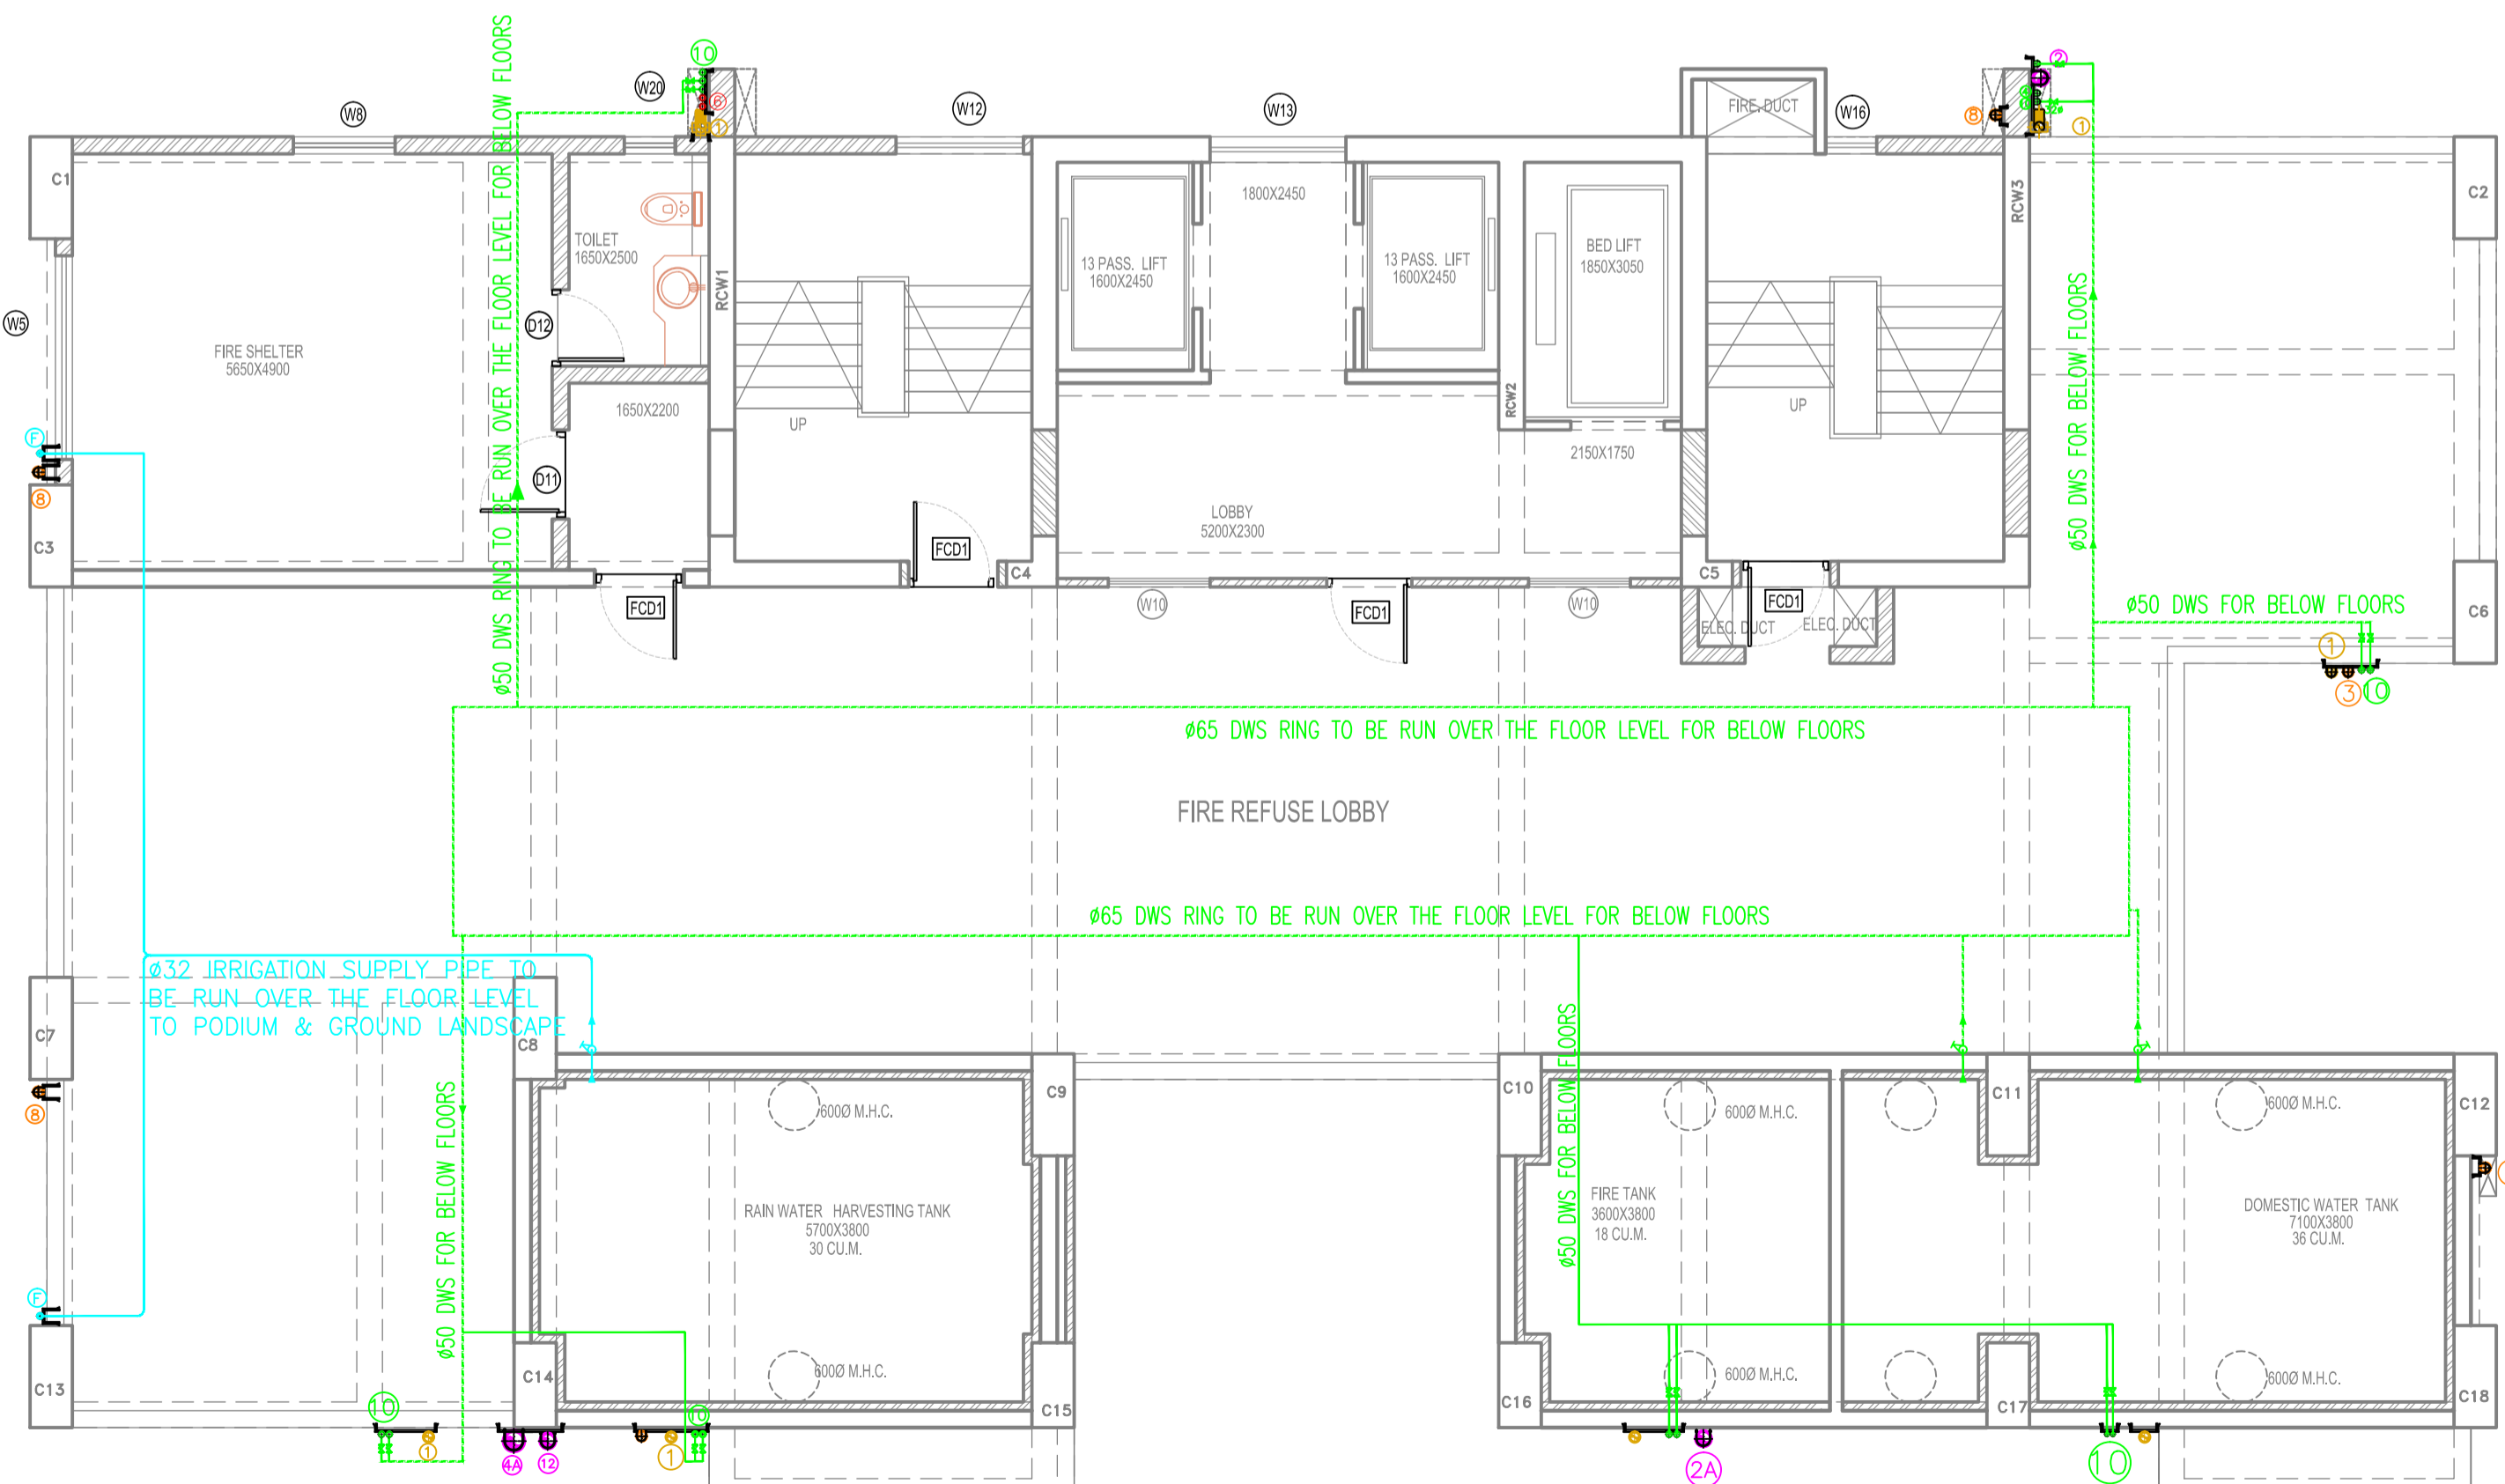


19TH FLOOR PLAN - WATER SUPPLY @ FLOOR LVL
SCALE 1:75

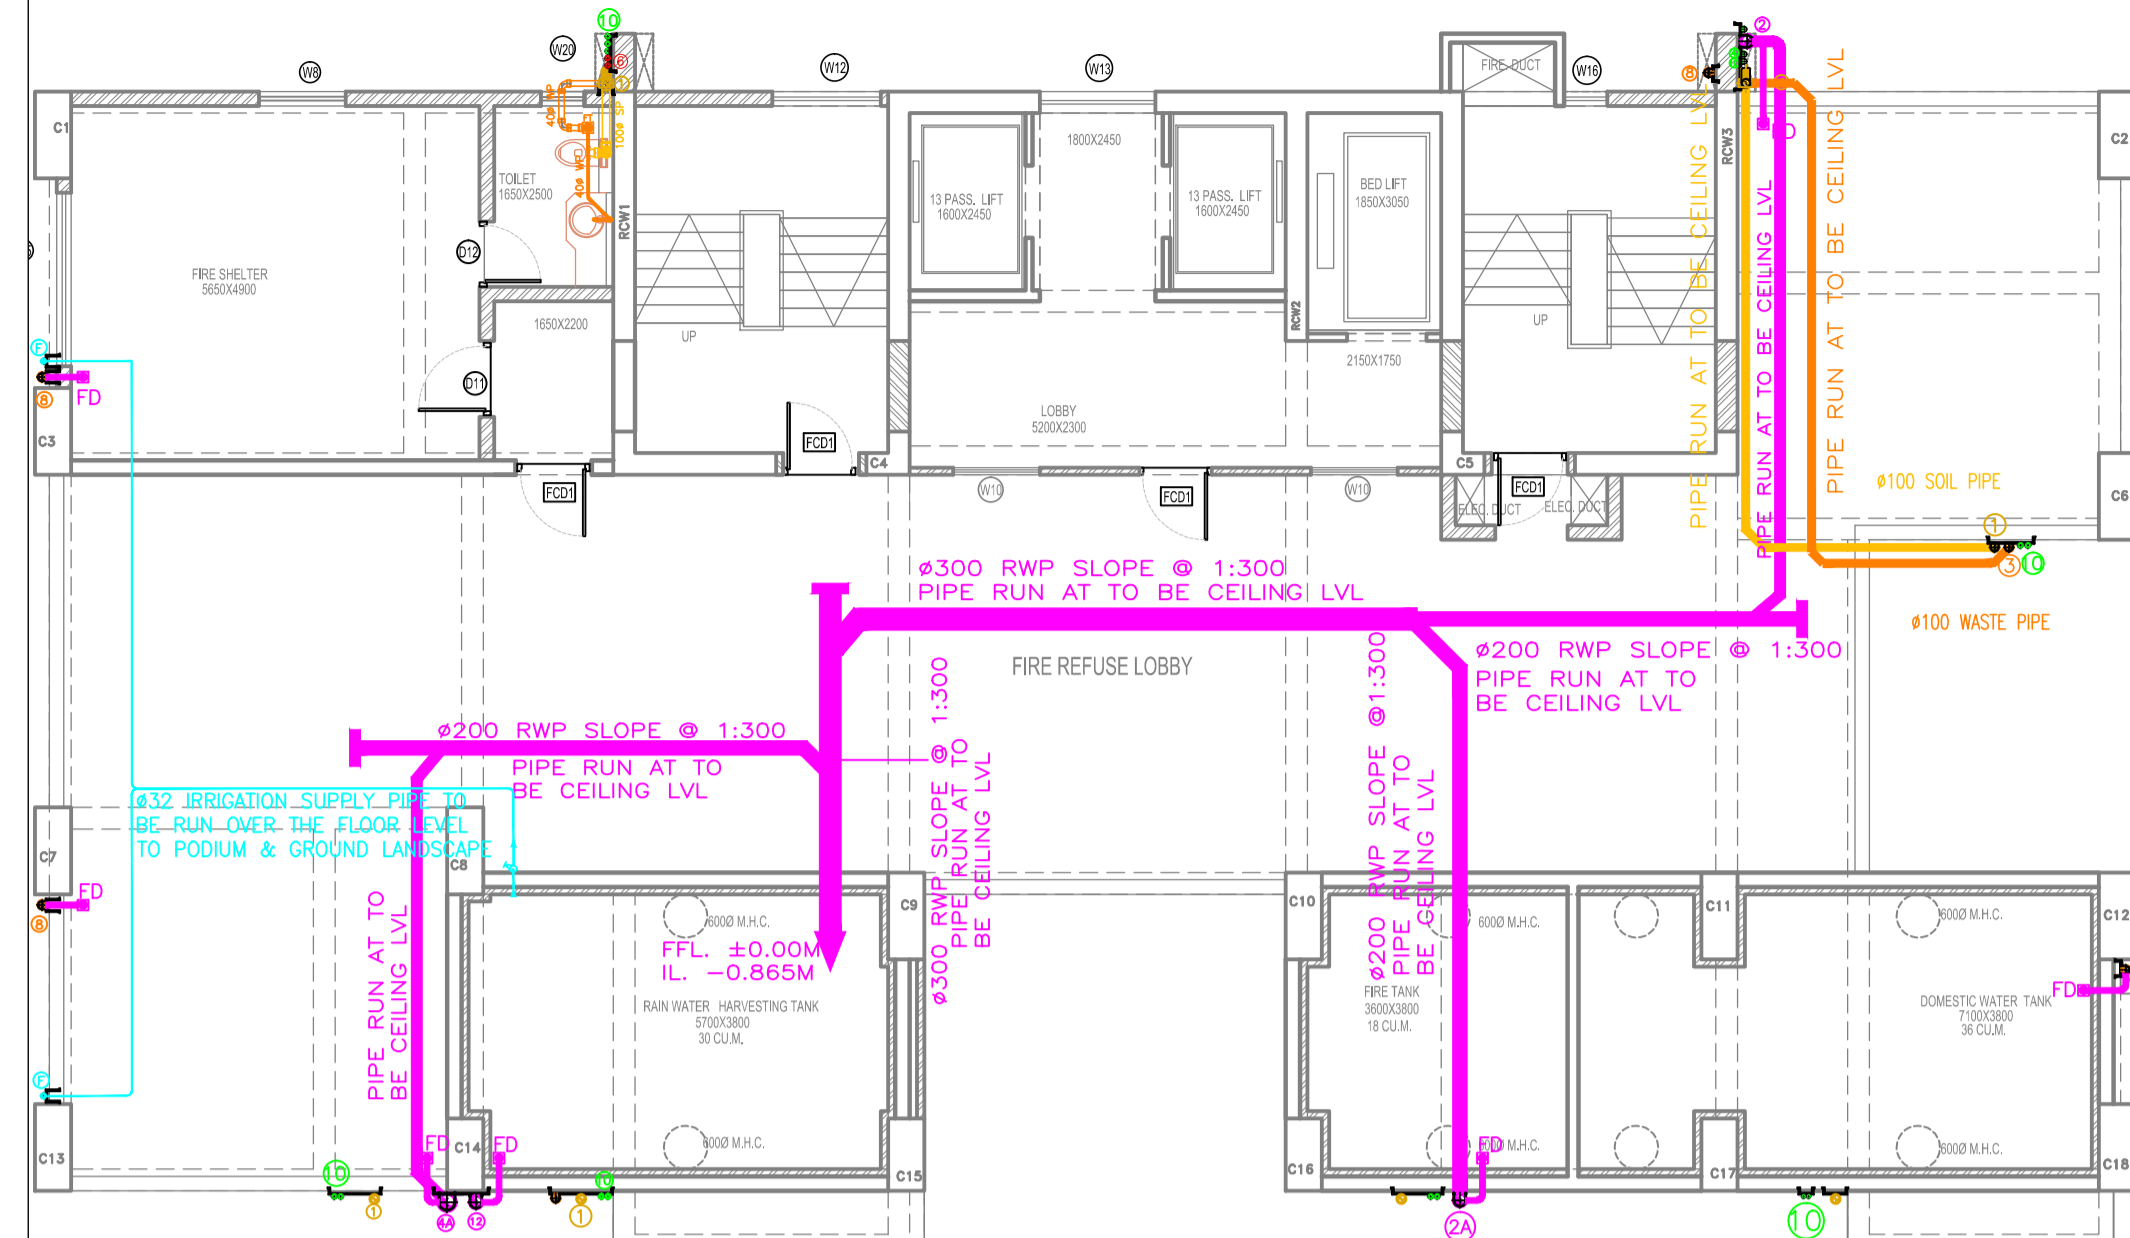


19TH FLOOR PLAN - DRAINAGE
SCALE 1:75

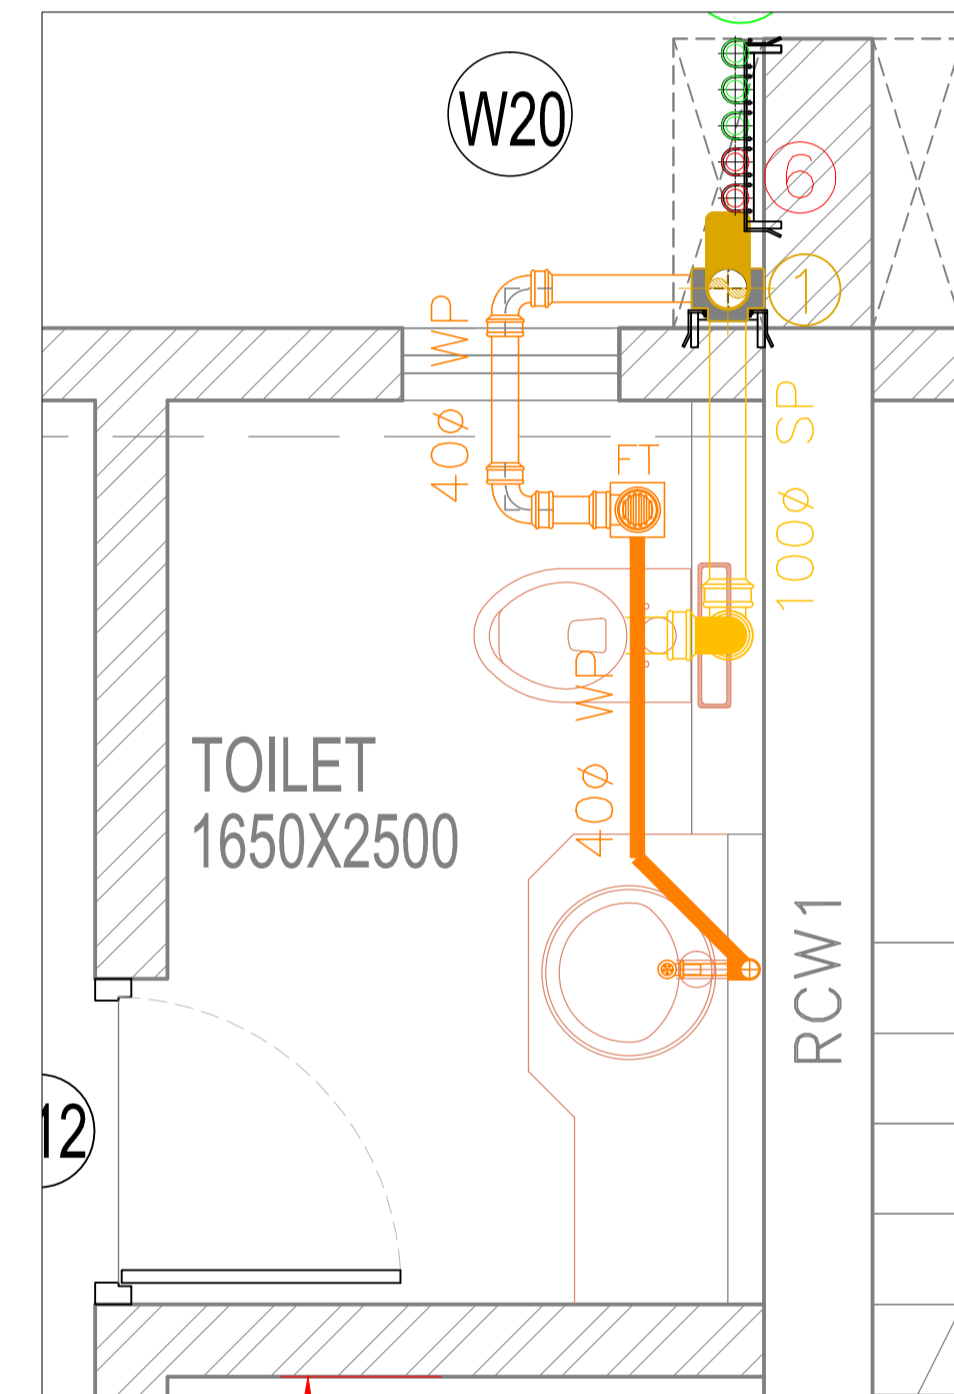

19TH FLOOR PLAN - TOILET DRAINAGE
SCALE 1:20

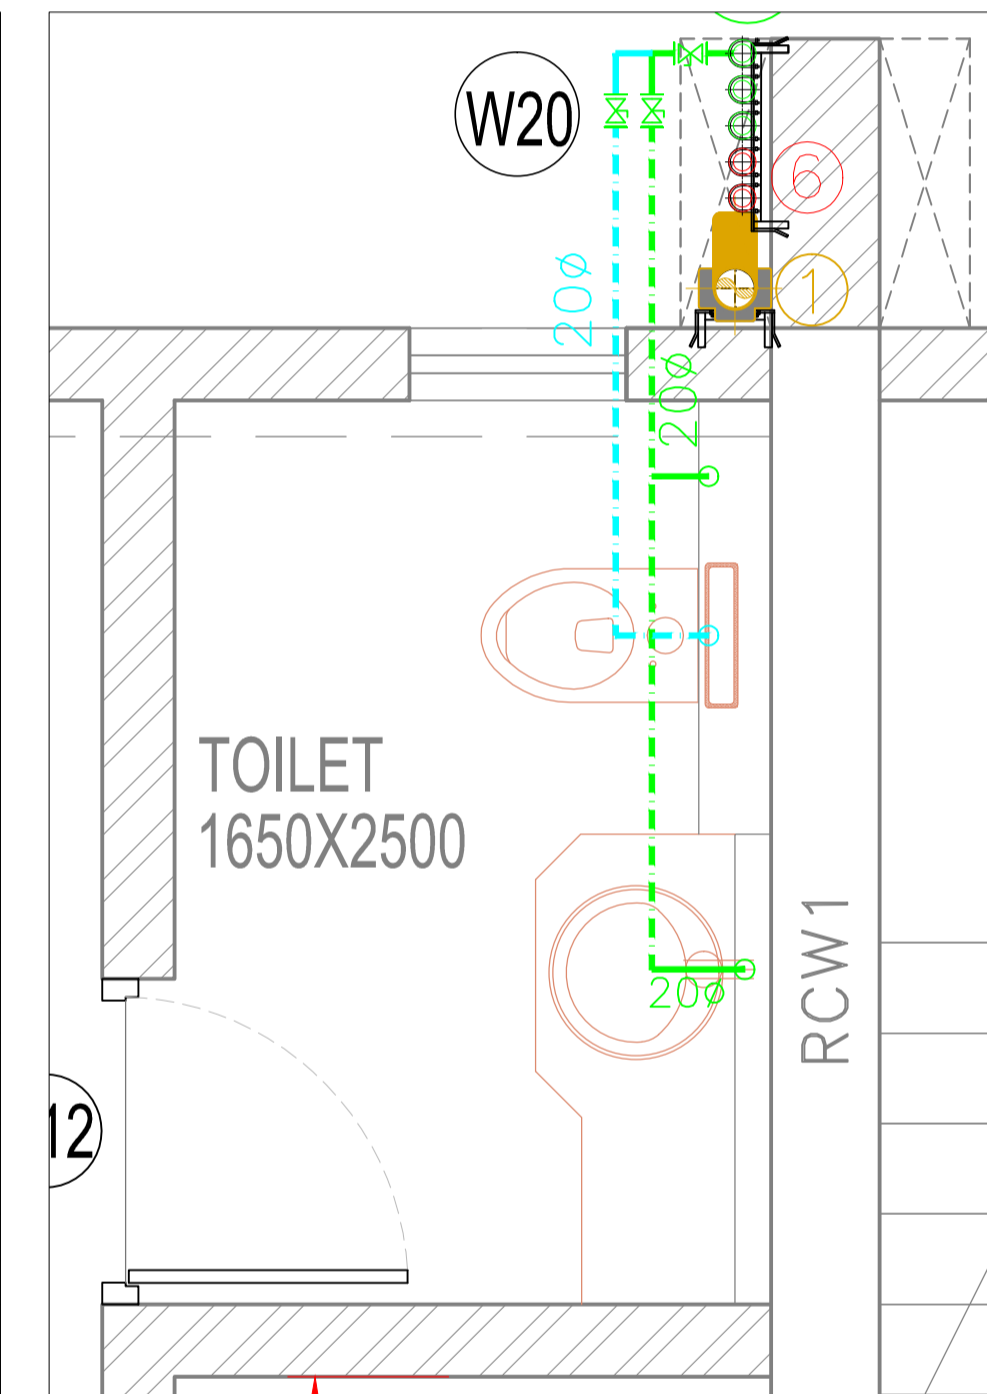

19TH FLOOR PLAN - TOILET WATER SUPPLY
SCALE 1:20

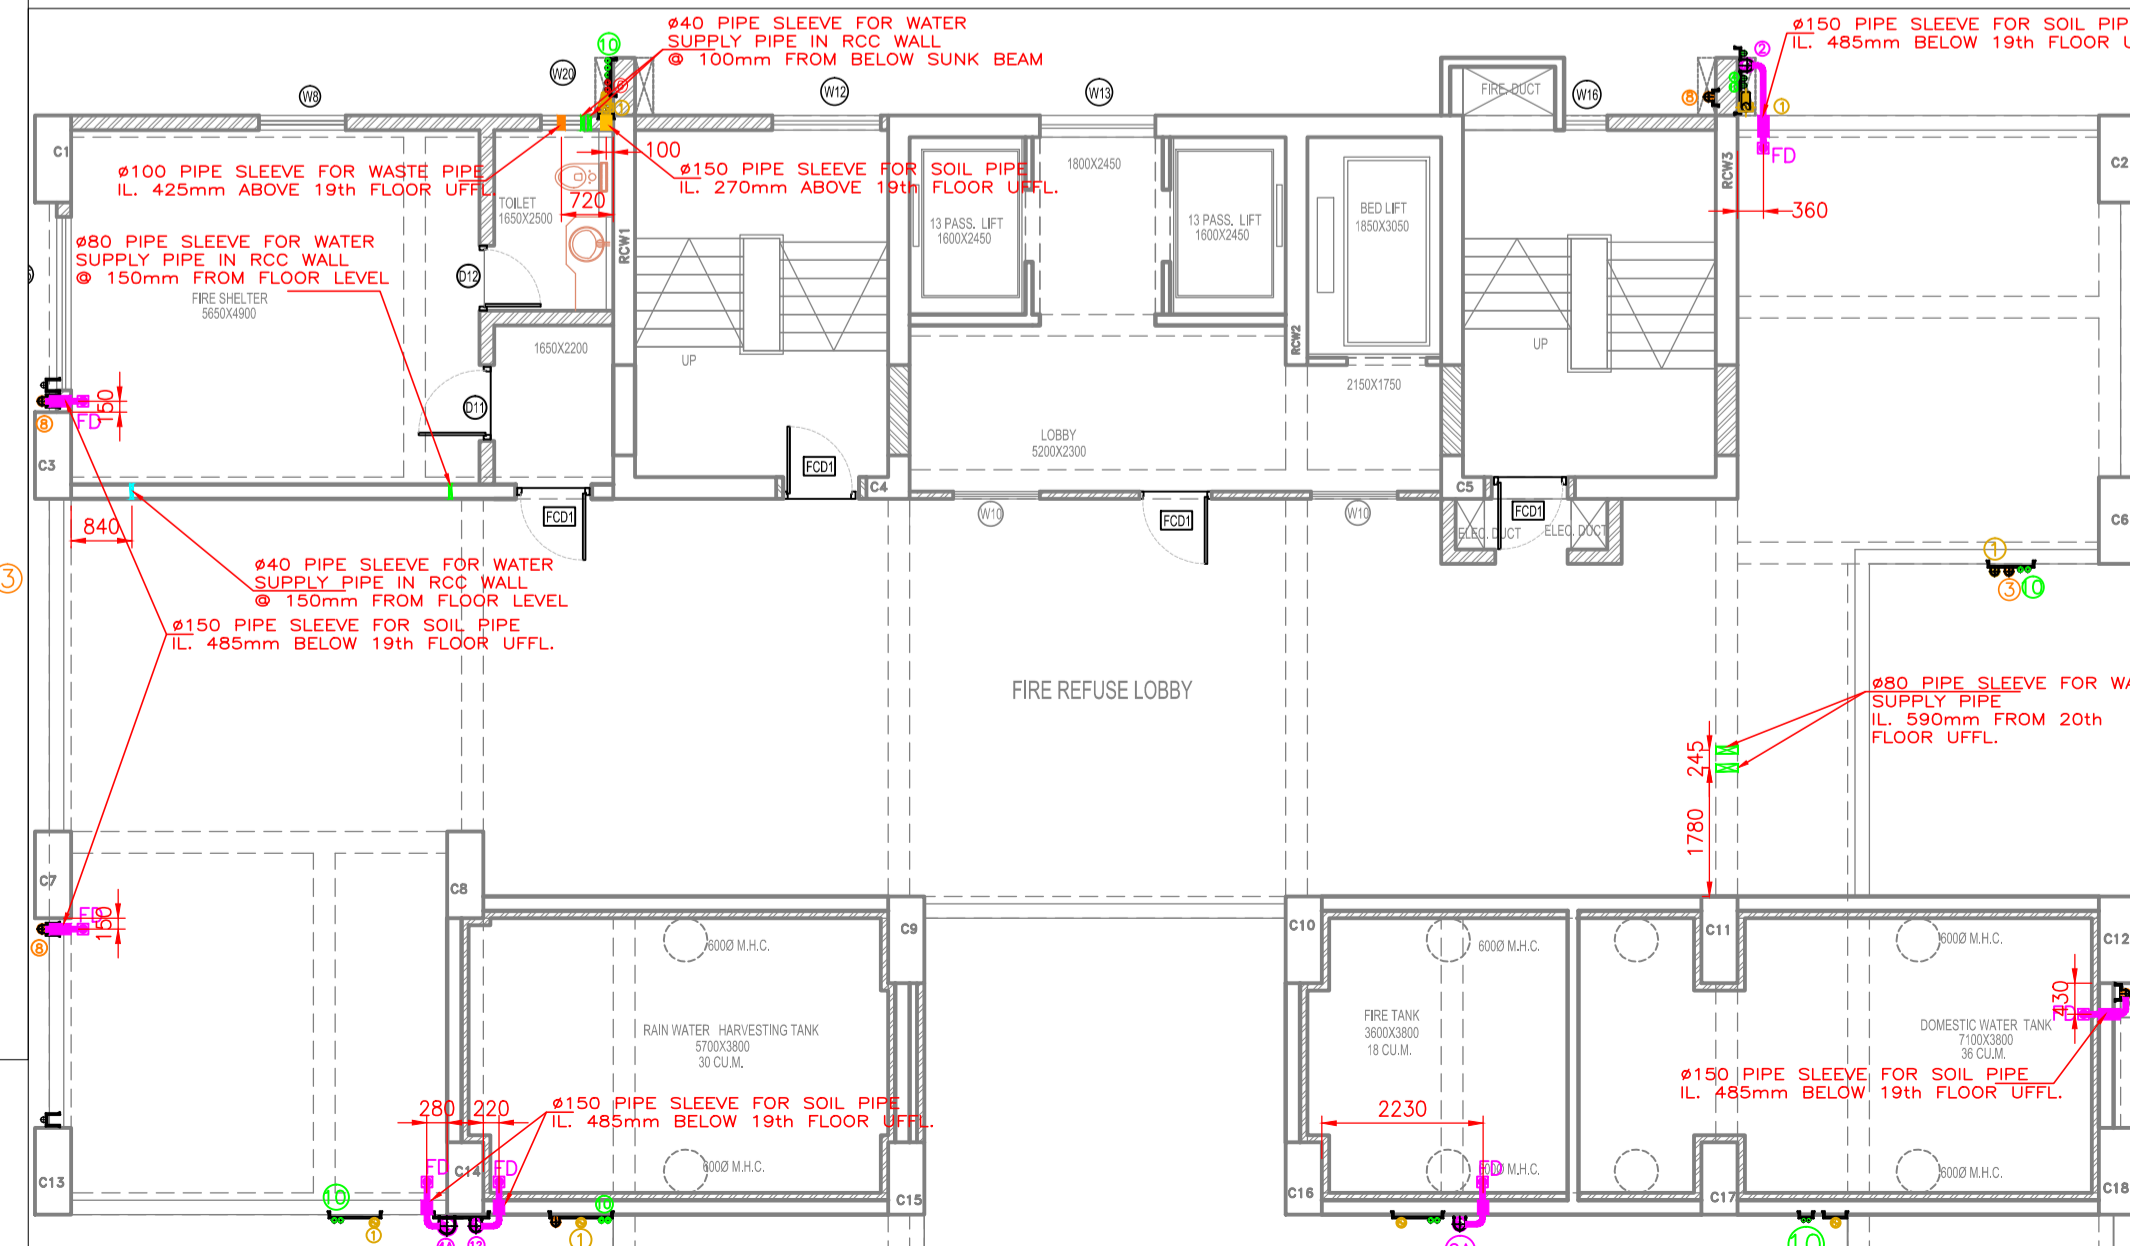

- NOTES:
- 150Ø SEWER PIPE T/B
 - 150Ø RAIN WATER PIPE T/B
 - 100Ø BALCONY DRAIN PIPE T/B
 - DOMESTIC WATER SUPPLY TRANSFER PIPE F/B
 - DOMESTIC WATER SUPPLY PIPE T/B
 - HOT WATER PIPE T/B
 - 100Ø SWIMMING POOL DRAIN PIPE T/B
 - 100Ø LOWN DRAIN PIPE T/B
- DOMESTIC WATER SUPPLY PIPE
 - FLUSHING WATER SUPPLY PIPE
 - HOT WATER SUPPLY PIPE
 - SOIL PIPE
 - WASTE PIPE
 - RAIN WATER PIPE
 - FT - FLOOR TRAP
 - FD - FLOOR DRAIN
 - TD - TERRACE DRAIN
 - FD - FLOOR DRAIN
 - CD - CORNER DRAIN
 - GEYSER

04	REVISED AS PER LAYOUT	09.06.17	GPK	PPD	MVB	
03	REVISED AS PER LAYOUT	24.04.17	GPK	PPD	MVB	
02	REVISED AS PER LAYOUT	06.12.16	GPK	PPD	MVB	
01	REVISED AS PER LAYOUT	18.11.16	GPK	PPD	MVB	
00	ISSUED FOR CONSTRUCTION	14.10.16	GPK	PPD	MVB	
REV	DESCRIPTION	DATE	DWN	CHKD	APPD	SIGN

RECEIVER'S SIGN/STAMP

PROJECT:

PURPOSE OF RELEASE:

ISSUED FOR CONSTRUCTION

KEY PLAN

CLIENT:

ARKK consulting
 Design Engineering Project Management
 4, Sumer Kendra, Pandurang Budhkar Marg, Worli, MUMBAI - 400 018.
 PHONE: (022) 4025 0100 FAX: (022) 2496 0489
 E-mail: rnj@arkkconsulting.com

DRAWING TITLE:

17 D
 PLUMBING LAYOUT
 19TH FLOOR

NAME	DATE	SIGN
DRAWN BY UMESH	14/10/2016	
CHECKED BY PRADUMNYA	14/10/2016	
APPROVED BY MILIND	14/10/2016	
DRAWING No. 17D/PL-11	SCALE nts	REV 02