


NOTES:

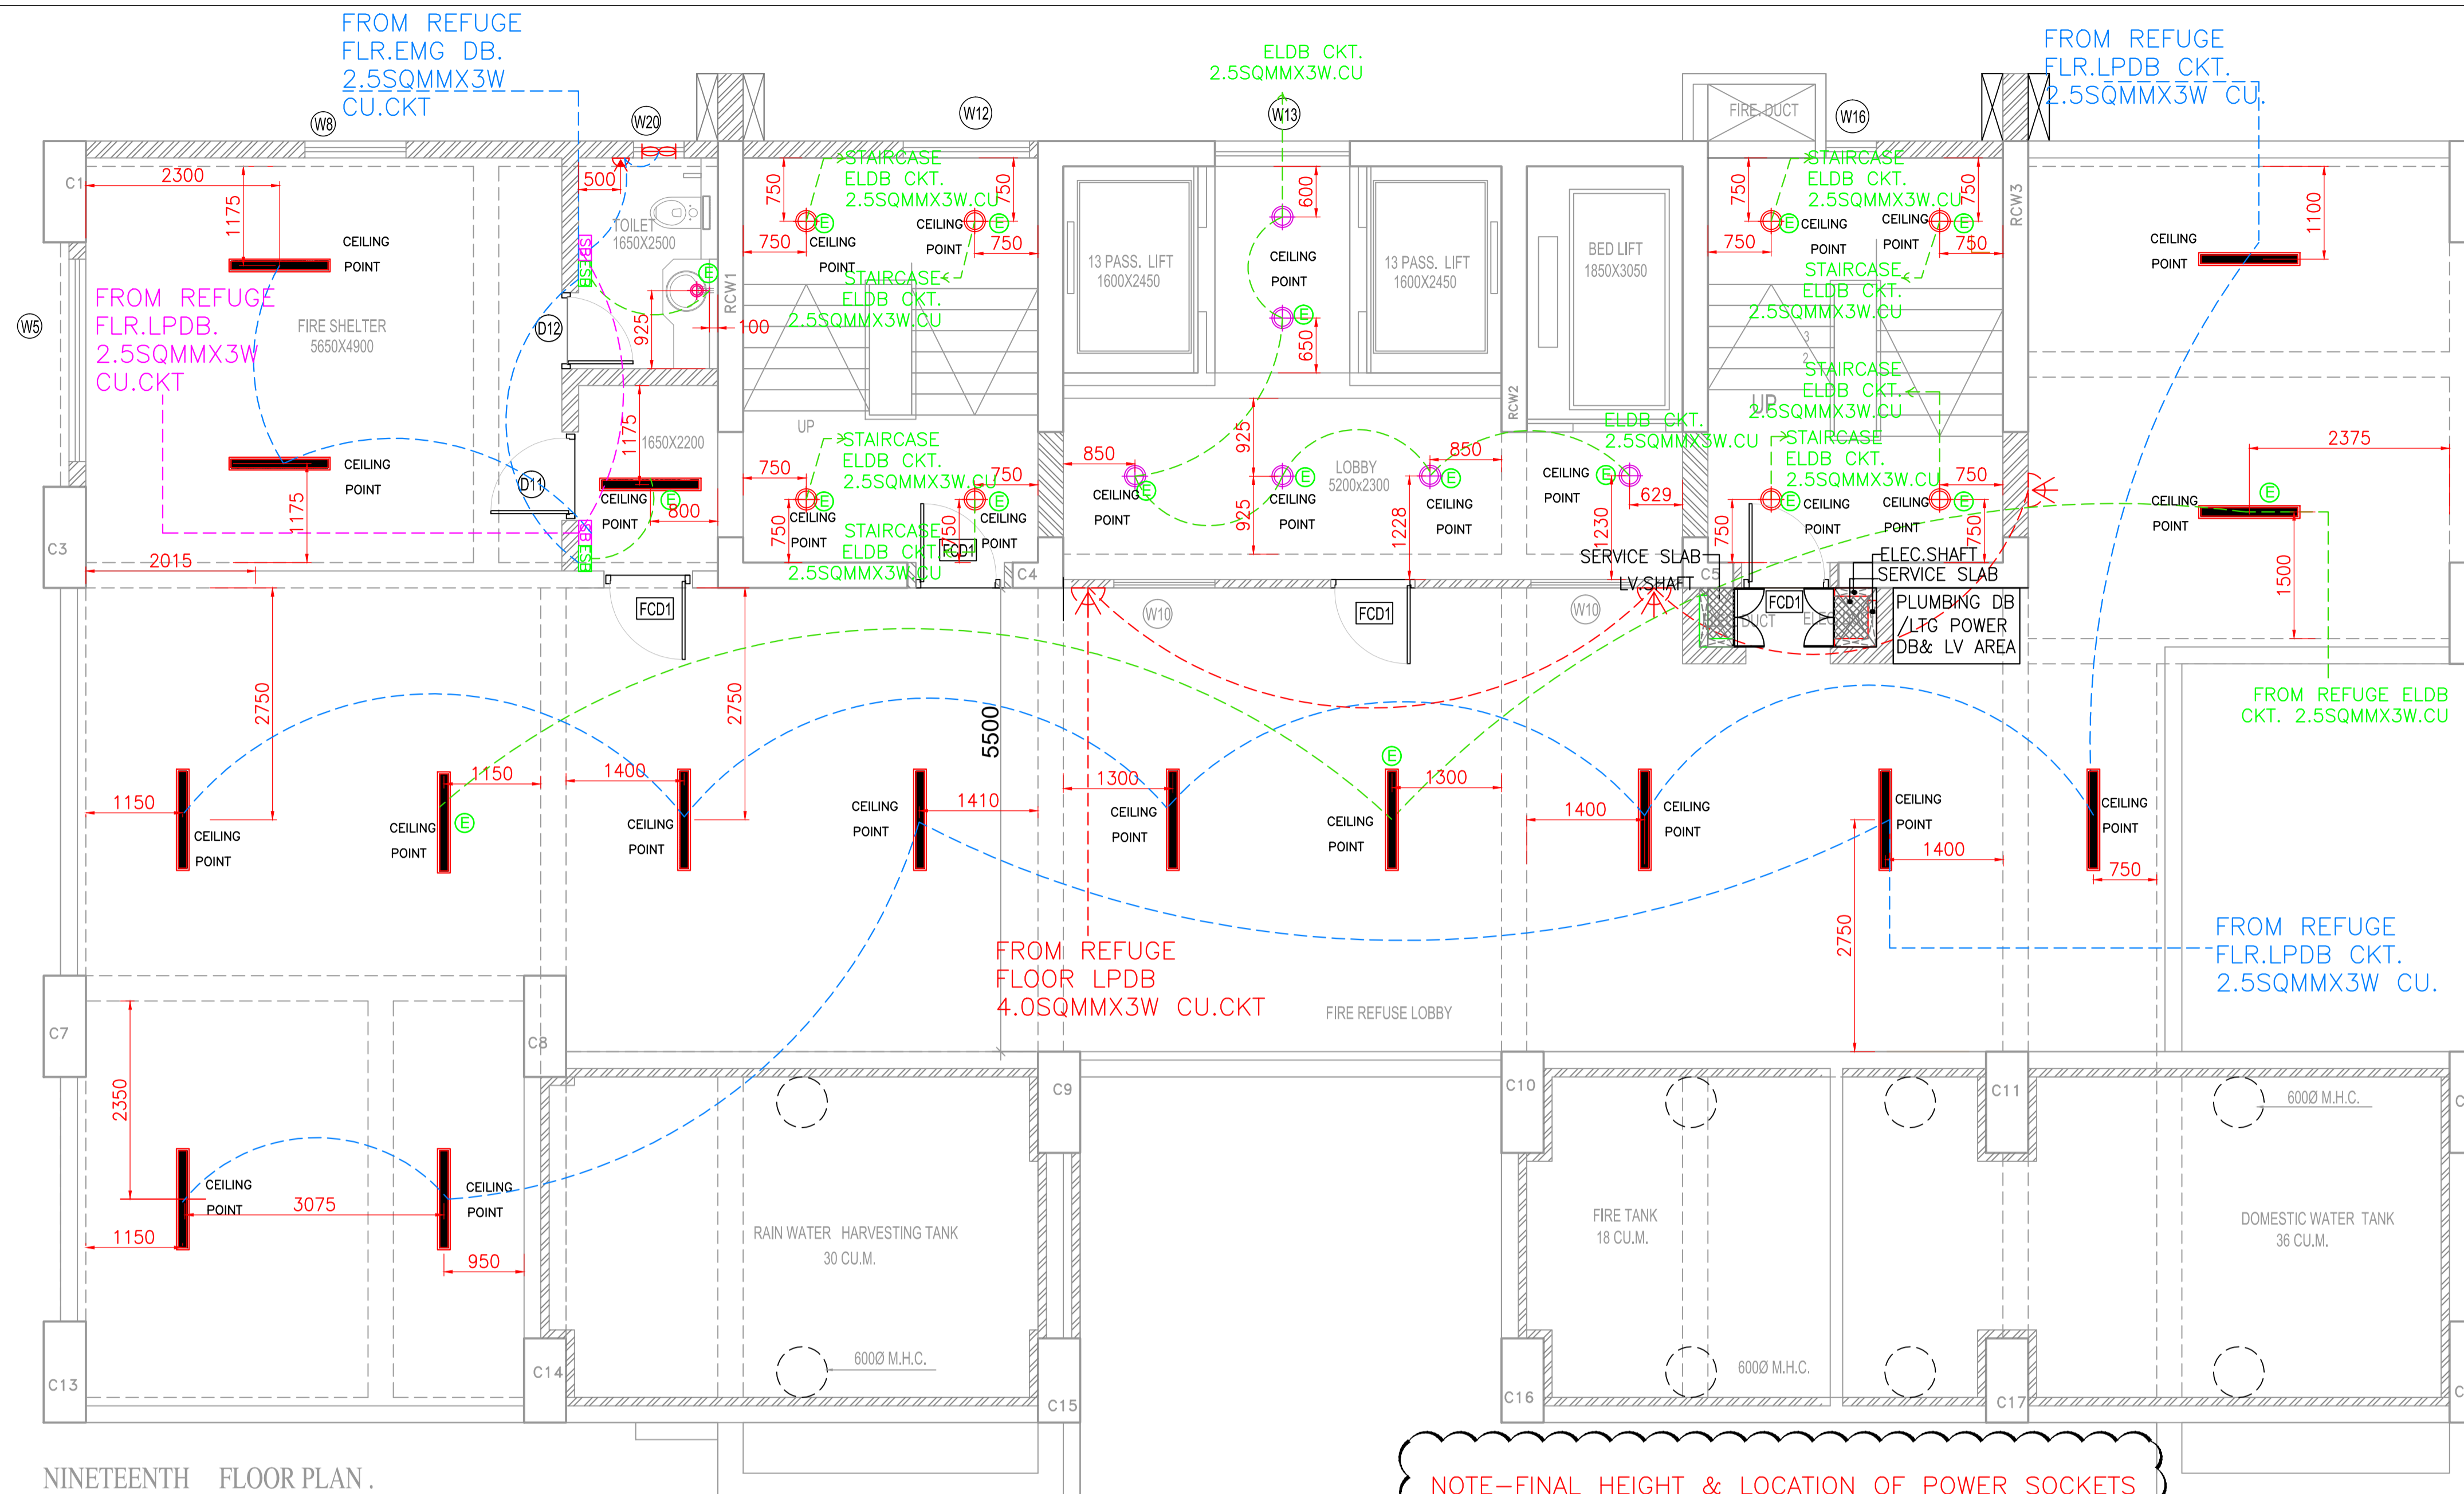

NINETEENTH FLOOR PLAN.

NOTE-FINAL HEIGHT & LOCATION OF POWER SOCKETS SHALL BE IN COORDINATION WITH THE ARCHITECT

LEGEND: LIGHTING LOOPING

| | |
|--|---|
| | SWITCH BOARD |
| | EMERGENCY SWITCH BOARD |
| | NORMAL LIGHTING LOOPING 1.5sq.mmX3w.cu.ckt |
| | SWITCH BOARD TO SWITCH BOARD LOOPING (RAW) 2.5sq.mmX3w.cu.ckt |
| | EMERGENCY LIGHTING LOOPING 1.5sq.mmX3w.cu.ckt |
| | SWITCH BOARD TO SWITCH BOARD LOOPING (EMG.) 2.5sq.mmX3w.cu.ckt |
| | RAW POWER CKT LOOPING (16A) 4sq.mmX3w.cu.ckt |
| | AC CKT 4sq.mmX3w.cu.ckt |
| | GEYSER CKT 4sq.mmX3w.cu.ckt |
| | LIGHTS ON EMERGENCY DB |

LEGEND: LIGHTS FIXTURE

| | |
|--|--|
| | SURFACE MOUNTED TUBE LIGHT |
| | RECESSED SKIRTING LIGHT |
| | 1X18W LIGHT FIXTURE |
| | 2X18W LIGHT FIXTURE |
| | 2X26W LIGHT FIXTURE |
| | BRACKET LIGHT FIXTURE |
| | 1x28W T5 TUBE LIGHT |
| | CEILING FAN |
| | EXHAUST FAN |
| | 16A UTILITY S/W SOCKET (RAW) |
| | 6A UNIVERSAL S/W SOCKET (RAW) |
| | ANTENNA. |
| | 6A UNIVERSAL SOCKET (RAW) |
| | 16A 3PHASE BREAKER FOR STACK PARKING PANEL |

| | | | | | |
|-----|----------------------------|----------|-----|------|------|
| 02 | REVISED AS PER ARCH LAYOUT | 22.06.17 | GPK | PPD | MVB |
| 01 | REVISED AS PER COMMENTS | 20.06.17 | GPK | PPD | MVB |
| 00 | ISSUED FOR CONSTRUCTION | 24.04.17 | GPK | PPD | MVB |
| REV | DESCRIPTION | DATE | DWN | CHKD | APPD |

RECEIVER'S SIGN/STAMP

PROJECT:

PURPOSE OF RELEASE:

ISSUED FOR CONSTRUCTION

KEY PLAN

CLIENT:

ARKK consulting
 Design Engineering Project Management
 4, Sumer Kendra, Pandurang Budhkar Marg, Worli, MUMBAI - 400 018.
 PHONE:(022) 4025 0100 FAX:(022)2496 0489
 E-mail: rnj@arkkconsulting.com

DRAWING TITLE:

17 D ELECTRICAL LAYOUT 19TH FLOOR

| | | | |
|-------------|-----------|------------|------|
| | NAME | DATE | SIGN |
| DRAWN BY | GIRISH | 24/04/2017 | |
| CHECKED BY | PRADUMNYA | 24/04/2017 | |
| APPROVED BY | MILIND | 24/04/2017 | |

DRAWING No. 17D/EL-11 SCALE NTS REV 02