
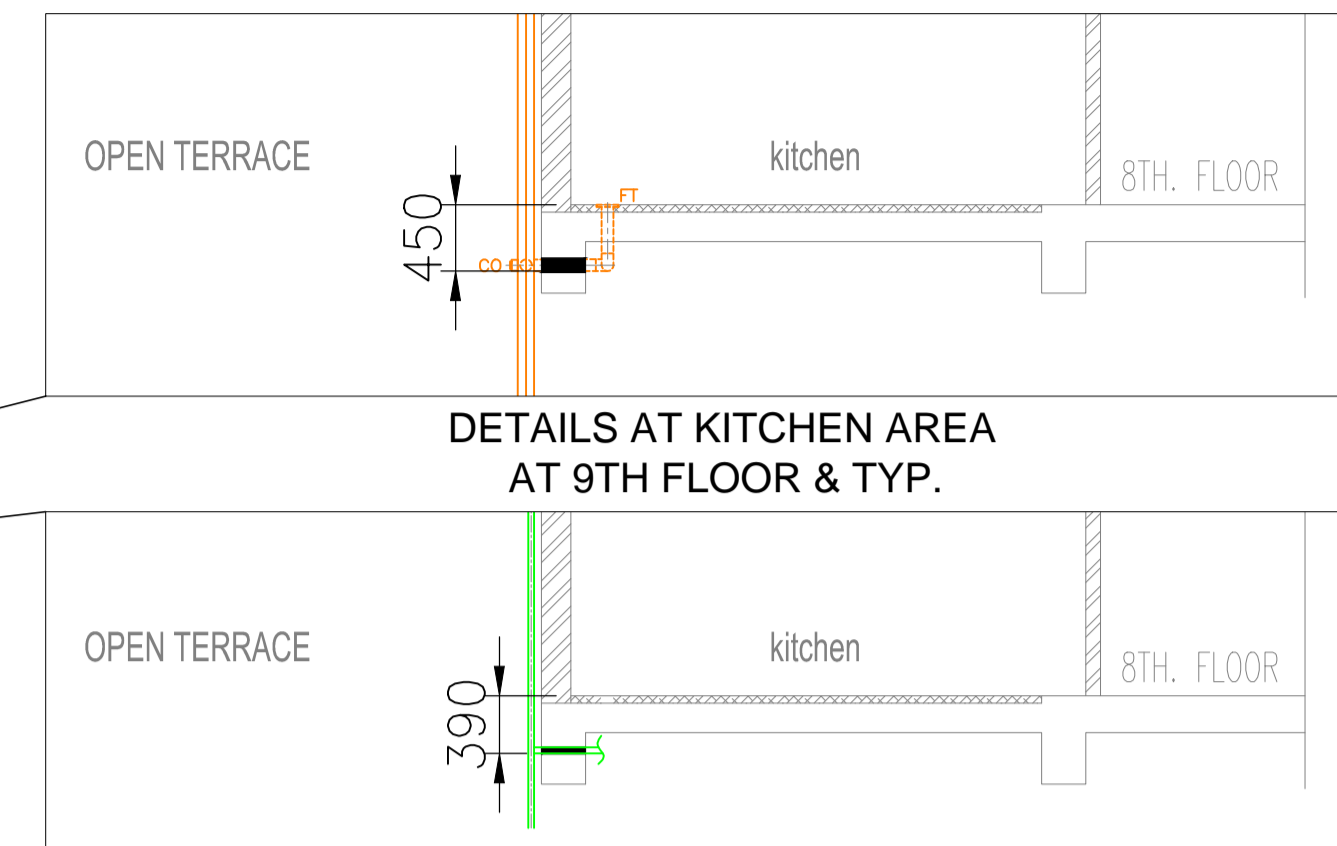


**NINETH FLOOR PLAN
PLUMBING LAYOUT
SCALE 1:75**

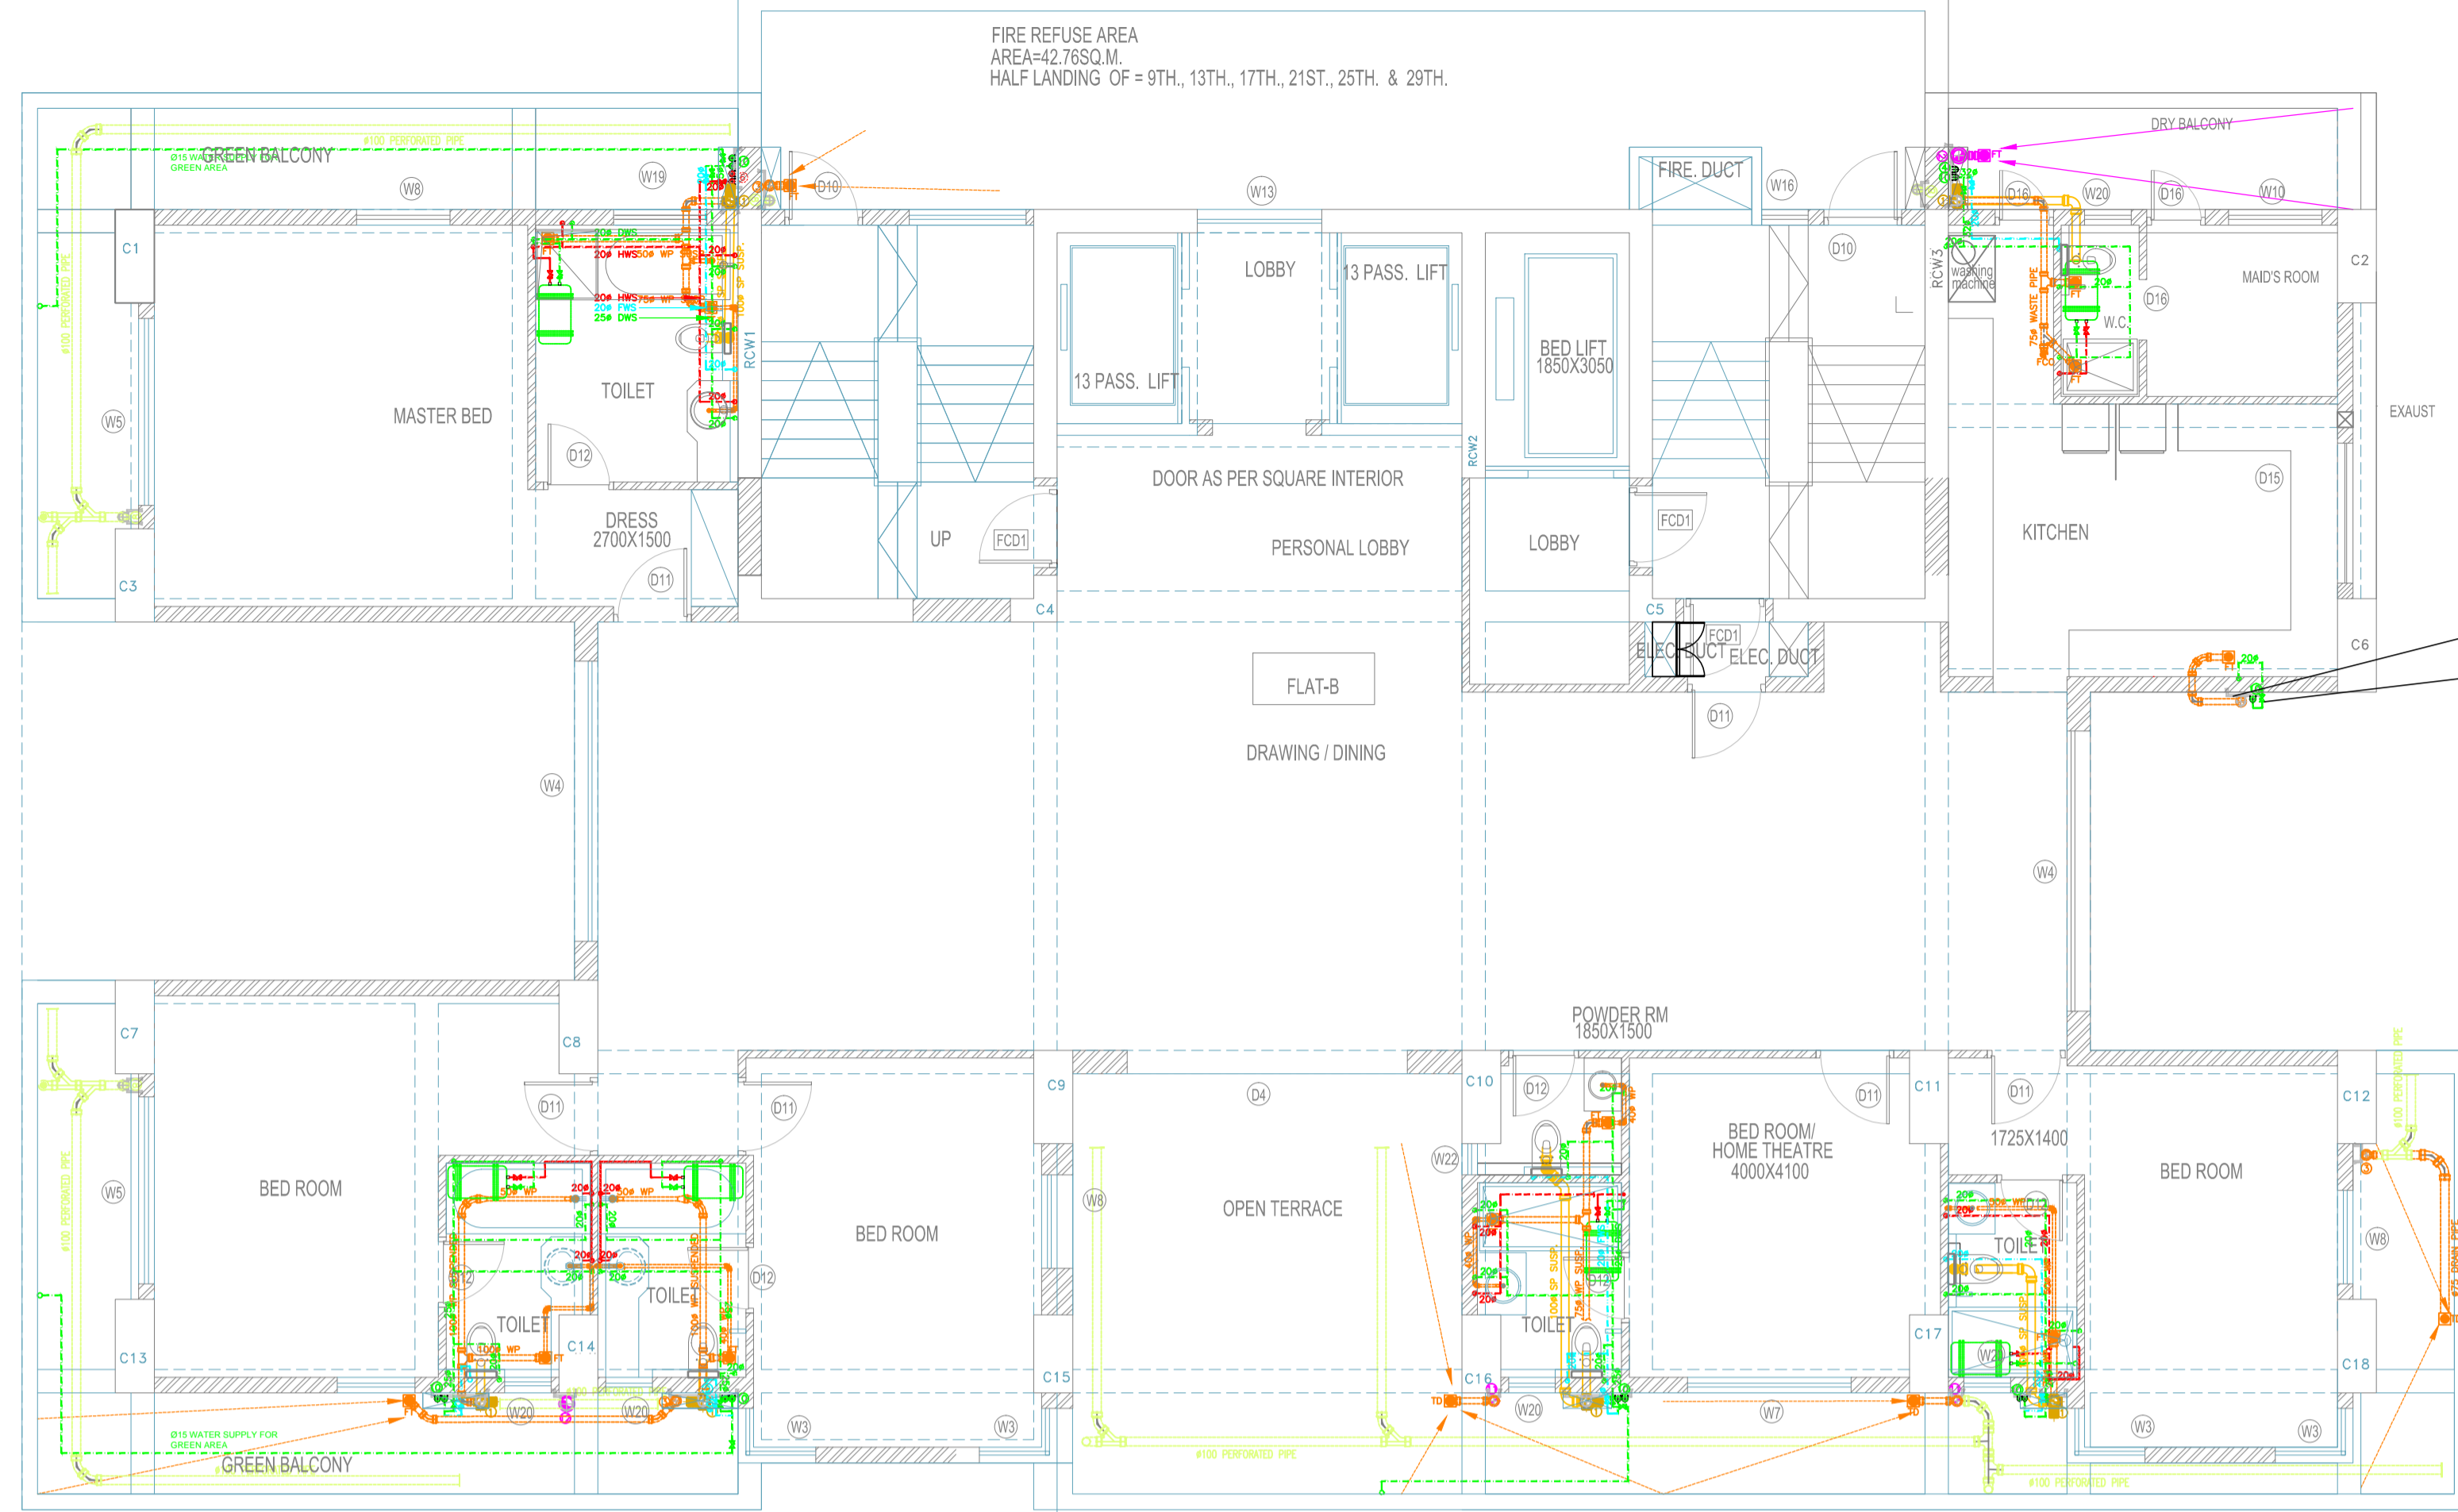


DETAILS AT KITCHEN AREA AT 9TH FLOOR & TYP.

DETAILS AT KITCHEN AREA AT 9TH FLOOR & TYP.

NOTES:

- ① 150# SEWER PIPE T/B
 - ② 150# RAIN WATER PIPE T/B
 - ③ 100# BALCONY DRAIN PIPE T/B
 - ④ DOMESTIC WATER SUPPLY TRANSFER PIPE T/B
 - ⑤ DOMESTIC WATER SUPPLY T/B
 - ⑥ HOT WATER PIPE T/B
 - ⑦ 100# SWIMMING POOL DRAIN PIPE T/B
 - ⑧ 100# DOWN DRAIN PIPE T/B
-
- DOMESTIC WATER SUPPLY PIPE
 - FLUSHING WATER SUPPLY PIPE
 - HOT WATER SUPPLY PIPE
 - SOIL PIPE
 - WASTE PIPE
 - RAIN WATER PIPE
 - FT- FLOOR TRAP
 - FD- FLOOR DRAIN
 - TD- TERRACE DRAIN
 - CD- CORNER DRAIN
 - GEYSER

**NINETH FLOOR PLAN
PLUMBING SLEEVES
SCALE 1:75**

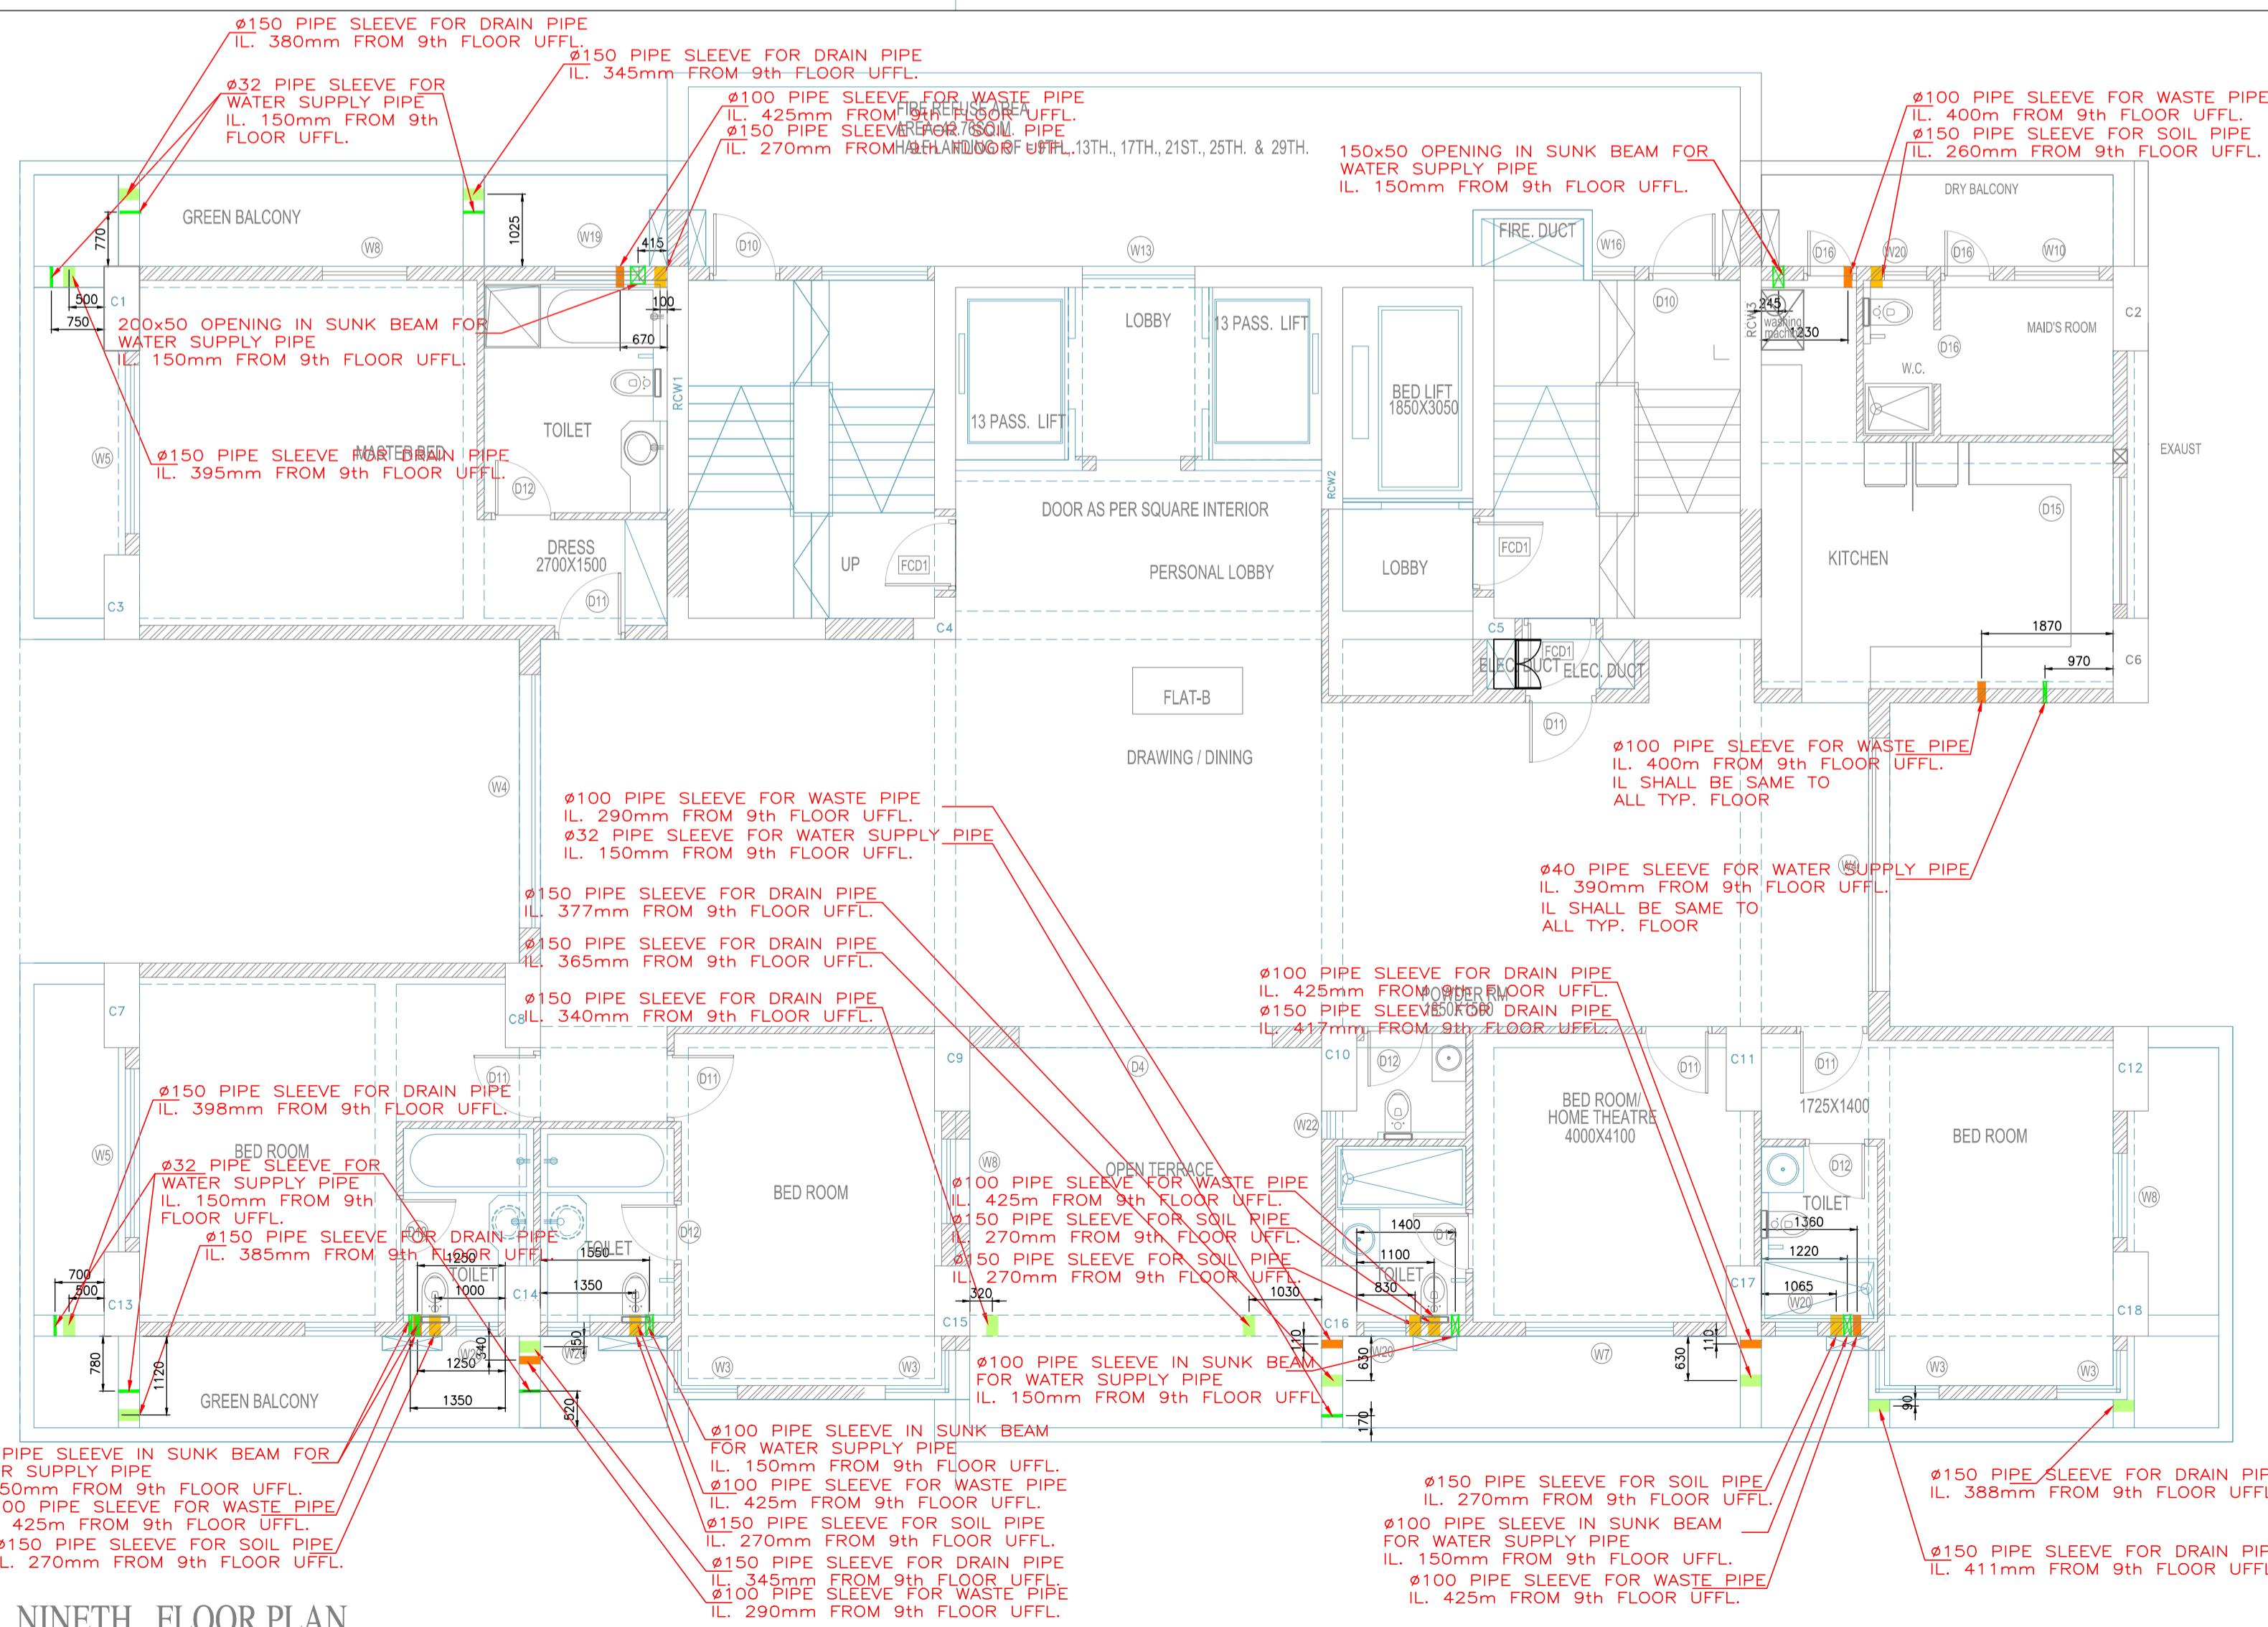

NINETH FLOOR PLAN

REV	DESCRIPTION	DATE	DWN	CHKD	APPD	SIGN
03	REVISED AS PER LAYOUT	06.01.17	UGK	PBK	RNJ	
02	REVISED AS PER LAYOUT	06.12.16	GPK	PPD	MVB	
01	REVISED AS PER LAYOUT	18.11.16	GPK	PPD	MVB	
00	ISSUED FOR CONSTRUCTION	14.10.16	GPK	PPD	MVB	

RECEIVER'S SIGN/STAMP

PROJECT:

PURPOSE OF RELEASE:

ISSUED FOR CONSTRUCTION

CLIENT:

ARKK consulting
Design Engineering Project Management
4, Sumar Kendra, Pandurang Budhkar Marg, Worli, MUMBAI - 400 018.
PHONE: (022) 4025 0100 FAX: (022) 2496 0489
E-mail: rnj@arkkconsulting.com

DRAWING TITLE:

17 D
PLUMBING LAYOUT
9TH FLOOR

NAME	DATE	SIGN
DRAWN BY: UMESH	14/10/2016	
CHECKED BY: PRADUMNYA	14/10/2016	
APPROVED BY: MILIND	14/10/2016	
DRAWING No. 17D/PL-09	SCALE: NTS	REV: 02