




**NINETH FLOOR PLAN
FIRE FIGHTING LAYOUT
SCLE 1:75**

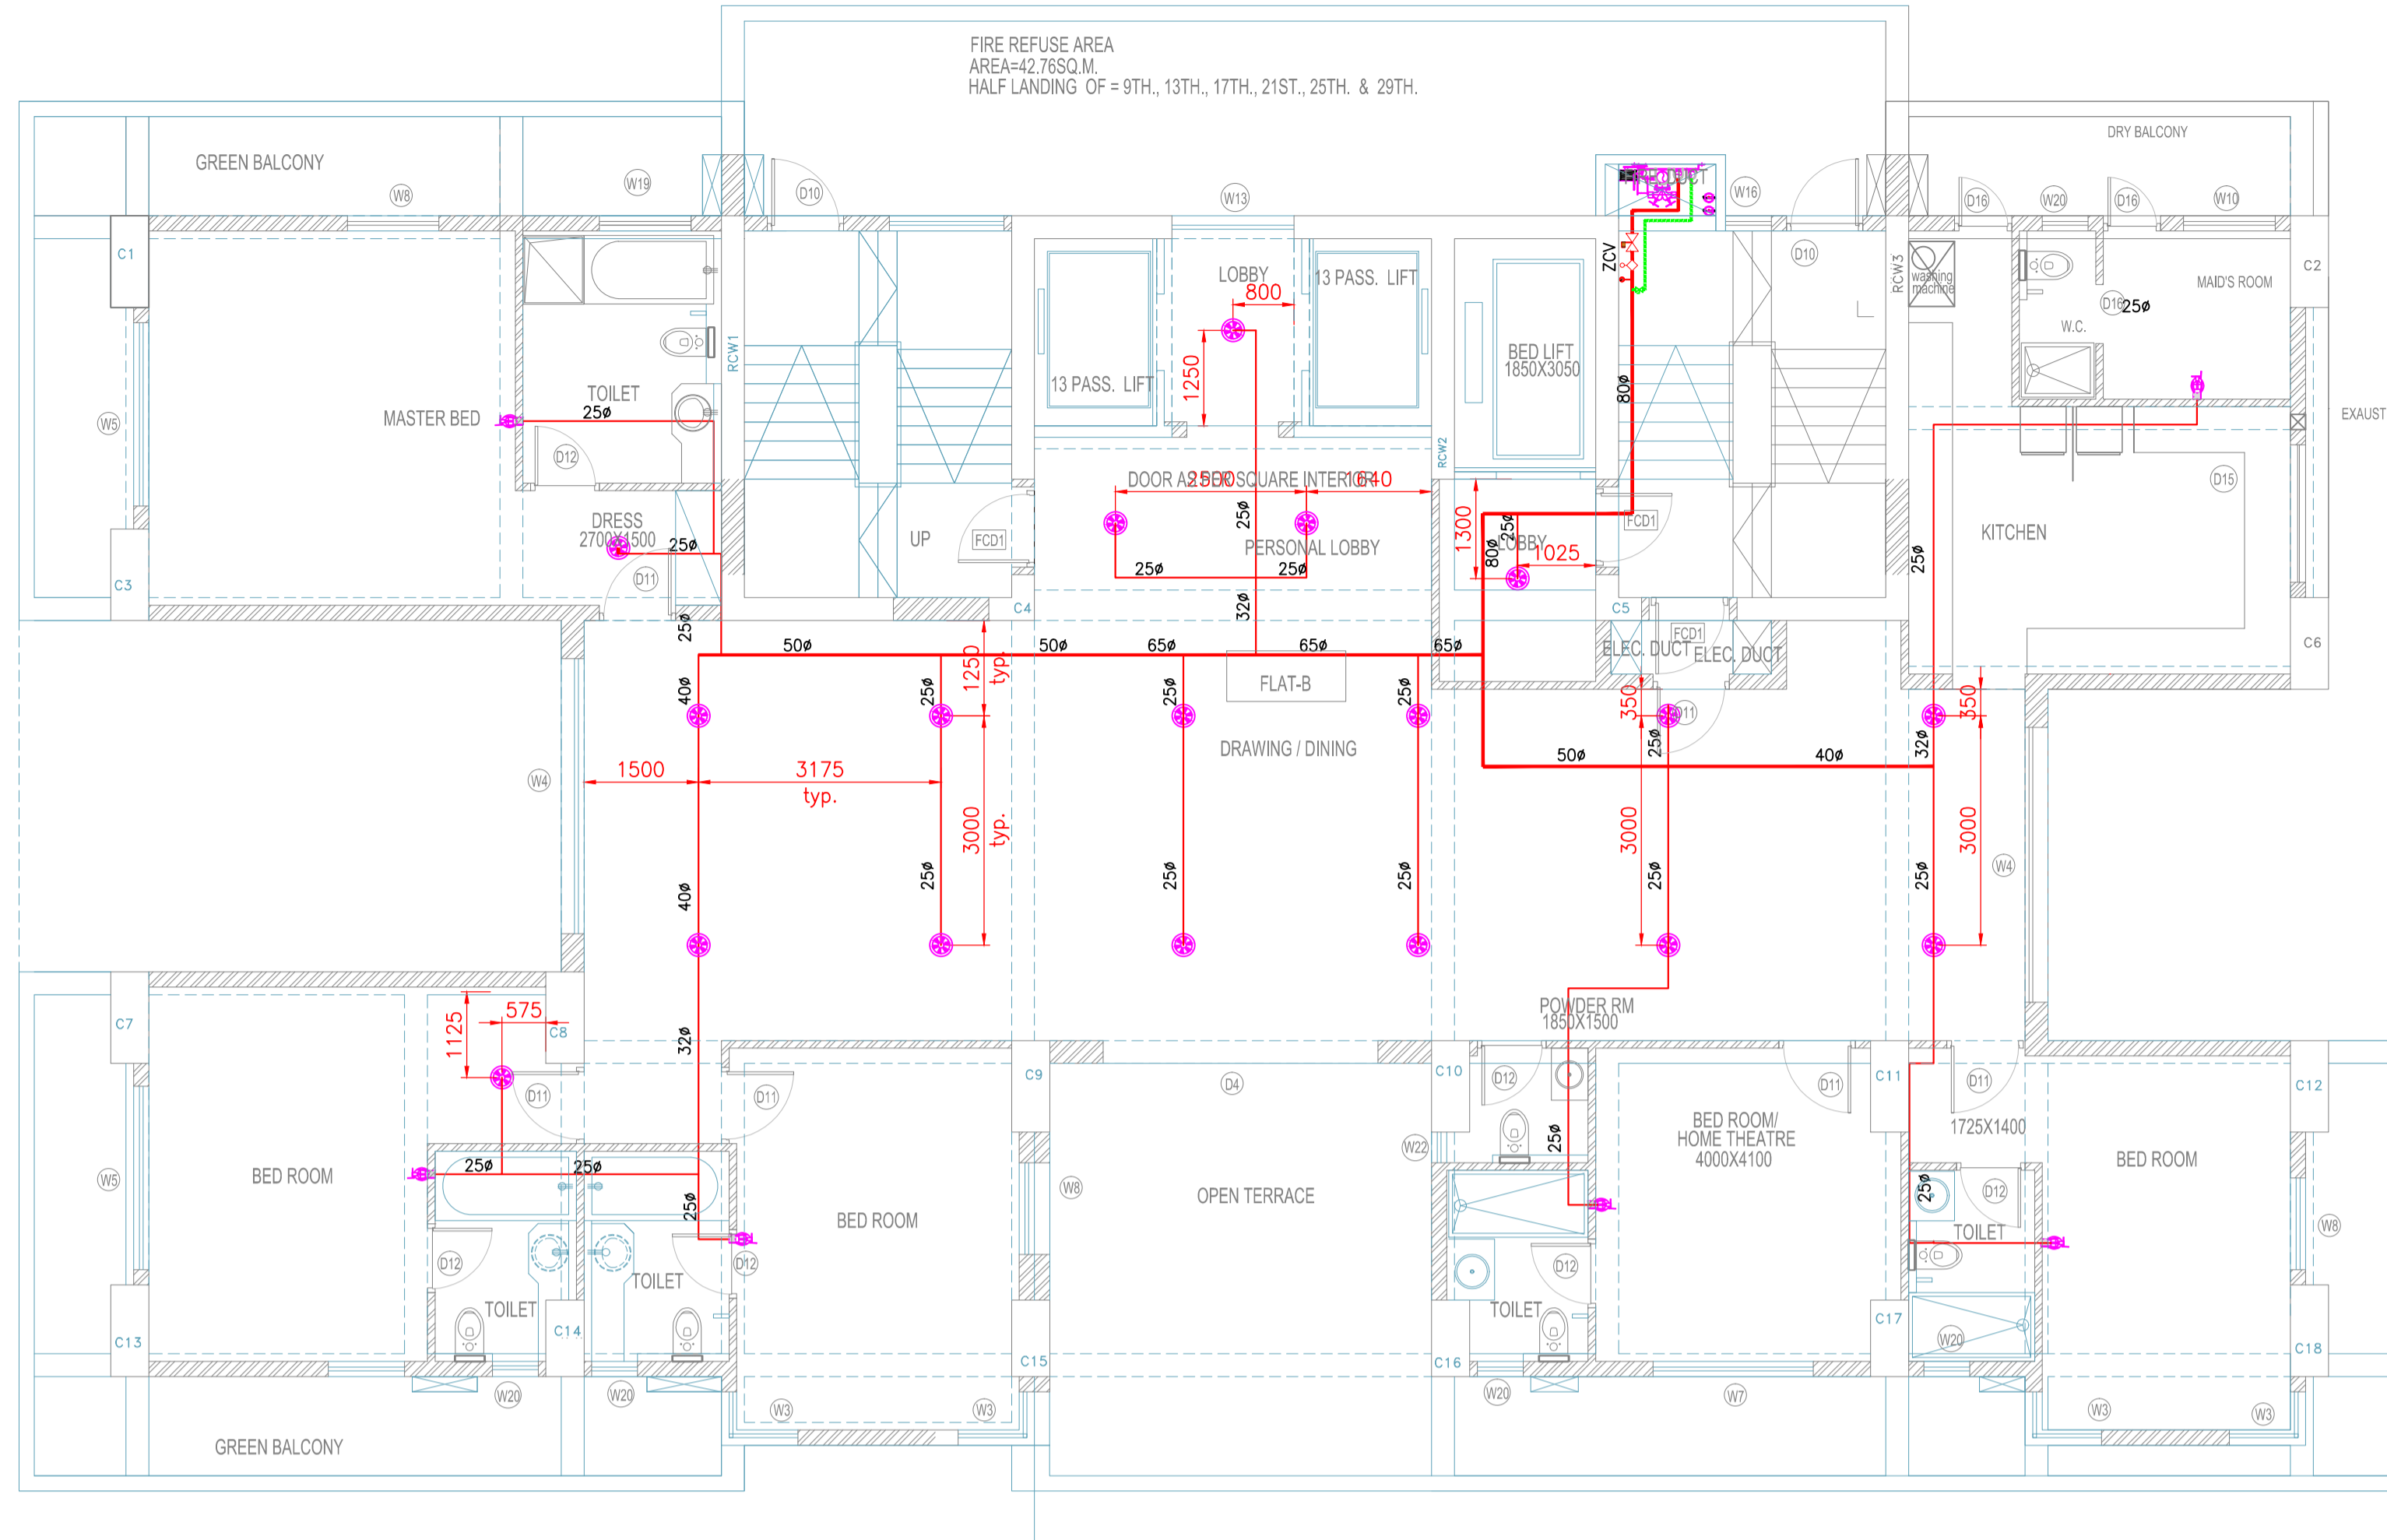

**SLEEVES @ 10TH FLOOR
STRUCTURE
FIRE FIGHTING SLEEVE
LAYOUT
SCLE 1:75**

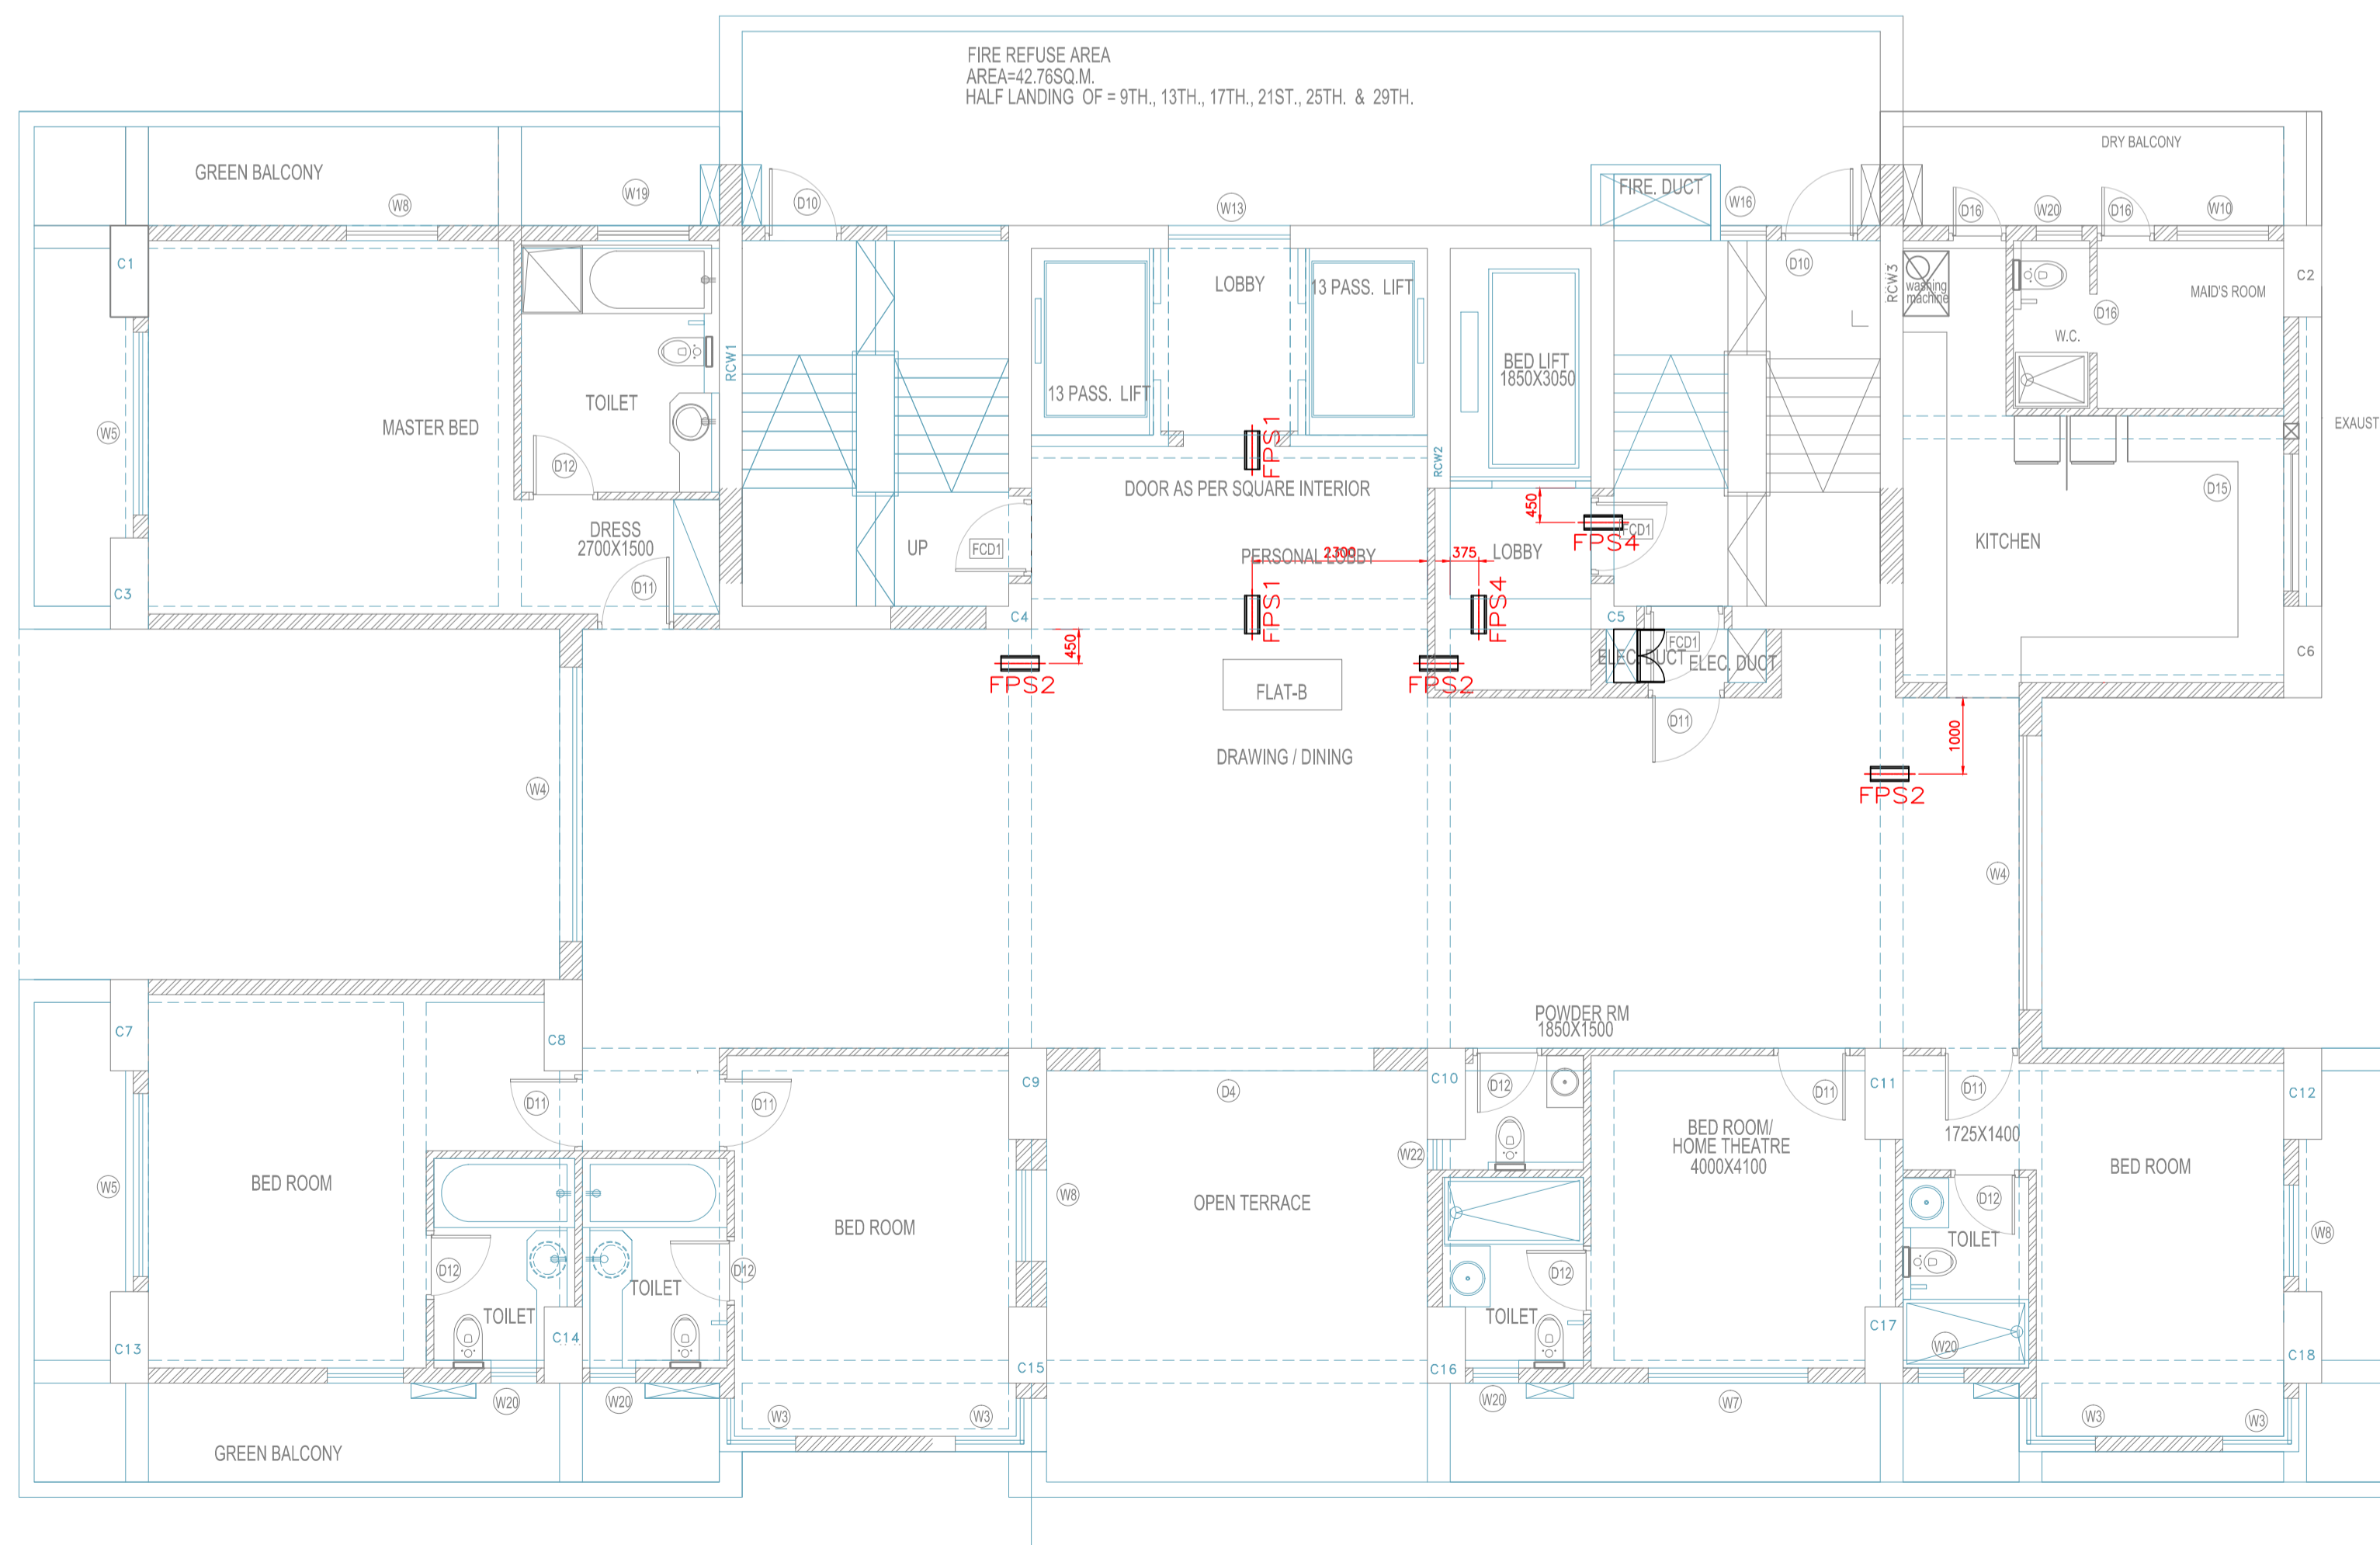


NOTES:

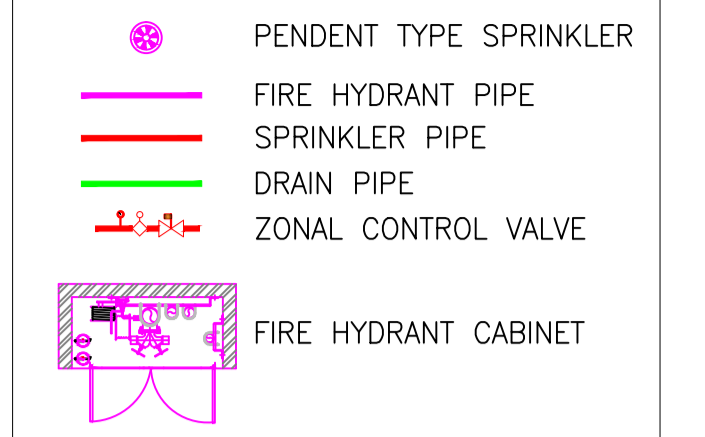

SCHEDULE OF SLEEVES FIRE FIGHTING		
SLEEVE	PIPE SIZE	SLEEVE SIZE
FPS1	ø25 TO ø32	ø40
FPS2	ø40 TO ø50	ø65
FPS3	ø65	ø80
FPS4	ø80	ø100
FPS5	ø100	ø150
FPS6	ø150	ø200

* FPS - FIRE PIPE SLEEVE

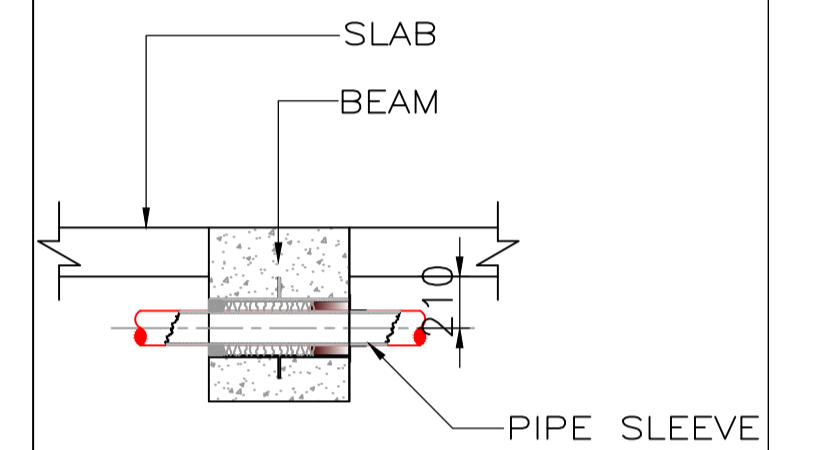

REV	DESCRIPTION	DATE	DWN.	CHKD.	APPD.	SIGN
03	REVISED AS PER LAYOUT	12.01.17	GPK	PPD	MVB	
02	REVISED AS PER LAYOUT	06.12.16	GPK	PPD	MVB	
01	REVISED AS PER LAYOUT	18.11.16	GPK	PPD	MVB	
00	ISSUED FOR CONSTRUCTION	14.10.16	GPK	PPD	MVB	

RECEIVER'S SIGN/STAMP

PROJECT:

PURPOSE OF RELEASE:
ISSUED FOR CONSTRUCTION

KEY PLAN

CLIENT:



ARKK consulting
Design Engineering Project Management
4, Sumer Kendra, Pandurang Budhkar Marg,
Worli, MUMBAI - 400 018.
PHONE: (022) 4025 0100 FAX: (022) 2496 0489
E-mail: rnj@arkkconsulting.com

DRAWING TITLE:
**17 D
FIRE FIGHTING LAYOUT
9TH FLOOR**

NAME	DATE	SIGN
DRAWN BY: UMESH	14/10/2016	
CHECKED BY: PRADUMNYA	14/10/2016	
APPROVED BY: MILIND	14/10/2016	

DRAWING No. 17D/FF-09 SCALE NTS
REV 02