

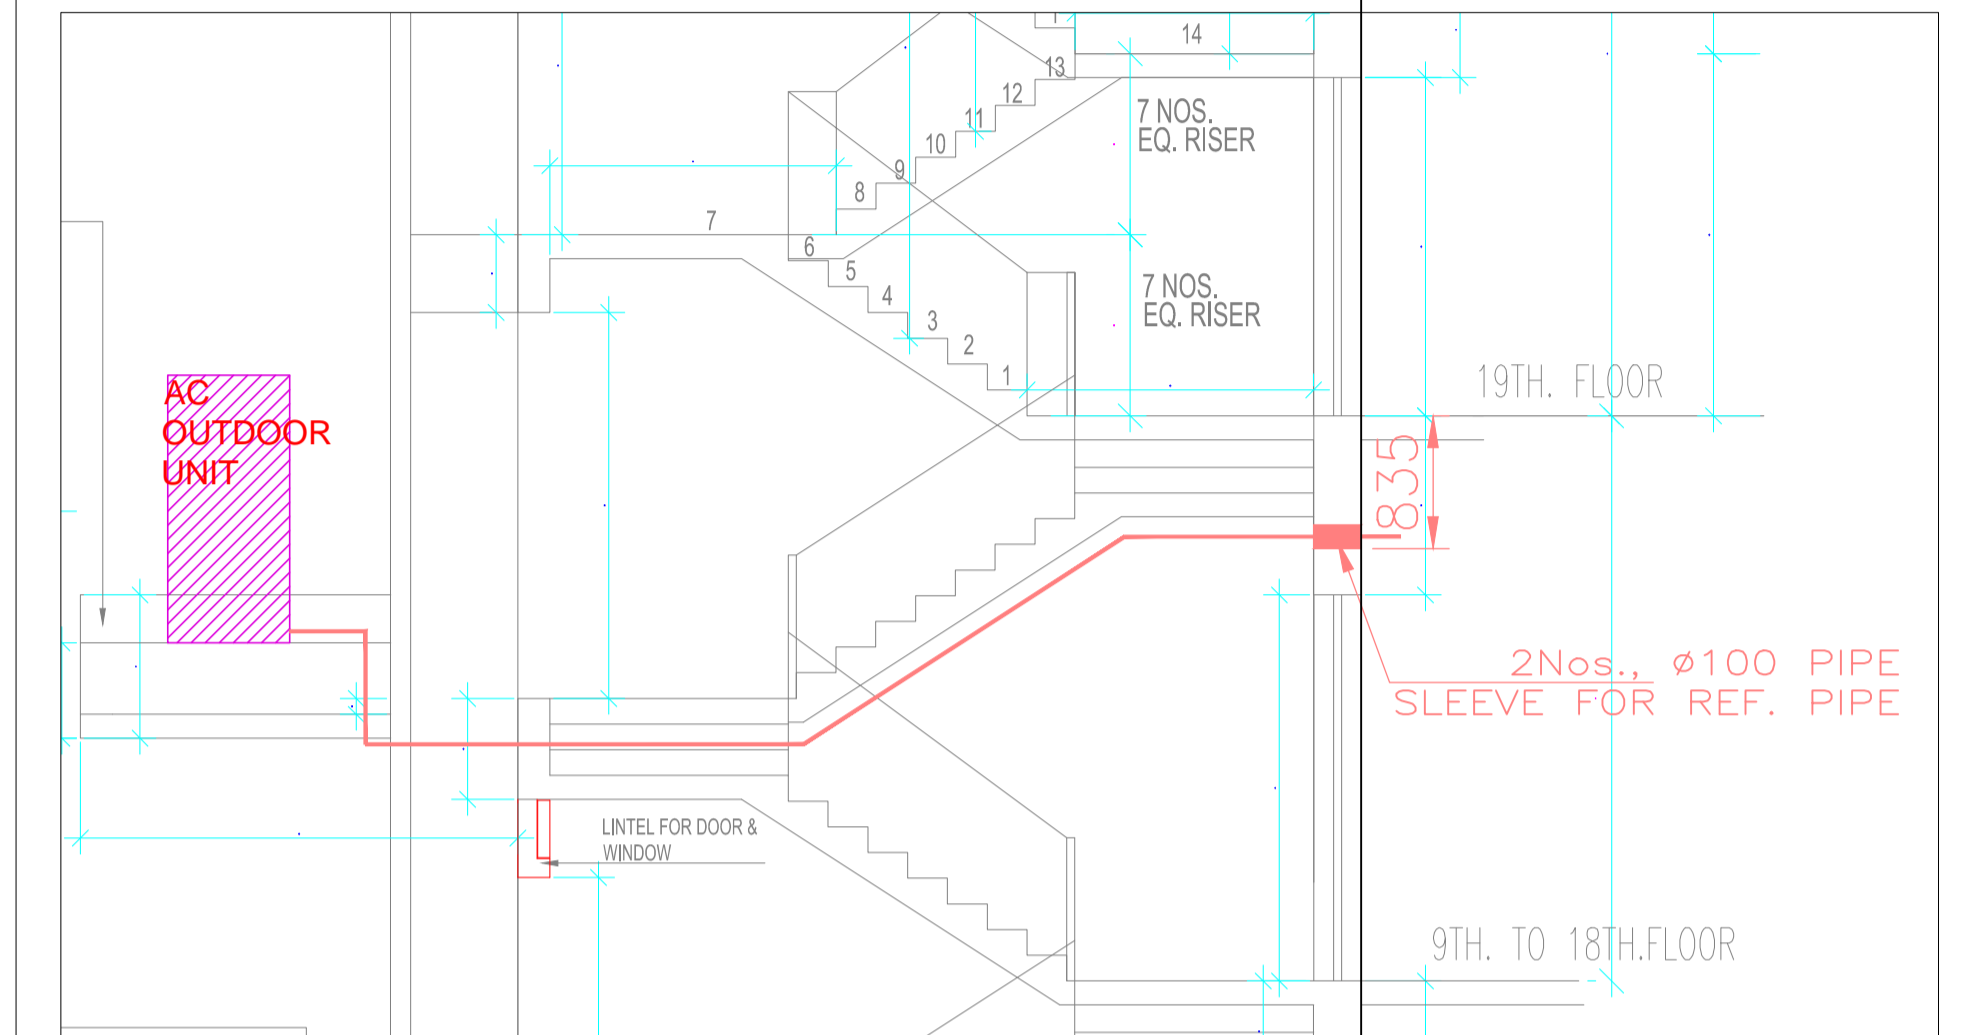


**NINETH FLOOR PLAN
HVAC LAYOUT
SCALE 1:75**

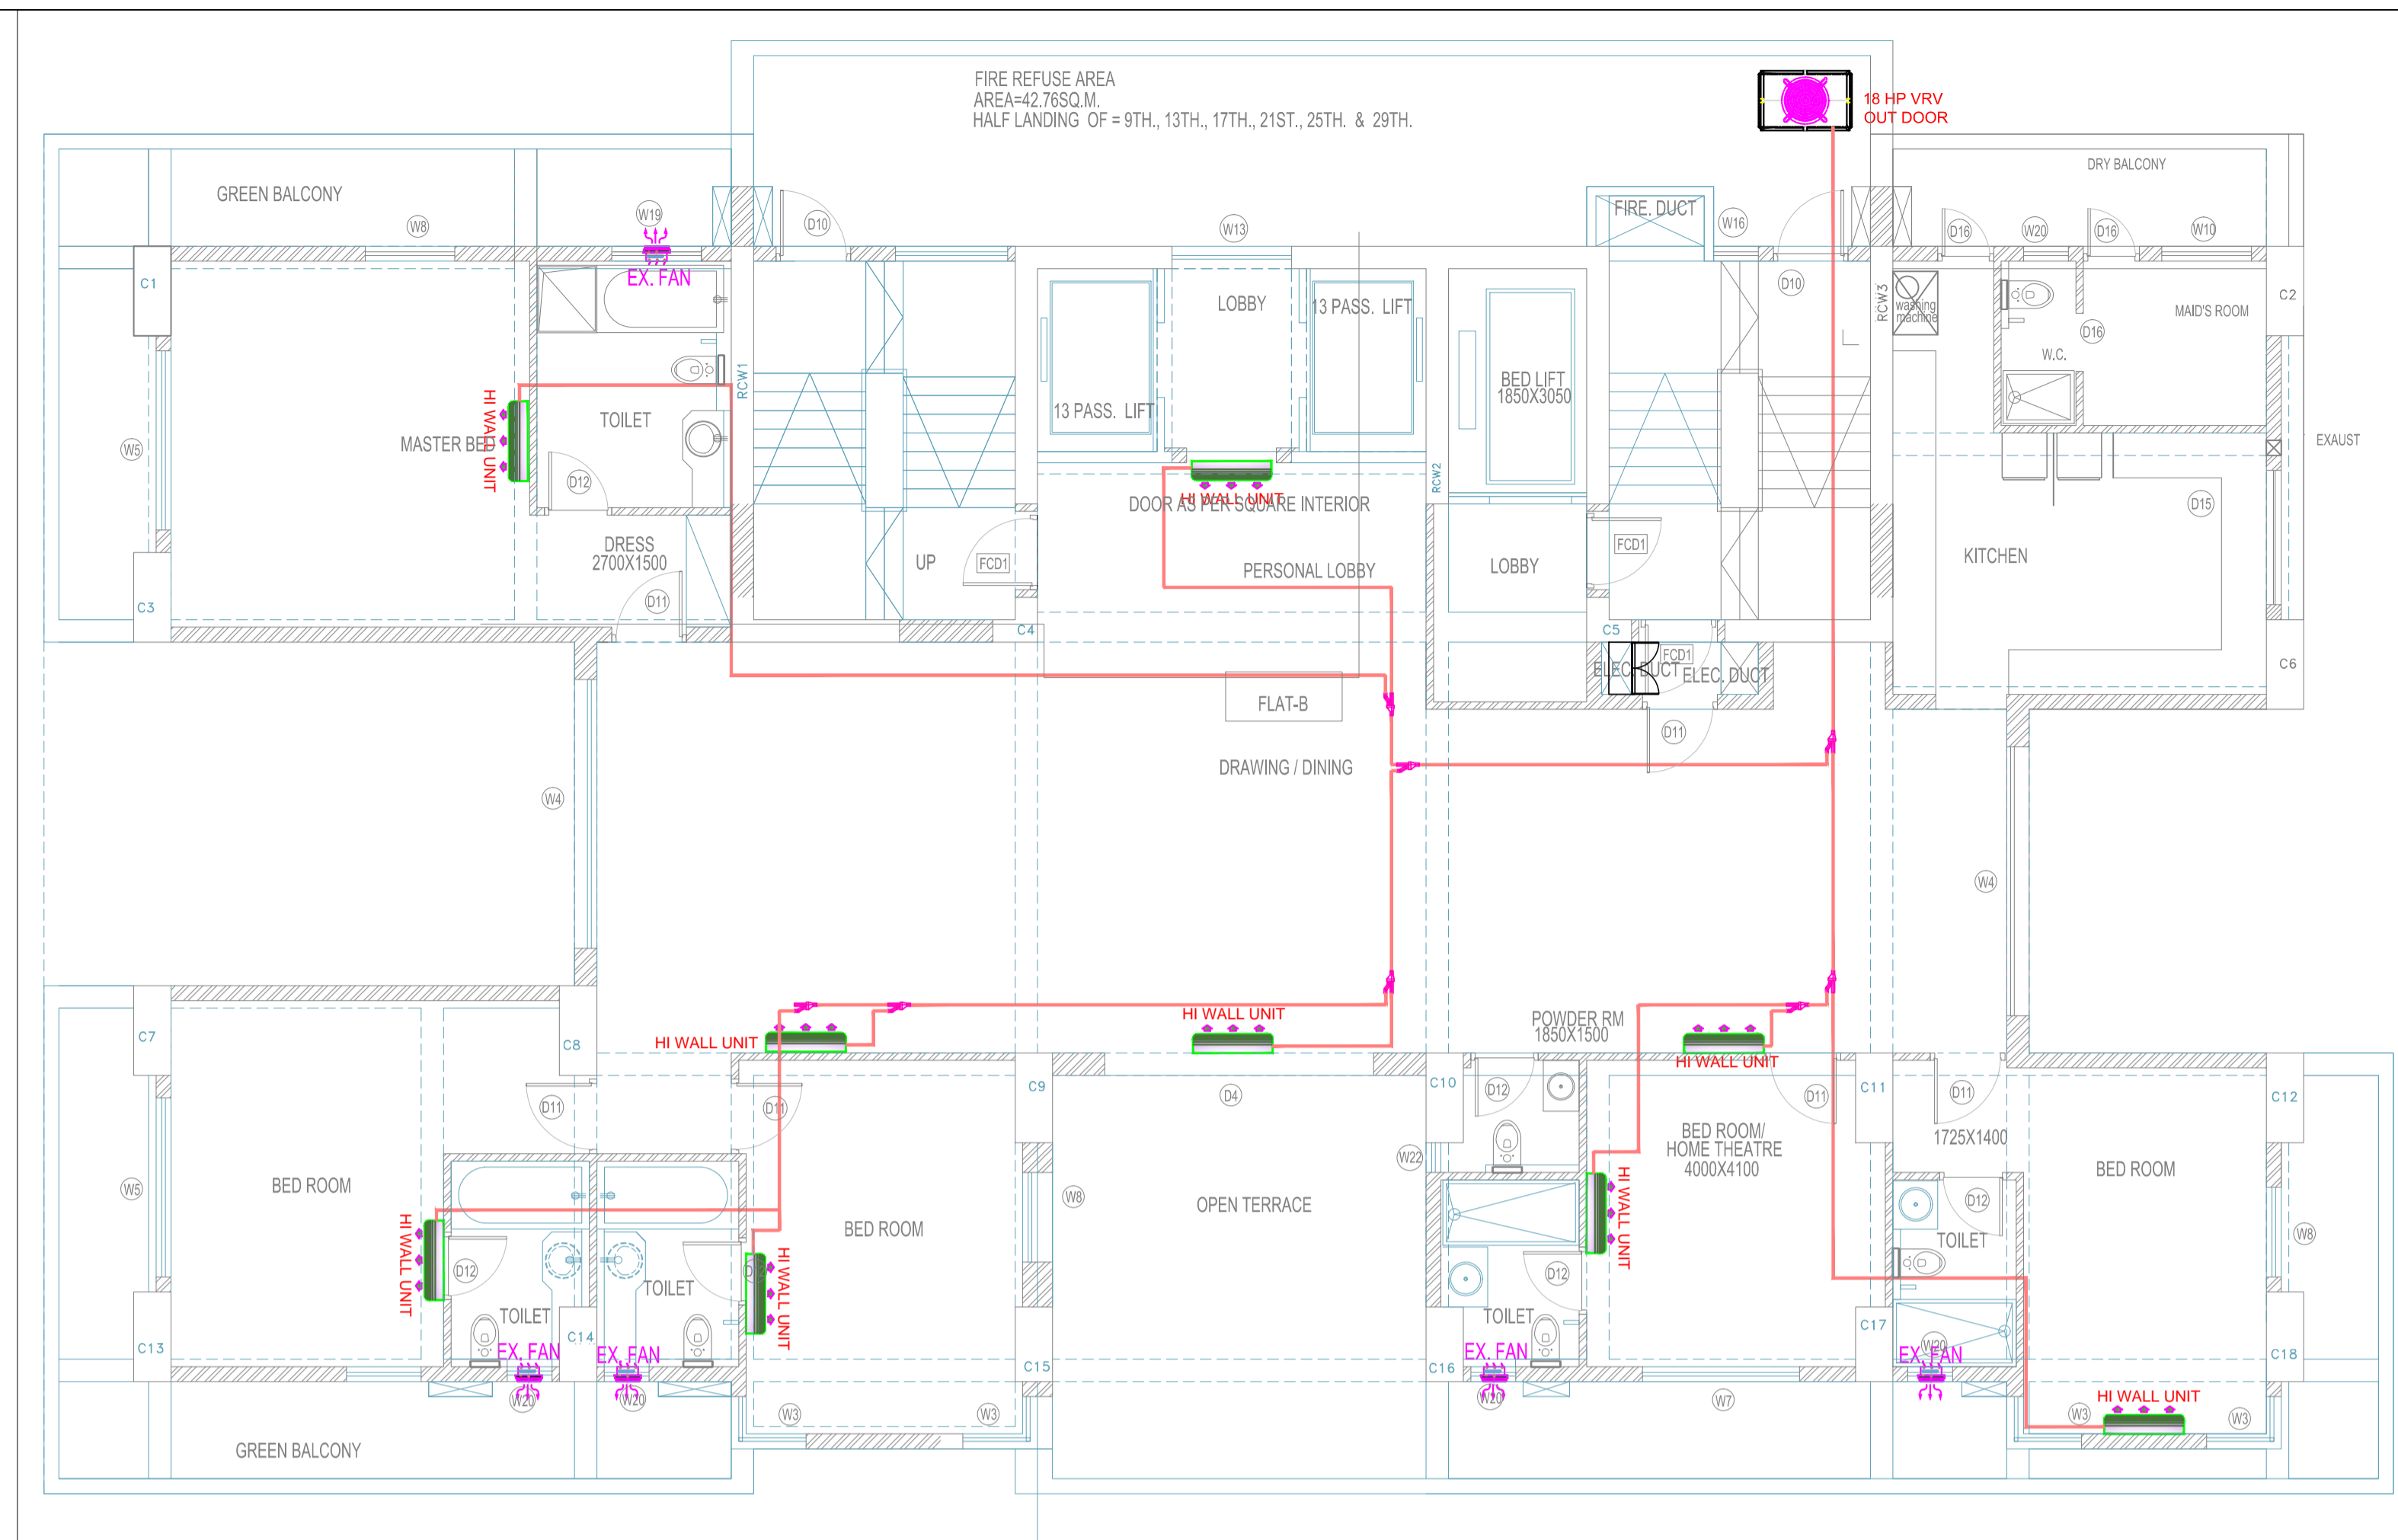

- NOTES:**
- EX. FAN
 - HI WALL UNIT
 - REFERIGERENT PIPE
 - 18 HP VRV OUT DOOR UNIT

**SLEEVES @ 10TH FLOOR
STRUCTURE
HVAC SLEEVE LAYOUT
SCALE 1:75**

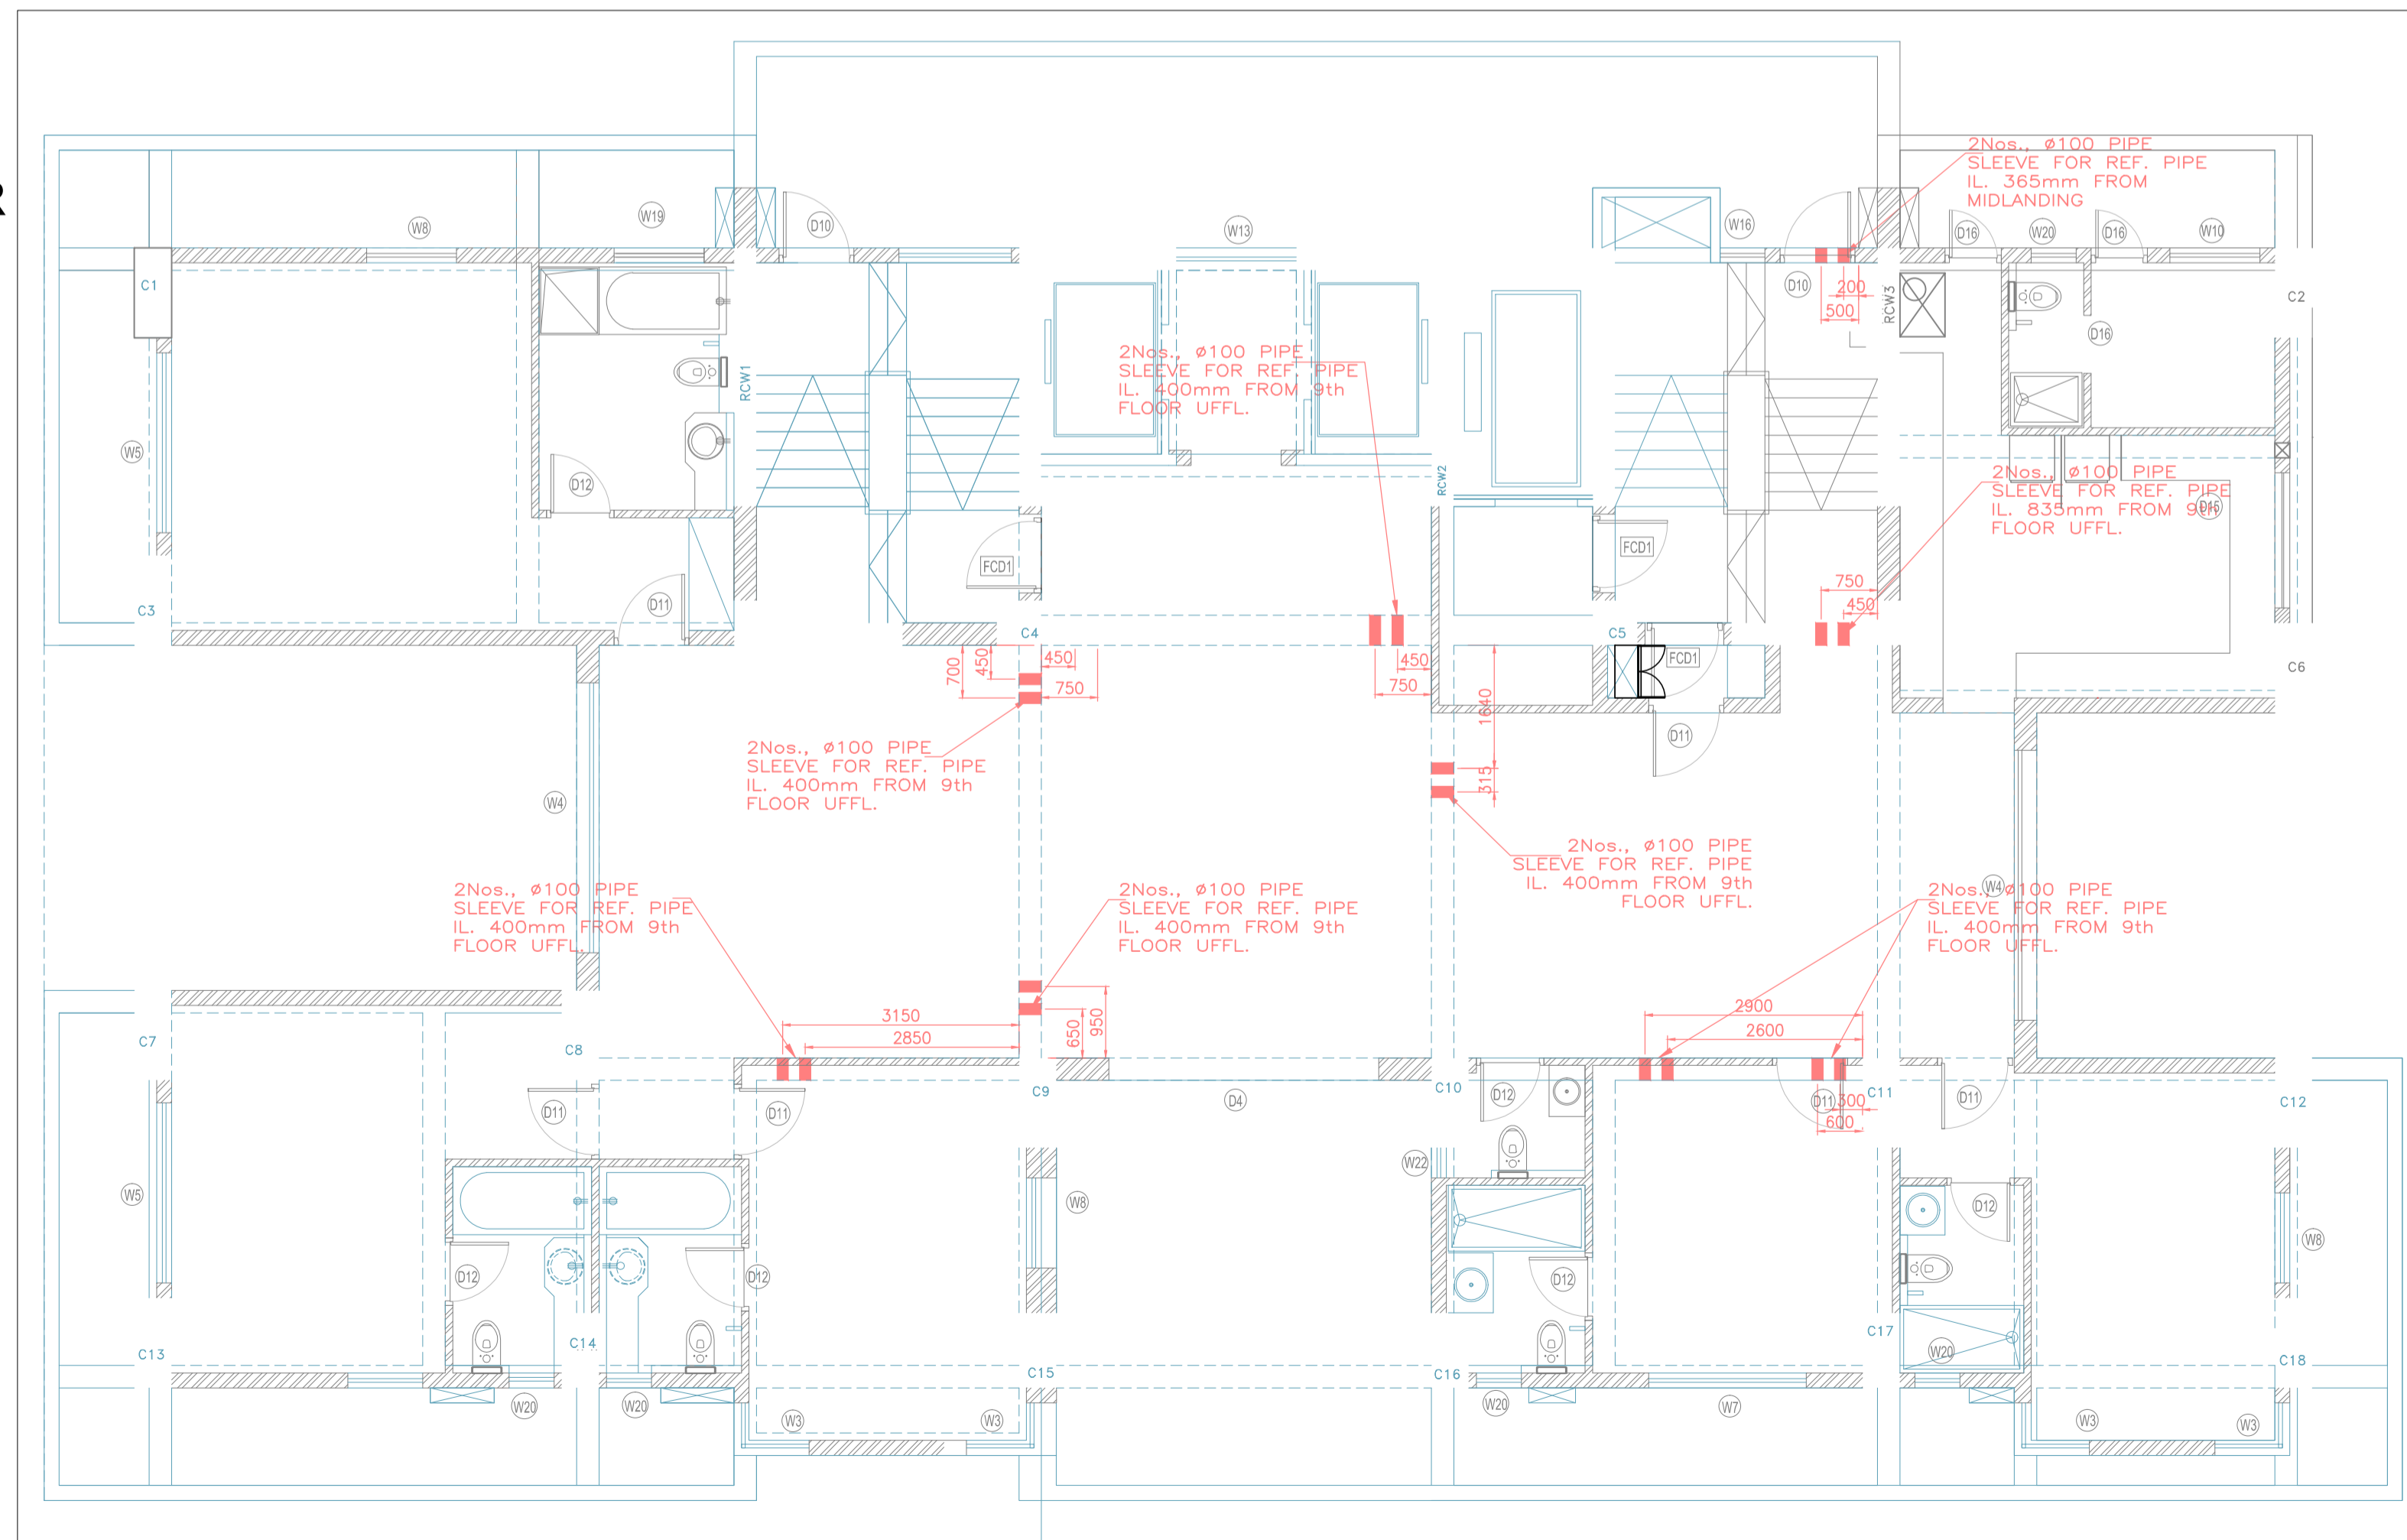

03	REVISED AS PER LAYOUT	12.01.17	GPK	PPD	MVB	
02	REVISED AS PER LAYOUT	06.12.16	GPK	PPD	MVB	
01	REVISED AS PER LAYOUT	18.11.16	GPK	PPD	MVB	
00	ISSUED FOR CONSTRUCTION	14.10.16	GPK	PPD	MVB	
REV	DESCRIPTION	DATE	DWN.	CHKD.	APPD.	SIGN

RECEIVER'S SIGN/STAMP

PROJECT:

PURPOSE OF RELEASE:
ISSUED FOR CONSTRUCTION

CLIENT:
KEY PLAN

ARKK consulting
Design Engineering Project Management
4, Sumar Kendra, Pandurang Budhkar Marg,
Worli, MUMBAI - 400 018.
PHONE:(022) 4025 0100 FAX:(022)2496 0489
E-mail: rnj@arkkconsulting.com

DRAWING TITLE:
**17 D
HVAC LAYOUT
10TH FLOOR**

NAME	DATE	SIGN
DRAWN BY: UMESH	14/10/2016	
CHECKED BY: PRADUMNYA	14/10/2016	
APPROVED BY: MILIND	14/10/2016	
DRAWING No.	SCALE	NTS
17D/AC-09	REV	02