


24 M. WIDE ROAD

STREET NO. 622

P

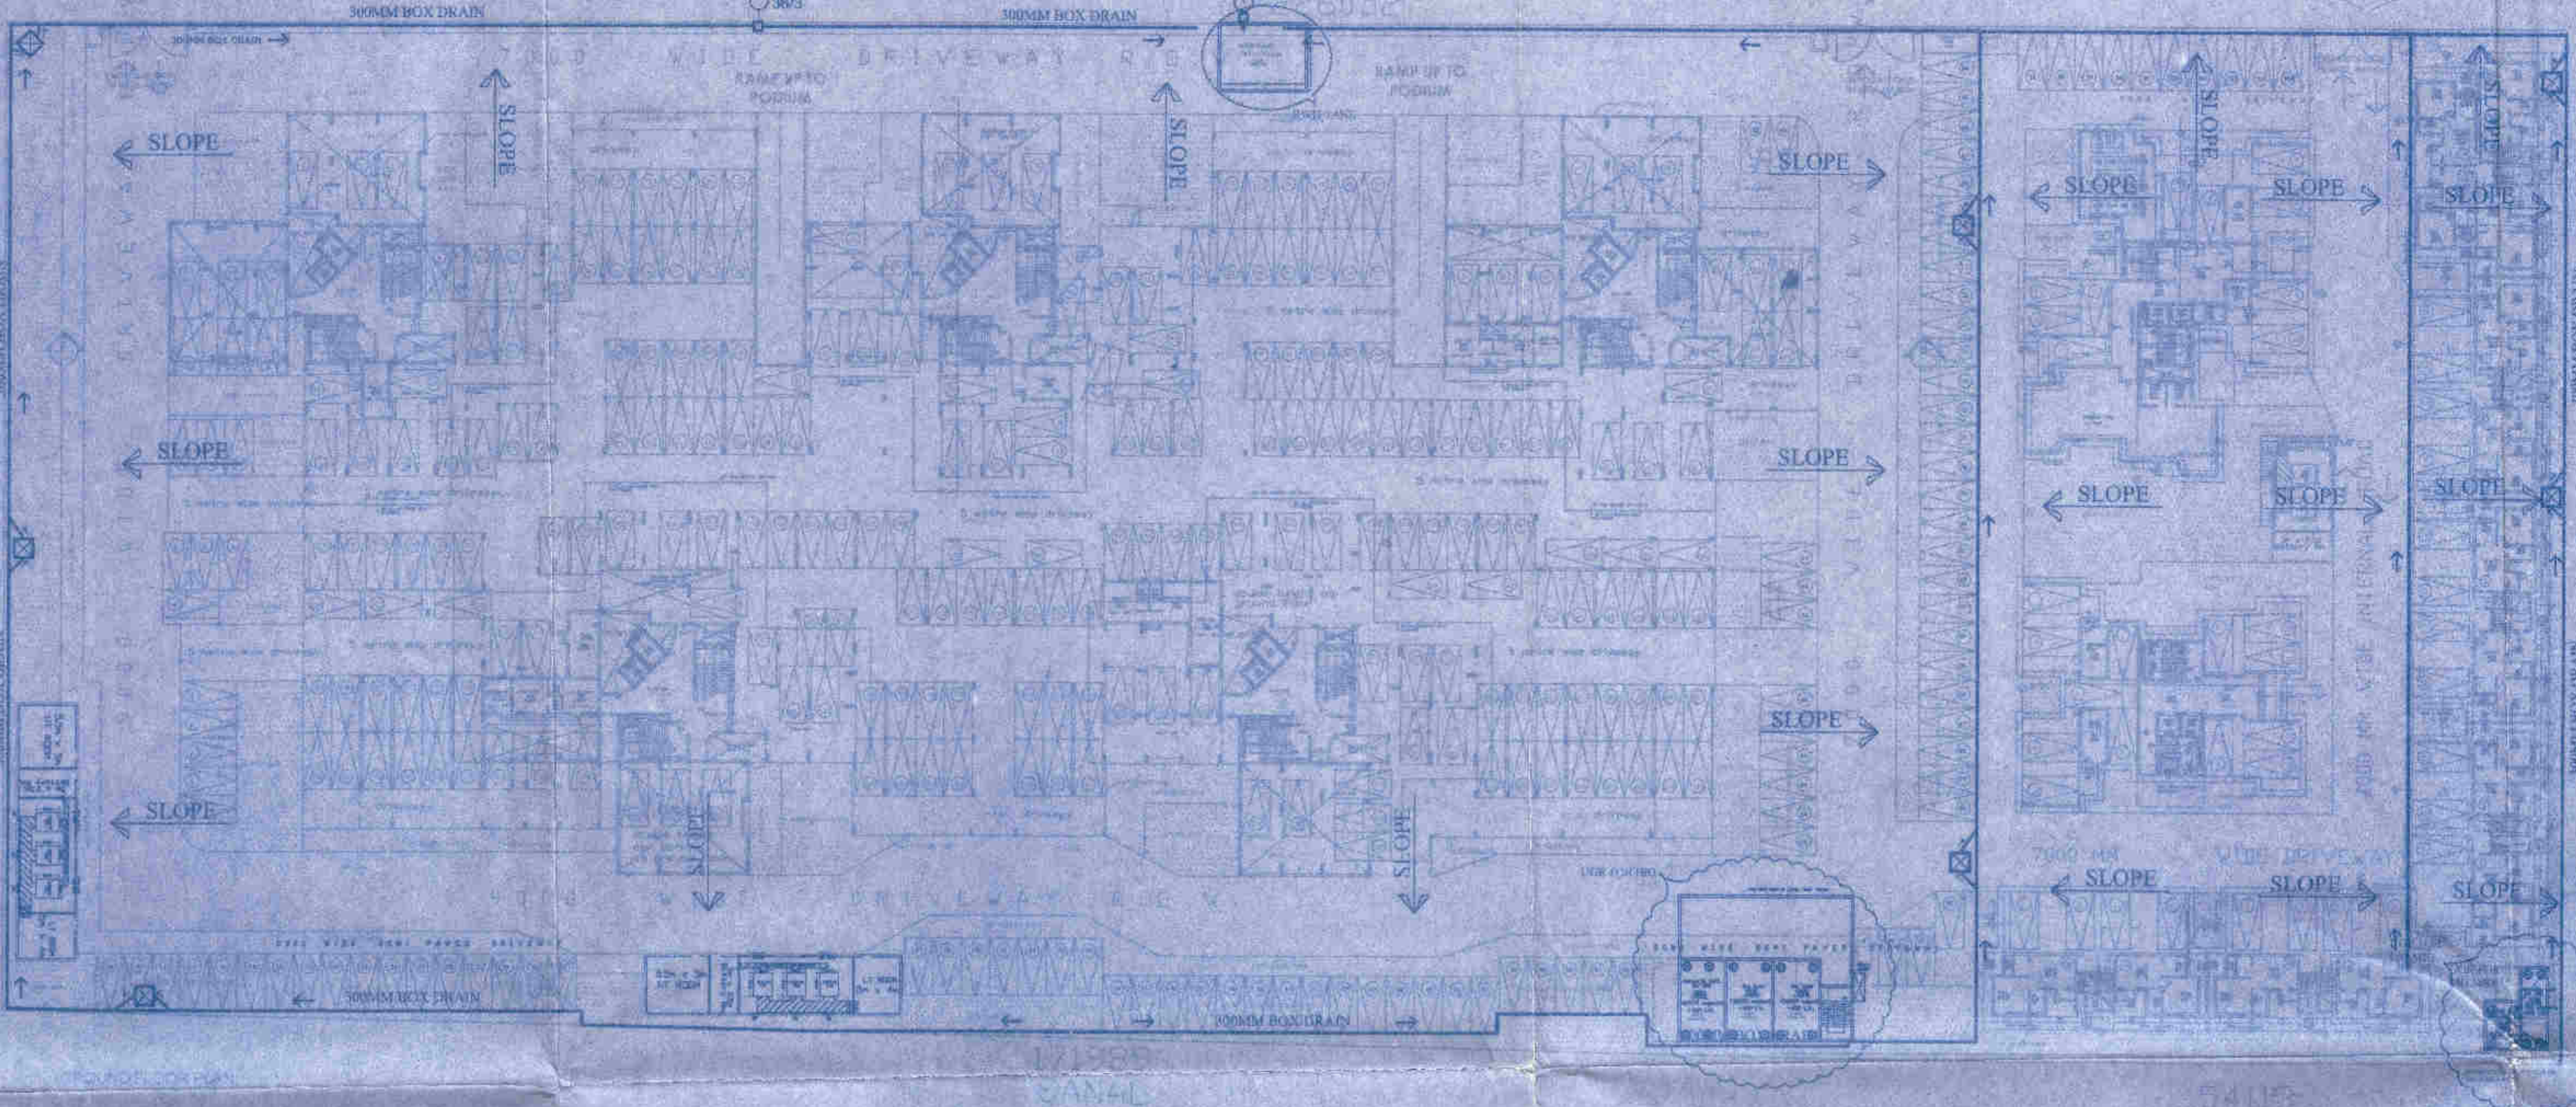

KEY PLAN  
LEGEND

31	300MM BOX DRAIN	
32	ARROW INDICATING SLOPE DIRECTION	
33	NEEDLE NETWORK DIPS	
34	RAIN WATER INP.	
35	RAIN WATER COLLECTION AREA	

*Banabir Das*  
Banabir Das  
B.E. (CIVIL), M.C.E. (ENV. ENGRG.)  
Consulting Public Health Engineer  
PNER / NKDA / 10 / 0004  
BENGAL EMAMI HOUSING LTD.  
Authorized Signatory

1618 BENGAL EMAMI HOUSING CORPORATION LIMITED

R5	21.10.15	AS PER NEW ARCHITECTURAL	PRASHANT	SHIRISH B.
R4	27.08.15	AS PER NEW ARCHITECTURAL	NILESH B.	SHIRISH B.
R3	20.07.15	AS PER COMMENTS	NILESH B.	SHIRISH B.
R2	21.07.15	AS PER NEW ARCHITECTURAL	NILESH B.	SHIRISH B.
R1	17.08.14	AS PER NEW ARCHITECTURAL	ROHIT	CHAKRABARTY
R0	07.06.14	FIRST TIME LOGGED	ROHIT	CHAKRABARTY
REV.	DATE	PARTICULARS	DESIGNED	CHECKED

OWNER: BENGAL EMAMI HOUSING LTD.  
ARCHITECT: ARCHITECT HAFEEZ CONTRACTOR

SCALE: 1:350 REVISION: R5

STATUS: NKDA SUBMISSION

TITLE: EXTERNAL STORM WATER LAYOUT

DRAWING NO.: 1618/P/C/ESTL/109

DATE: 21.10.15

DRAWN BY: SOPAN B.

DESIGNED BY: PRASHANT


CHECKED BY: NISAHNT

APPROVED BY: SHIRISH B.



*Harsh Sanon*

HARSH SANON  
COUNCIL OF ARCHITECTURE  
REGISTRATION No. CA/90/8554

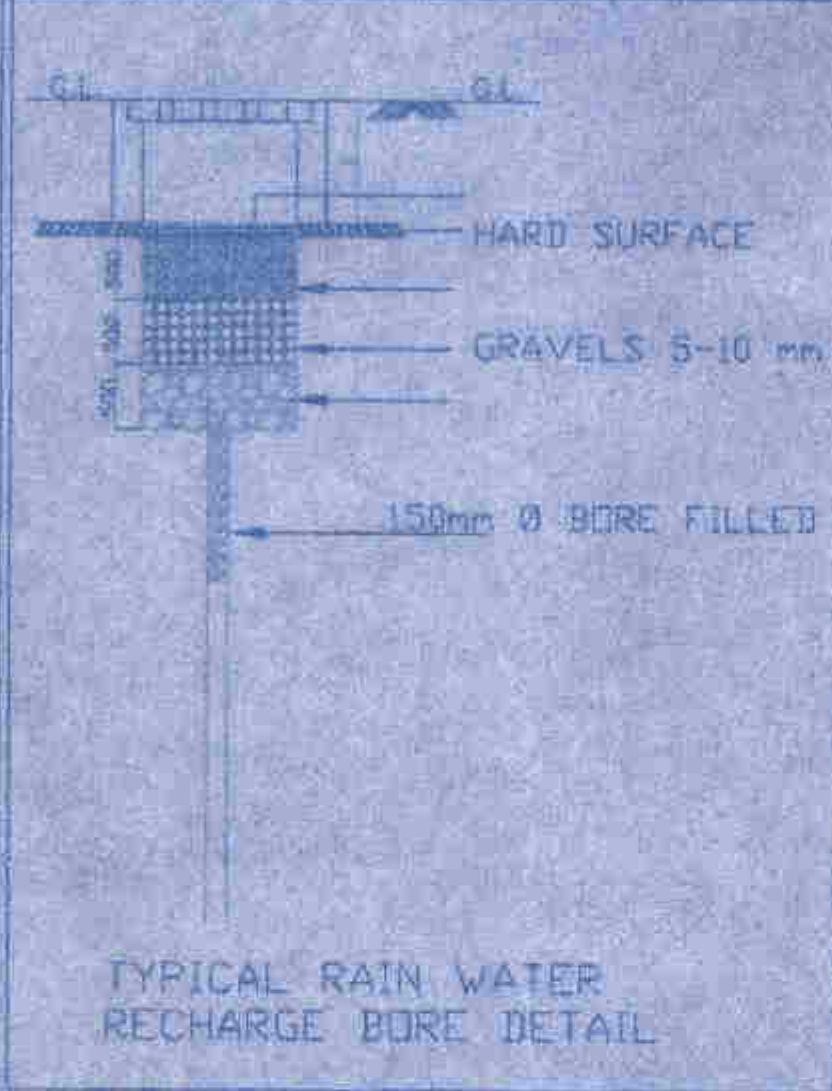

TYPICAL RAIN WATER RECHARGE BORE DETAIL

EXTERNAL STORM WATER LAYOUT

N  
O  
T  
E  
S



**PARTY'S COPY**

- 1) Permitted to make Connection to the plot/ bulk departmental manhole provided for the plot above the invert level in the manhole.
- 2) Permitted to make Connection from the plot to adjacent departmental storm drain above the invert level in the drain.
- 3) Permitted for above Connection are given subject to the condition that all debris should be cleared from all the service lines by the plot holder.

**NOTE**

THIS SANCTION IS ONLY FOR WATER SUPPLY/  
SEWERAGE AND DRAINAGE LAYOUT PLAN

PIN NO: 241E / NIKDA / BPS-02 / 2016 DT: 11.5.2016

*Sanganti Majumdar*

Assistant Architect  
New Town Kolkata Development Authority

*S. Chatterjee*

SUKRIT CHATTERJEE  
Chief Architect  
New Town Kolkata Development Authority