



| SLEEVE | DESCRIPTION | NOS OF SLEEVE | TYPE OF INSERTS |
|--------|--|---------------|-----------------|
| S01 | Ø150mm MUNICIPAL INTERNAL INLET | 03 | SINGLE FLANGE |
| S02 | Ø150mm 4 WAY SIAMESE INTERNAL CONNECTION | 01 | SINGLE FLANGE |
| S03 | Ø100mm 2WAY DRAW OFF INTERNAL CONNECTION | 01 | DOUBLE FLANGE |
| S04 | Ø300mm FIRE FIGHTING WATER TANK OUTLET | 02 | DOUBLE FLANGE |
| S05 | Ø100mm DOMESTIC WATER TANK OUTLET | 03 | DOUBLE FLANGE |
| S06 | Ø100mm VENT PIPE SLEEVE | 05 | SINGLE FLANGE |
| S07 | Ø100mm TEST LINE | 01 | SINGLE FLANGE |
| S08 | Ø25mm LEVEL INDICATOR SLEEVE | 10 | SINGLE FLANGE |
| S09 | 100mmØ SCOUR PIPE | 05 | SINGLE FLANGE |
| SUMP | 750mm(L)x750mm(W)x600mm(D) | 05 | |

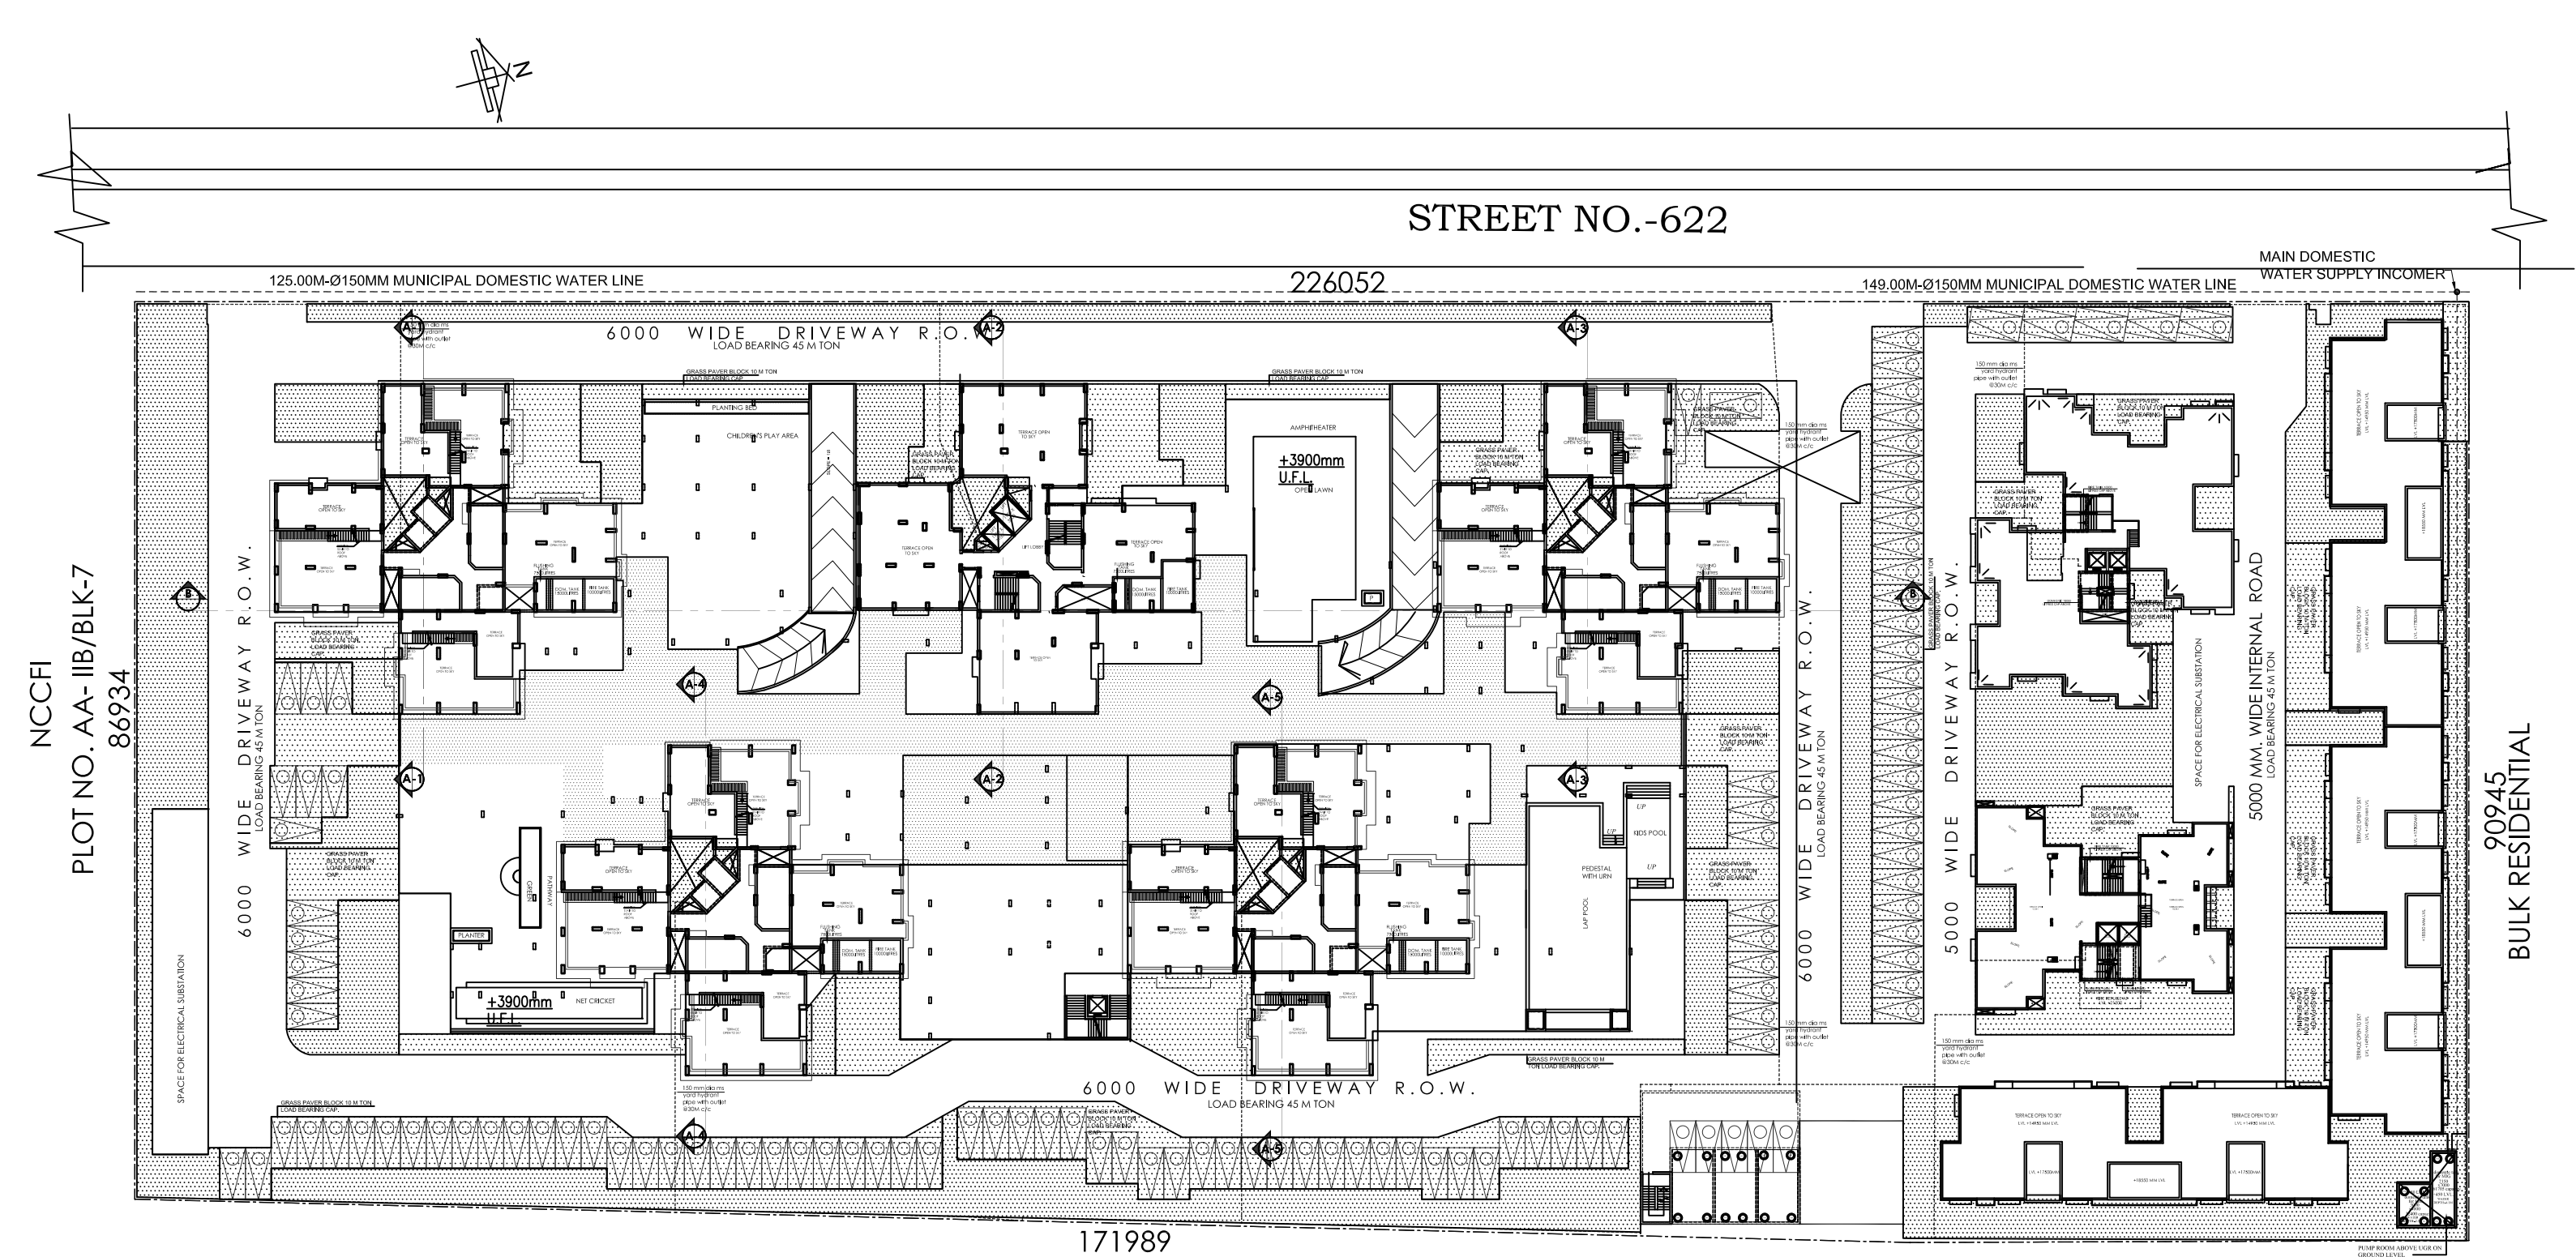

LOCATION PLAN
Scale = 1:1000

SITE PLAN
SCALE 1:600

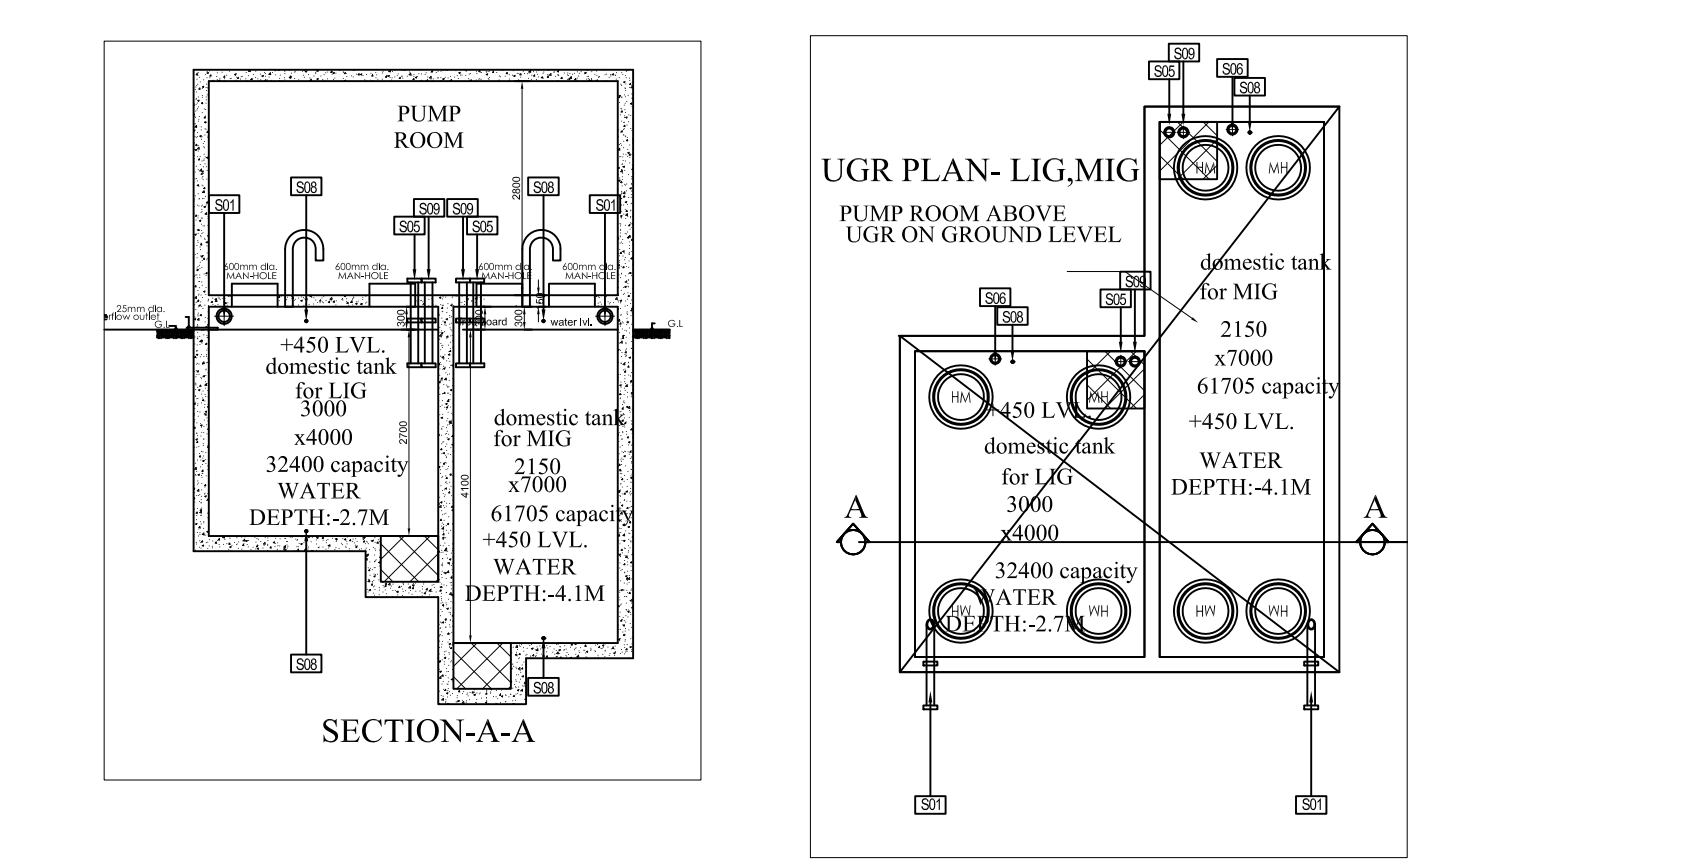