



FIRE PUMP ROOM AT LEVEL -5000 BELOW

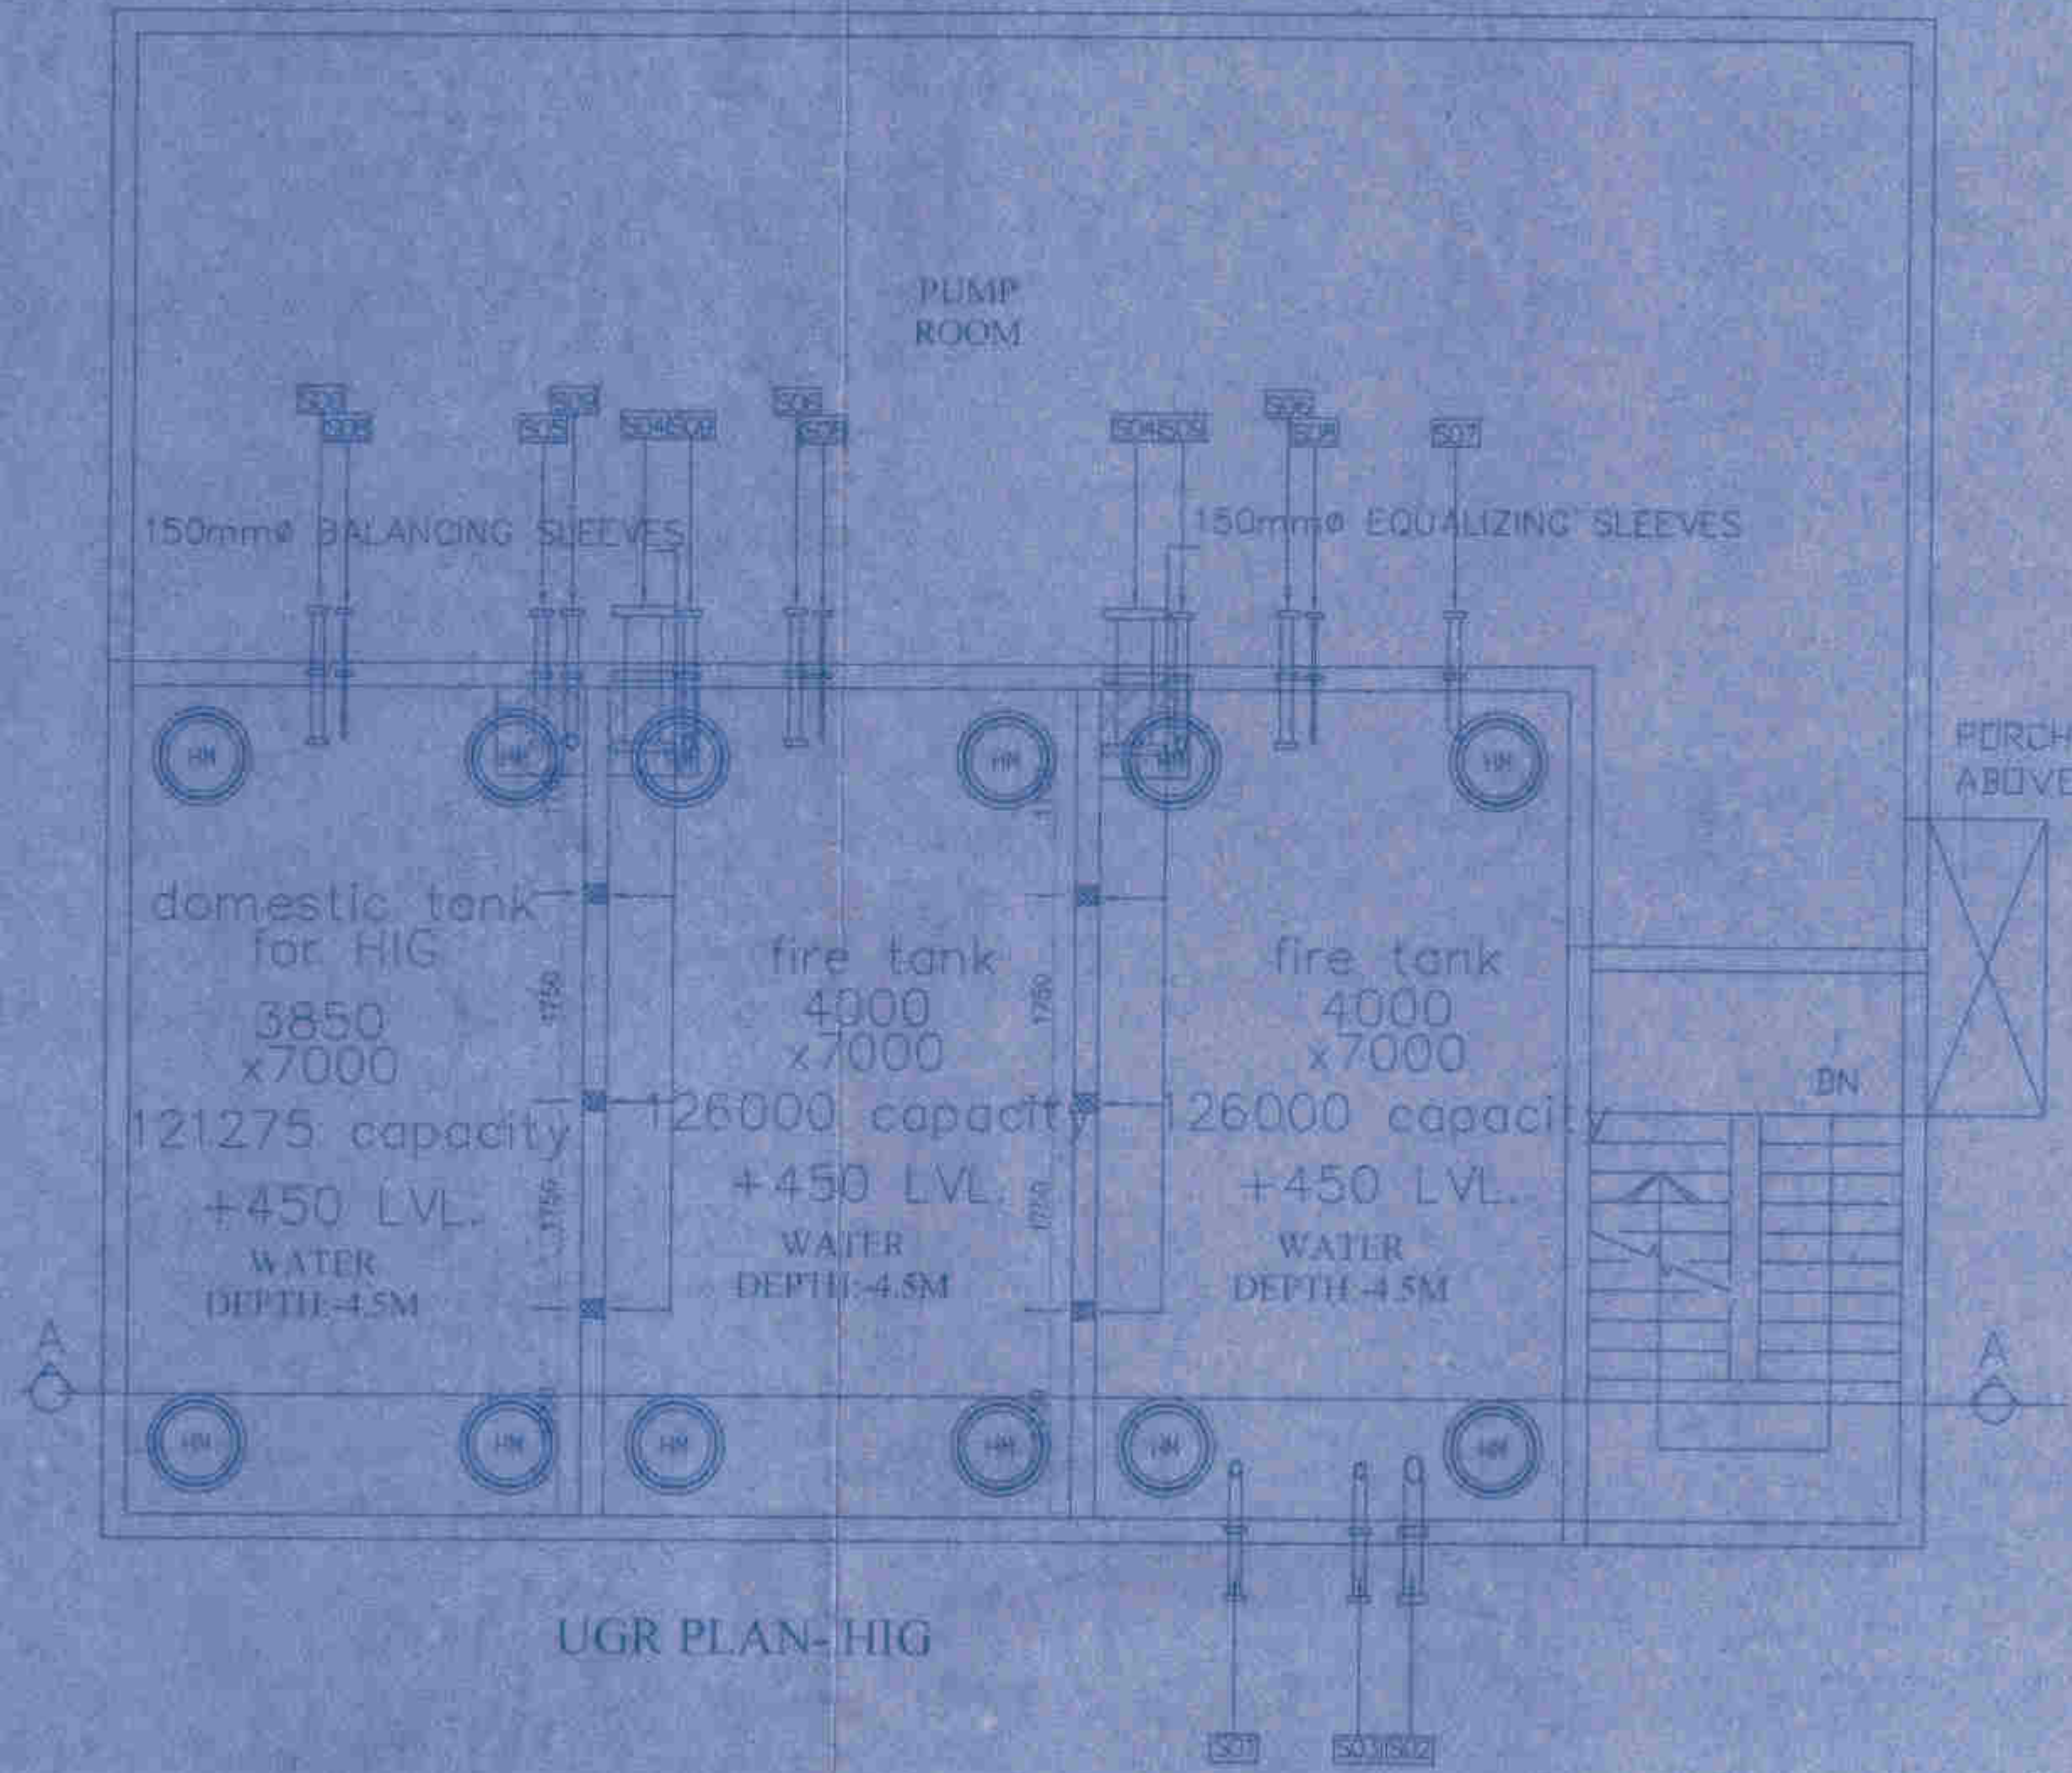

UGR PLAN-HIG

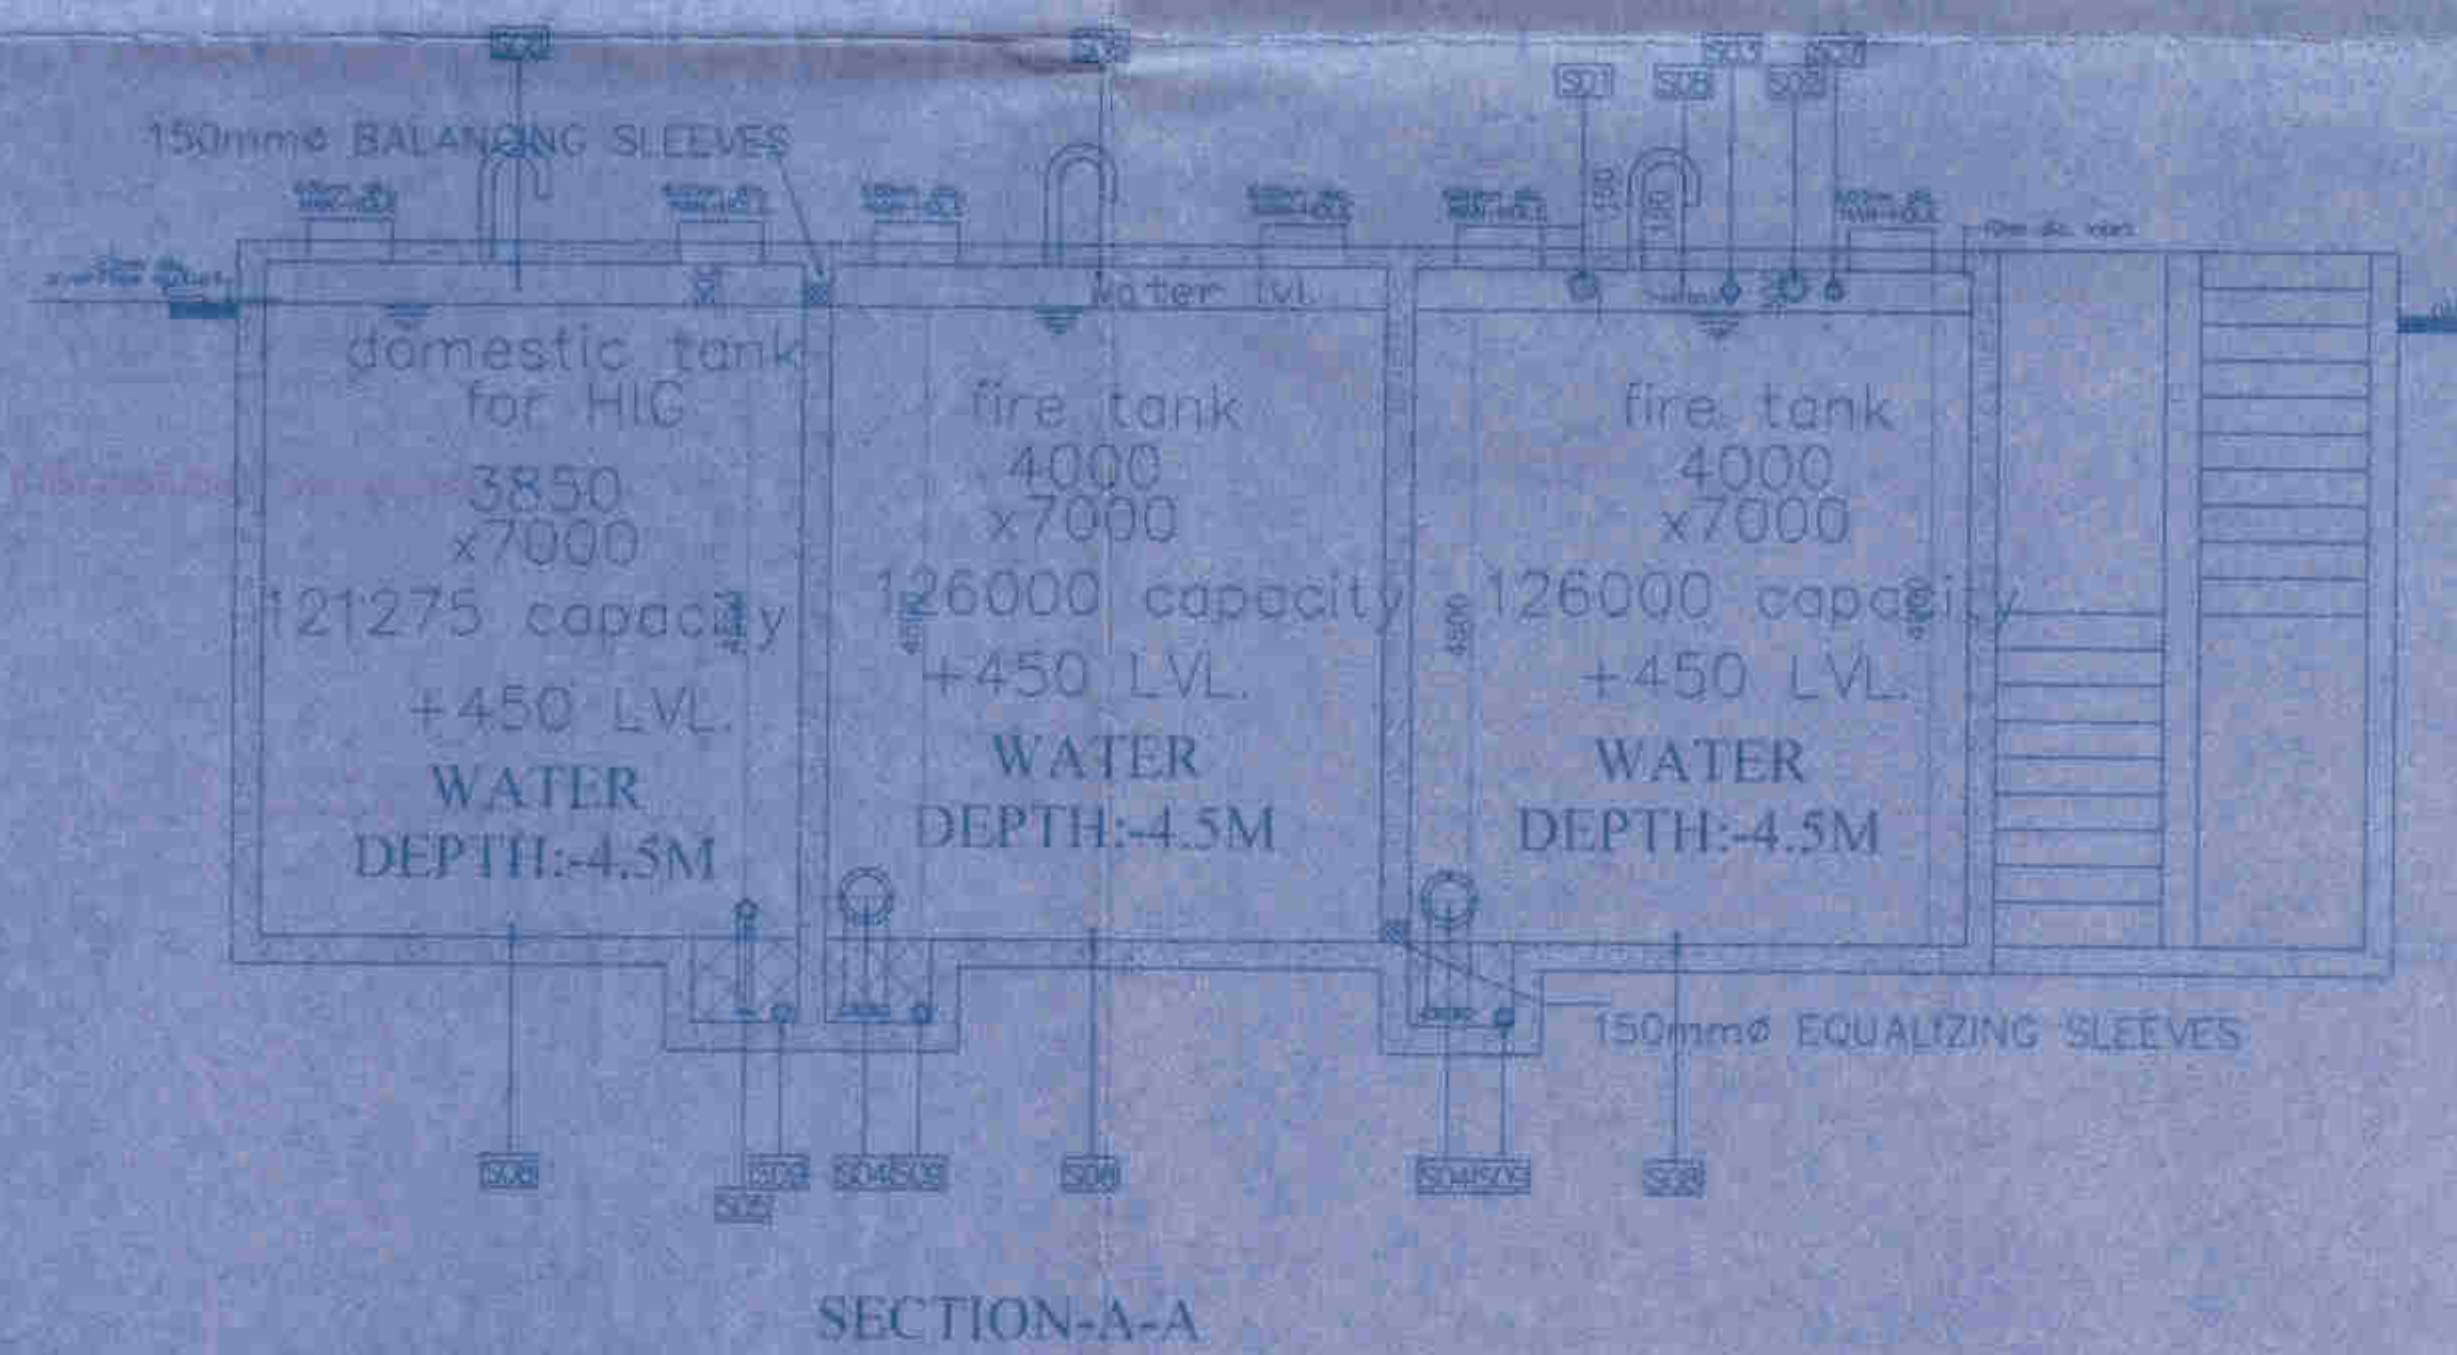



SECTION-A-A

UGR PLAN & SECTION

NOTES

UGR PLAN- LIG, MIG

PUMP ROOM ABOVE
UGR ON GROUND LEVEL

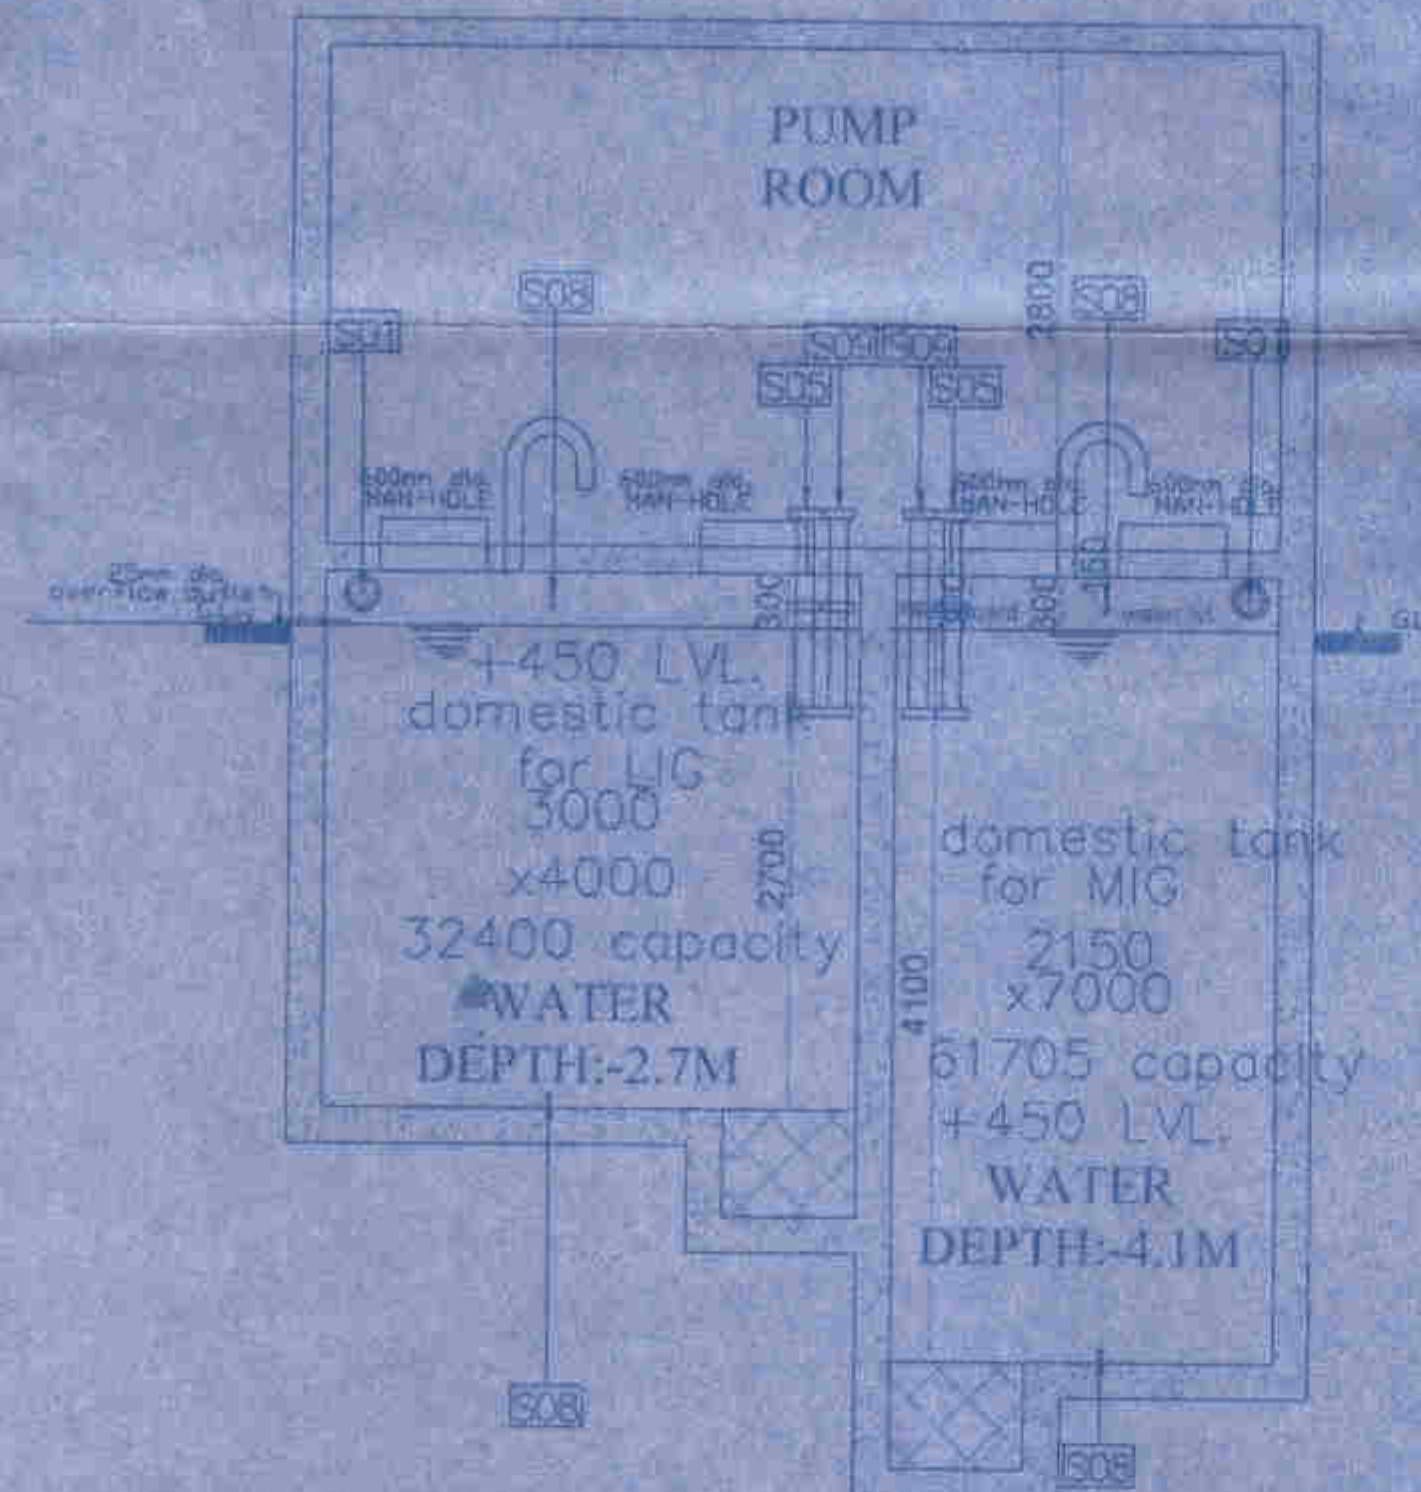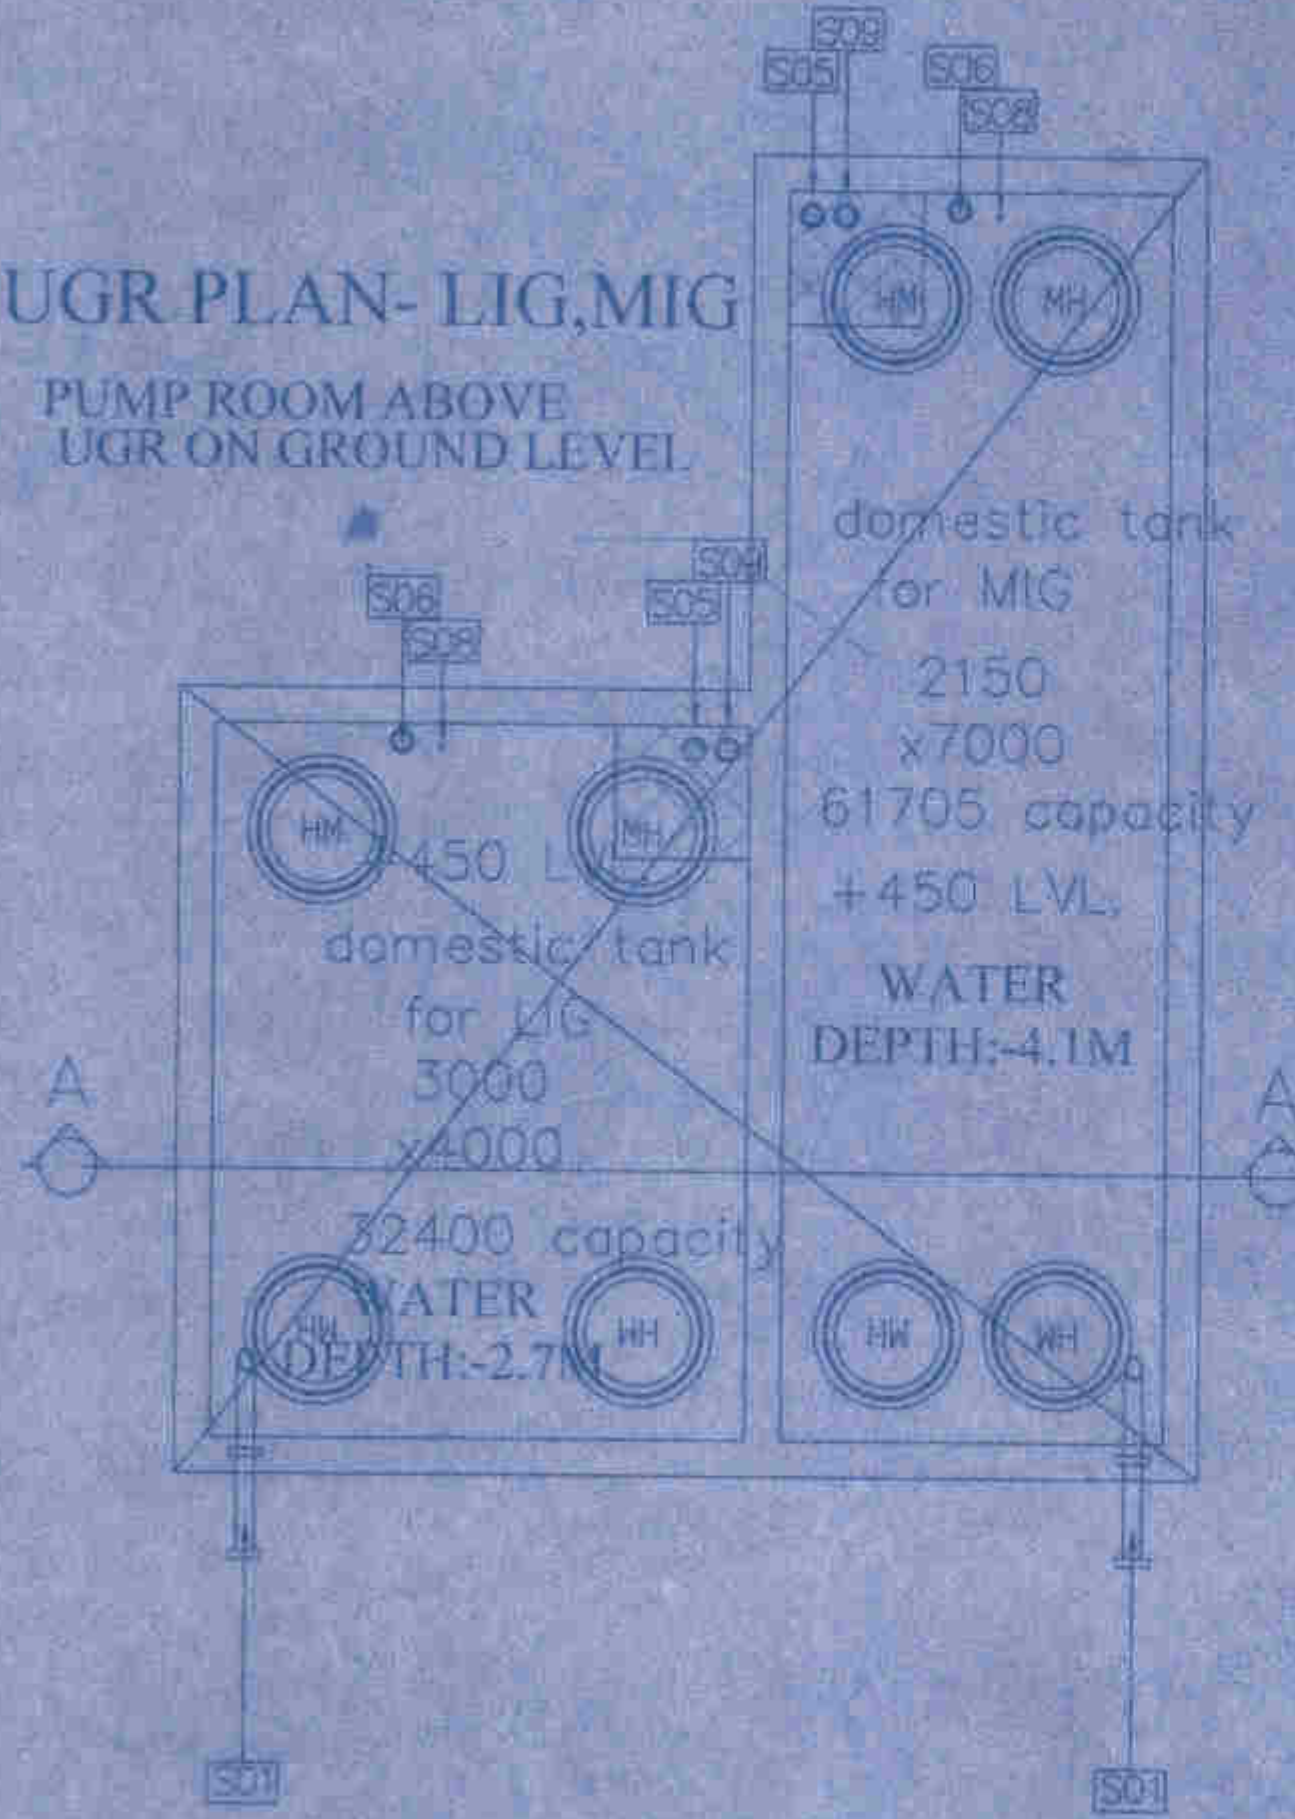

SECTION-A-A



KEY PLAN

NO.	REVISION	DATE	BY	CHECKED

Basudeb Das
Basudeb Das
B.E. (Civil), M.C.E. (Res. Engg.)
Consulting Public Health Engineer
RIVER / NKDA / 19 / 08004

BENGAL EMAMI HOUSING LTD.
Authorized Signatory

1618 BENGAL EMAMI HOUSING LTD. KOLKATA

NO.	DATE	PARTICULARS	ISSUED	CHECKED

OWNER: BENGAL EMAMI HOUSING LTD.

ARCHITECT: ARCHITECT RAJESH CHAKRABORTY

SCALE: 1:30 REVISION: RD

STATUS: NKDA SUBMISSION

TITLE: UGR PLAN & SECTION

DRAWING NO: 1618/P/C/UGR/102A

DATE: 20.10.15

DRAWN BY: PRASHANT B.

DESIGNED BY: PRASHANT B.


CHECKED BY: NISHANT C.

APPROVED BY: ANAND J.

Harsh Sanon

HARSH SANON
COUNCIL OF ARCHITECTURE
REGISTRATION NO. CA/10/1355A

SR NO	CAMPARTMENT	CAPACITY	WATER DEPTH
1	DOM. & FLU FOR HIG	1,21,275 LTR	450MM
2	DOM. & FLU FOR MIG	61,705 LTR	410MM
3	DOM. & FLU FOR LIG	32,400 LTR	270MM
4	FIRE FIGHTING 1	1,26,000 LTR	450MM
5	FIRE FIGHTING 2	1,26,000 LTR	350MM

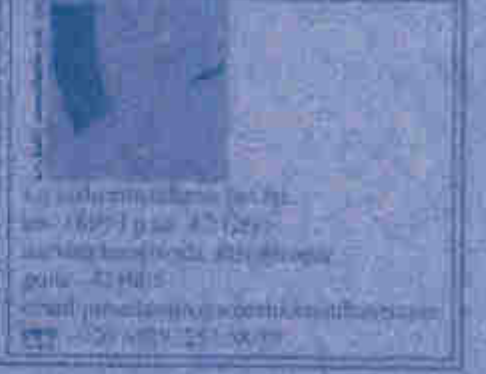

PARTY'S COPY

WATER SUPPLY LINE AVAILABLE

NOTE
THIS SANCTION IS ONLY FOR WATER SUPPLY/
SEWERAGE AND DRAINAGE LAYOUT PLAN

PIN NO : 2416 / NKDA / BPS-02 / 2014 DT : 11.5.2016


Assistant Architect
New Town Kolkata Development Authority


SUKRIT CHATTERJEE
Chief Architect
New Town Kolkata Development Authority