


PROPOSED ELECTRICAL SYSTEM
 DRAWING NO. E-100-1000
 SHEET NO. 1 OF 1
 PROJECT: [illegible]
 CLIENT: [illegible]
 DATE: [illegible]

ELECTRICAL ENGINEER: [illegible]
 PROJECT MANAGER: [illegible]

APPROVED BY: [illegible]
 DATE: [illegible]

ALL RIGHTS RESERVED
 No part of this publication may be reproduced, stored in a retrieval system, or transmitted, in any form or by any means, electronic, mechanical, photocopying, recording, or by any information storage and retrieval system, without the prior written permission of the publisher.

Electrical Engineering
 [illegible]
 [illegible]

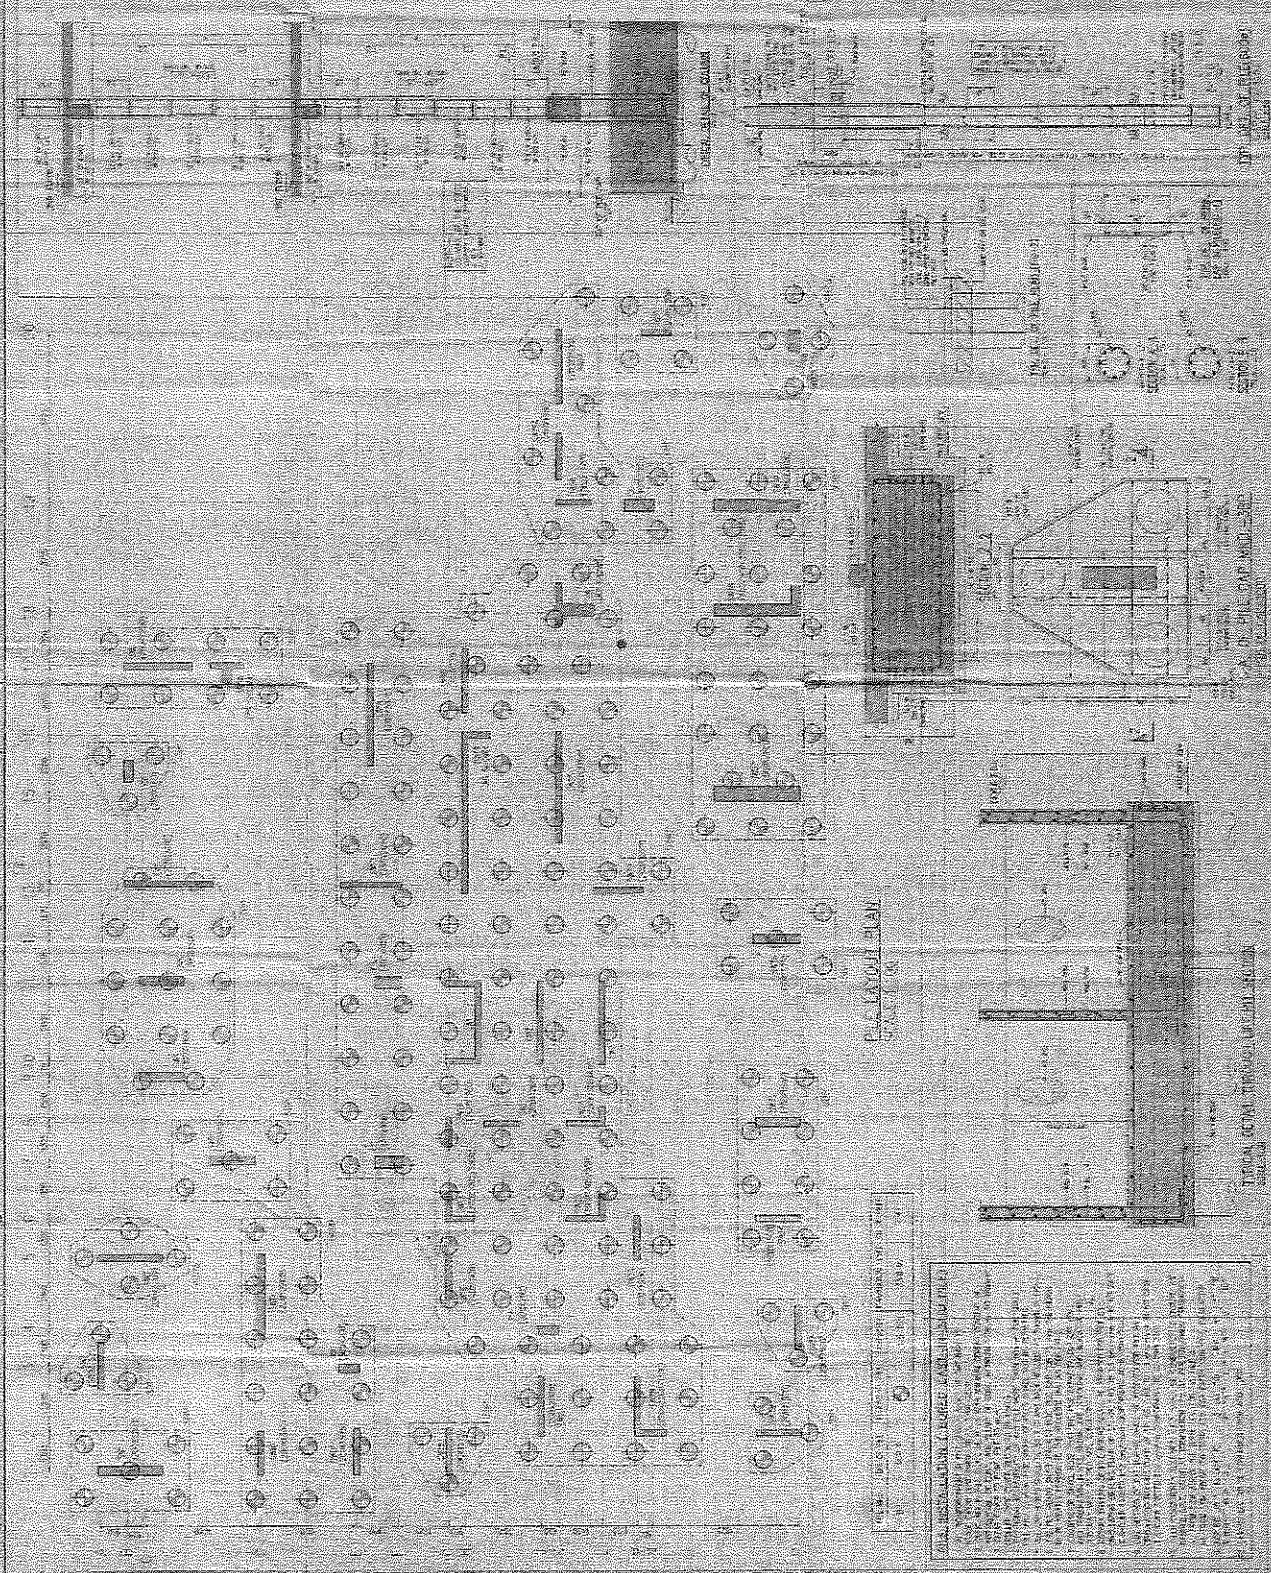

ELECTRICAL FLOOR PLAN
 SCALE: 1/4" = 1'-0"

NO.	DESCRIPTION	QUANTITY	UNIT
1	[illegible]	[illegible]	[illegible]
2	[illegible]	[illegible]	[illegible]
3	[illegible]	[illegible]	[illegible]
4	[illegible]	[illegible]	[illegible]
5	[illegible]	[illegible]	[illegible]

ALL RIGHTS RESERVED
 No part of this publication may be reproduced, stored in a retrieval system, or transmitted, in any form or by any means, electronic, mechanical, photocopying, recording, or by any information storage and retrieval system, without the prior written permission of the publisher.

ELECTRICAL FLOOR PLAN
 SCALE: 1/4" = 1'-0"

Sanctioned by the Committee at
the meeting held on 21/11/2007
Vote: 10/10

Sanctioned by the Committee at
the meeting held on 21/11/2007
Vote: 10/10

Sanctioned by the Committee at
the meeting held on 21/11/2007
Vote: 10/10



SANCTIONED
by the Committee at the meeting held on 21/11/2007
Vote: 10/10
Sanctioned by the Committee at the meeting held on 21/11/2007
Vote: 10/10